



Trust for Public Land


Zamora Park Renovation Project

ADDENDUM #5

October 15, 2024

This Addendum includes the following changes/clarifications:


1. Revised E2.0 – Lighting and Power Plan, appended to this Addendum.

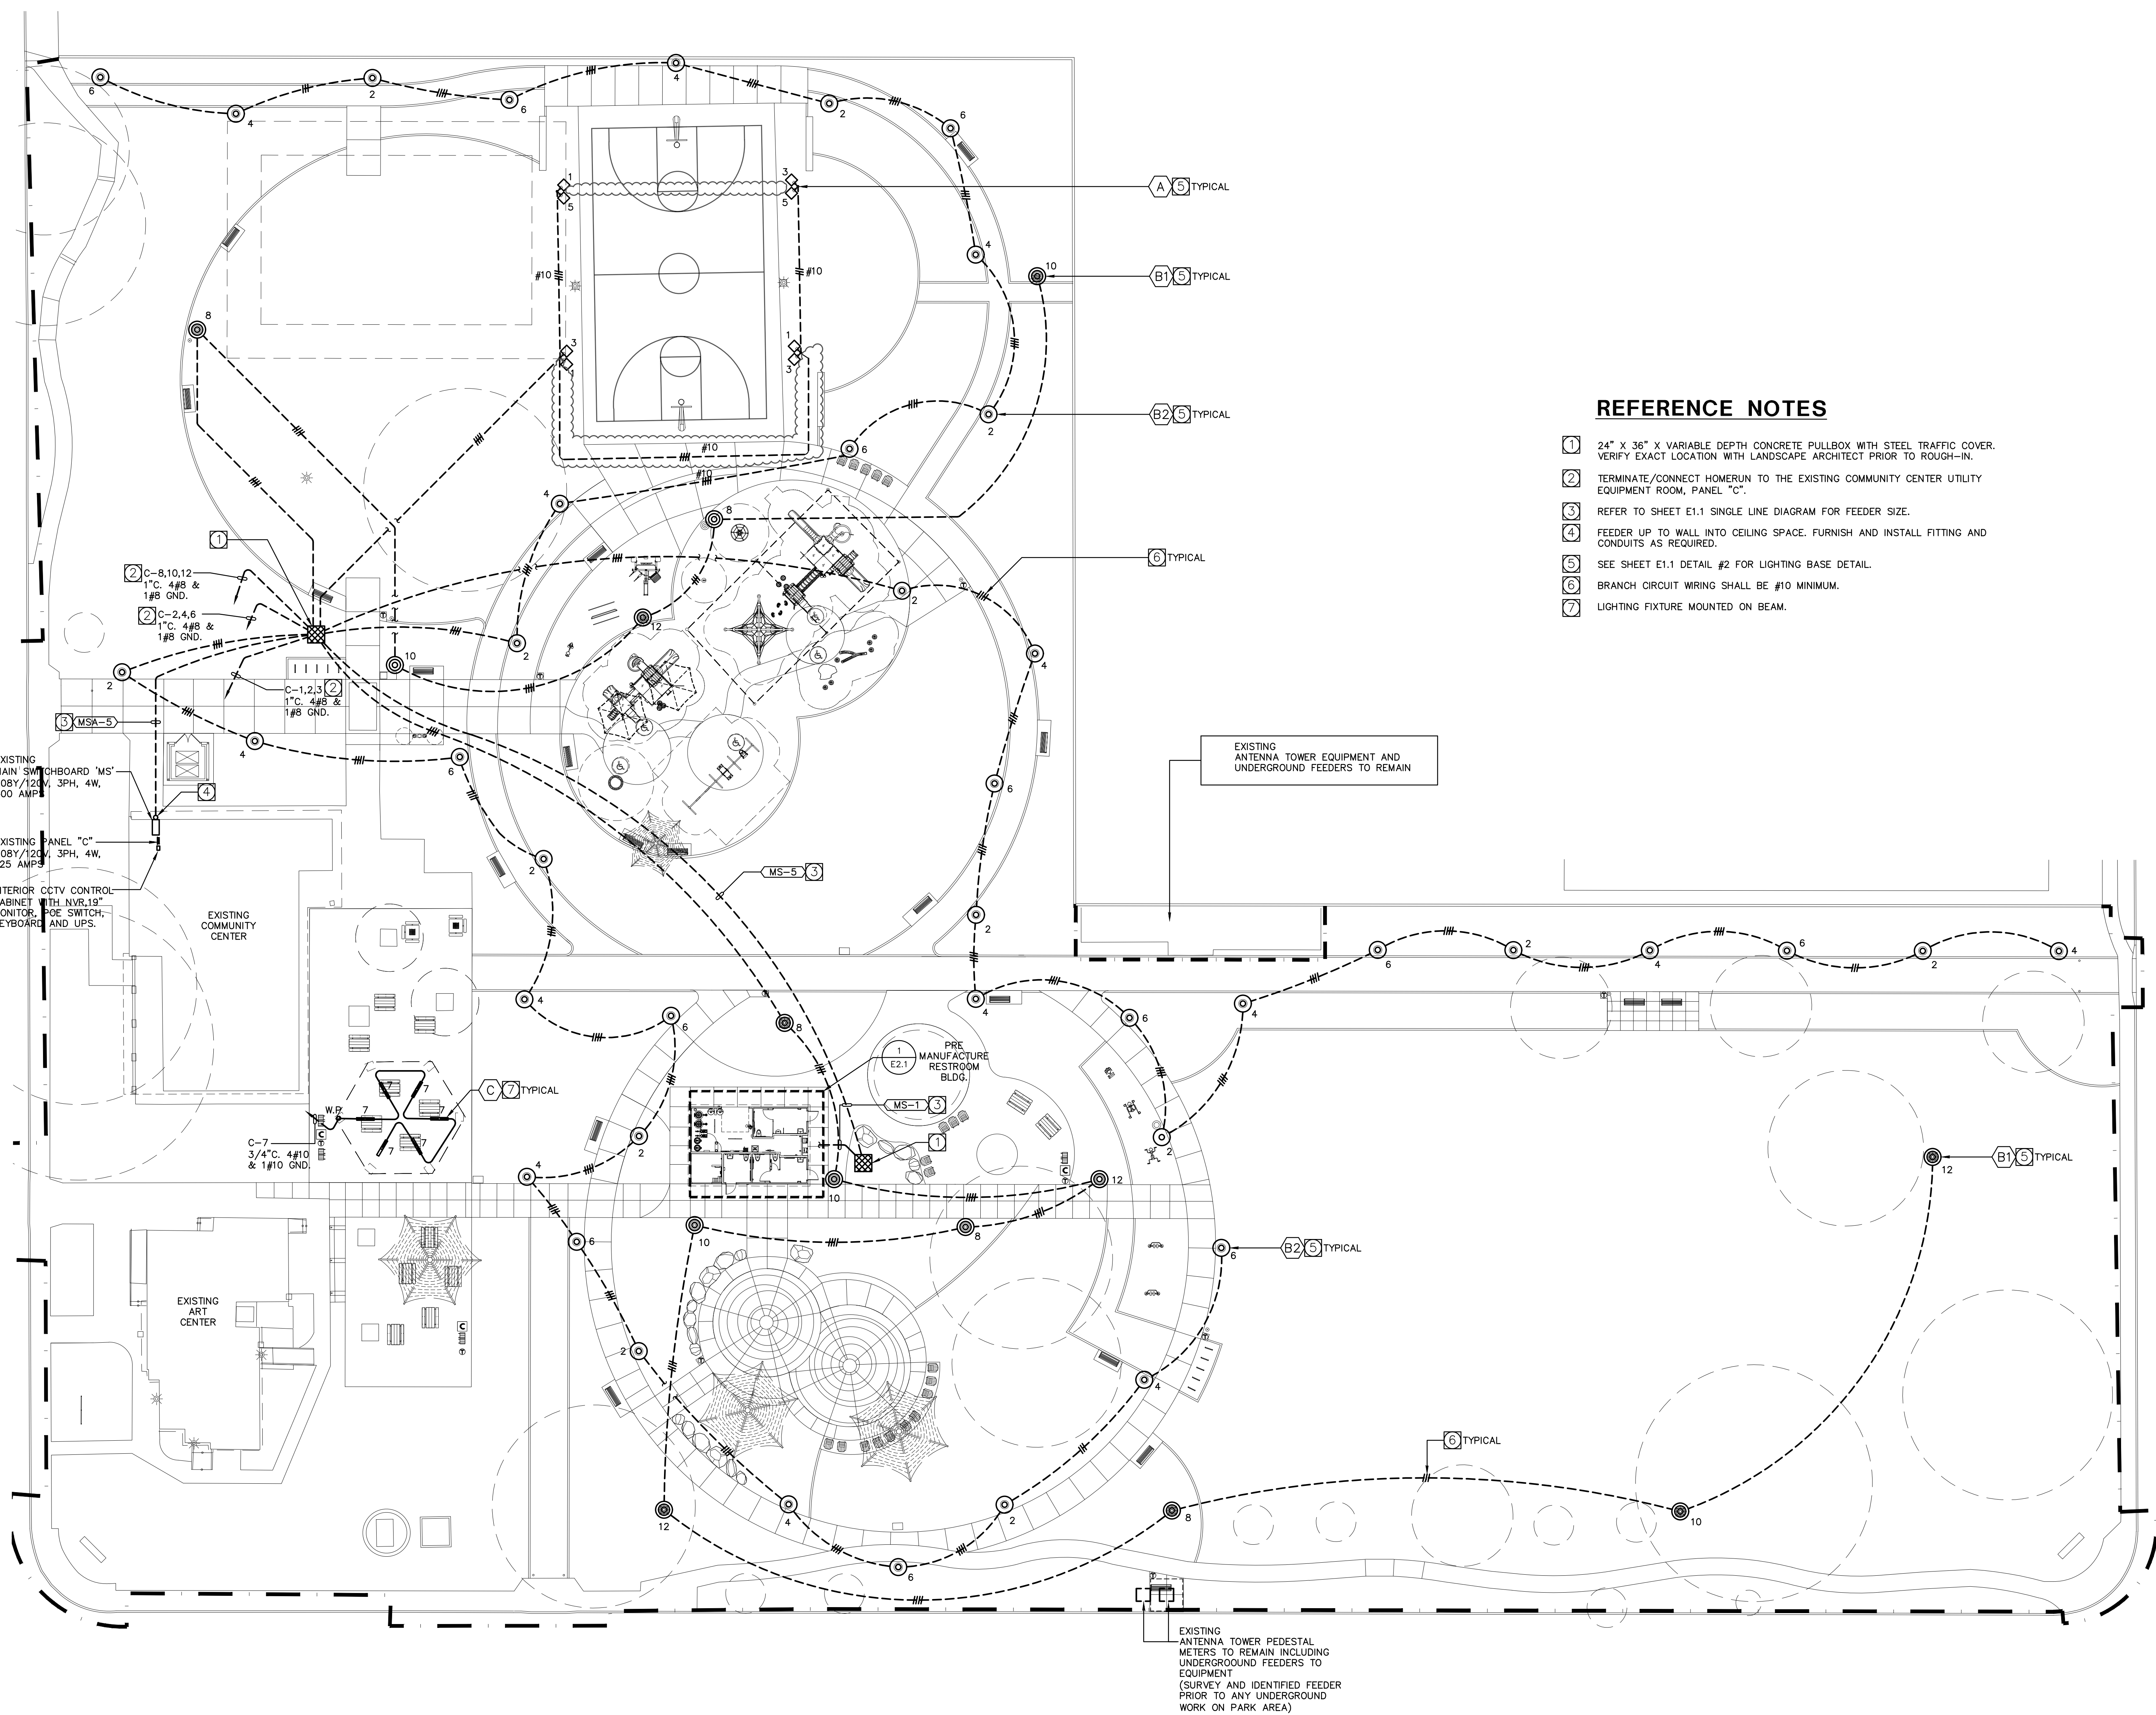

REFERENCE NOTES

- 1 24" X 36" X VARIABLE DEPTH CONCRETE PULLBOX WITH STEEL TRAFFIC COVER. VERIFY EXACT LOCATION WITH LANDSCAPE ARCHITECT PRIOR TO ROUGH-IN.
- 2 TERMINATE/CONNECT HOMERUN TO THE EXISTING COMMUNITY CENTER UTILITY EQUIPMENT ROOM, PANEL "C".
- 3 REFER TO SHEET E1.1 SINGLE LINE DIAGRAM FOR FEEDER SIZE.
- 4 FEEDER UP TO WALL INTO CEILING SPACE. FURNISH AND INSTALL FITTING AND CONDUITS AS REQUIRED.
- 5 SEE SHEET E1.1 DETAIL #2 FOR LIGHTING BASE DETAIL.
- 6 BRANCH CIRCUIT WIRING SHALL BE #10 MINIMUM.
- 7 LIGHTING FIXTURE MOUNTED ON BEAM.


UNDERGROUND SERVICE ALERT
CALL TOLL FREE: 1-800-485-5111
FOR SOUTHERN CALIF. 1-800-485-5111
FOR NORTHERN CALIF. 1-800-485-5111
TWO WORKING DAYS
BEFORE YOU DIG

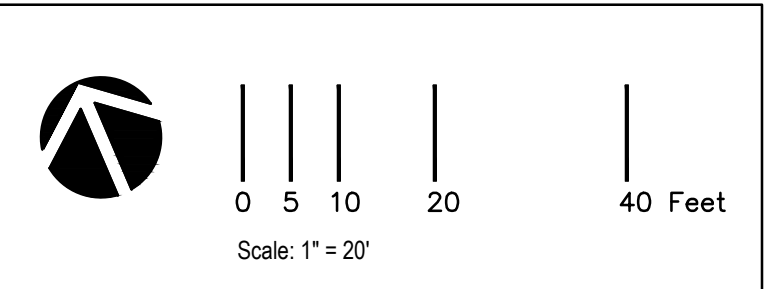

Know what's below.
Call before you dig.

REVISIONS				
NO.	DATE	DESCRIPTION	ENGR.	APPROV.
1	10/20/23	BID SET		

ecco engineering firm LLC
CONSULTING ELECTRICAL ENGINEERS
726 WEST BROADWAY, SUITE A
GLENDALE, CALIFORNIA 91204
TEL: (818) 907-8823
eccoeng@earthlink.net

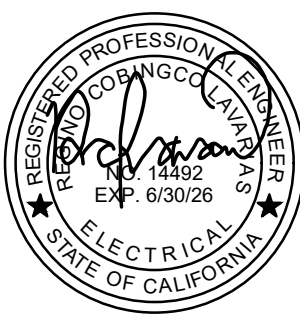

CITY OF EL MONTE
DEPARTMENT OF PUBLIC WORKS
11333 VALLEY BOULEVARD
EL MONTE, CA 91731
(626) 580-2058
www.ci.el-monte.ca.us

APPROVED BY:
LEE TORRES, P.E.
CITY ENGINEER
DATE
REVIEWED AND RECOMMENDED BY
PROJECT MANAGER
DATE

CITY OF EL MONTE
DEPARTMENT OF PUBLIC WORKS
ENGINEERING DIVISION
LIGHTING AND POWER PLAN
ZAMORA PARK

CITY OF EL MONTE PROJECT	
CIP NO. 013	
DATE 05/08/2023	DESIGNED BY: AM
SCALE AS SHOWN	DRAWN BY: BEN
PLAN NUMBER E-2.00	CHECKED BY:
SHEET 21	OF 61