

CITY OF PORTERVILLE
CALIFORNIA
COMMUNITY CENTER & PARK PROJECT
PROJECT NO: 89-9411-88
BID NO: 24/25-CP1977

BEGINNING OF ADDENDUM No. 7

Date: January 3, 2025

ITEM No. 1

On page three (3), first paragraph, of the project manual, change bid opening date and time from Tuesday, January 7, 2025, at 2:30 p.m. (as modified in Addendum 4) to **Thursday, January 16, 2025, at 2:30 p.m.**

ITEM No. 2

Updated Specification Section 10 1423 Panel Signage is attached herein for incorporation into the project manual.

ITEM No. 3

Plan sheets S-105, S-213, S-221, S-401, and A903 have been updated and bubbled for reference. They are attached herein for incorporation into the plan set.

ITEM No. 4

Updated bid sheets (pages 13-15 of the project manual) are attached herein for use and incorporation into the project manual. The updated breakdown is to assist in the computing of the general contractors responsibility for the project by specifying the lines for Specialty Trades.

ITEM No. 5

An updated subcontractor's list form is attached herein for use and incorporation into the project manual.

END OF ADDENDUM No. 7

/s/ Janie Rodriguez, Purchasing Agent

This addendum must be signed and submitted with the sealed bid proposal.

Bid proposals submitted without this sheet will not be considered.

Firm: _____

By: _____

Authorized Signature

Date: _____

Section 10 1423

Panel Signage

PART 1 GENERAL

1.01 Section Includes

- A. Panel signage.

1.02 Reference Standards

- A. ADA Standards - 2010 ADA Standards for Accessible Design; 2010.
- B. ICC A117.1 - Accessible and Usable Buildings and Facilities; 2017.

1.03 Submittals

- A. See Section 01 3300 - Submittals for submittal procedures.
- B. Product Data: Manufacturer's product literature for each type of panel sign, indicating styles, font, foreground and background colors, locations, and overall dimensions of each sign.
- C. Shop Drawings:
 - 1. Include dimensions, locations, elevations, materials, text and graphic layout, attachment details, and schedules.
 - 2. Schedule: Provide information sufficient to completely define each panel sign for fabrication, including room number, room name, other text to be applied, sign and letter sizes, fonts, and colors.
 - a. When room numbers to appear on signs differ from those on drawings, include the drawing room number on schedule.
 - b. When content of signs is indicated to be determined later, request such information from Owner through Architect at least 2 months prior to start of fabrication; upon request, submit preliminary schedule.
 - c. Submit for approval by Owner through Architect prior to fabrication.
- D. Samples: Submit two samples of each type of sign, of size similar to that required for project, indicating sign style, font, and method of attachment.
- E. Selection Samples: Where colors, materials, and finishes are not specified, submit two sets of color selection charts or chips.
- F. Manufacturer's Installation Instructions: Include installation templates and attachment devices.
- G. Manufacturer's qualification statement.
- H. Maintenance Materials: Furnish the following for Owner's use in maintenance of project.

1.04 Quality Assurance

- A. Manufacturer Qualifications: Company specializing in manufacturing the products specified in this section with minimum three years of documented experience.

1.05 Delivery, Storage, and Handling

- A. Package signs as required to prevent damage before installation.
- B. Package room and door signs in sequential order of installation, labeled by floor or building.
- C. Store tape adhesive at normal room temperature.

1.06 Field Conditions

- A. Do not install tape adhesive when ambient temperature is lower than recommended by manufacturer.
- B. Maintain minimum ambient temperature during and after installation.

PART 2 PRODUCTS

2.01 Manufacturers

- A. Panel Signage:
 - 1. Best Sign Systems, Inc; MP Blast: www.bestsigns.com/#sle. (Basis of Design)
 - 2. FASTSIGNS International, Inc: www.fastsigns.com/#sle.
 - 3. Seton Identification Products: www.seton.com/aec/#sle.

2.02 Regulatory Requirements

- A. Accessibility Requirements: Comply with ADA Standards and ICC A117.1 and applicable building codes, unless otherwise indicated; in the event of conflicting requirements, comply with the most restrictive requirements.

2.03 Panel Signage

- A. Panel Signage Provide a sign for every doorway, whether it has a door or not, not including corridors, lobbies, and similar open areas.:
 - 1. Application: Room and door signs.
 - 2. Description: Flat signs with engraved panel media, tactile characters.
 - 3. Sign Size: 4 inches by 6 inches typical, larger if required.
 - 4. Total Thickness: 1/8 inch.
 - 5. Sign Edges: Squared.
 - 6. Corners: Radiused.
 - 7. Color and Font, unless otherwise indicated:

- a. Character Font: Helvetica, Arial, or other sans serif font.
- b. Character Case: Upper case only.
- c. Background Color: As scheduled.
- d. Character Color: Contrasting color.
8. Material: Laminated colored plastic engraved through face to expose core as background color.
9. Profile: Flat panel without frame.
10. Tactile Letters: Raised 1/32 inch minimum.
11. Braille: Grade II, ADA-compliant.
12. One-Sided Wall Mounting: Tape adhesive.

2.04 SIGNAGE APPLICATIONS

A. Room and Door Signs:

1. Office Doors: Identify with room names and numbers to be determined later, not those indicated on drawings.
2. Conference and Meeting Rooms: Identify with room names and numbers to be determined later, not those indicated on drawings.
3. Service Rooms: Identify with room names and numbers to be determined later, not those indicated on drawings.
4. Rest Rooms: Identify with pictograms, the names "MEN" and "WOMEN" and braille.

B. Exterior Signs:

1. ***Provide 5 (five) No Smoking within 20 feet of main entrances, exits and operable windows.***

PART 3 EXECUTION

3.01 Examination

- A. Verify that substrate surfaces are ready to receive work.
- B. Notify Architect if conditions are not suitable for installation of signs; do not proceed until conditions are satisfactory.



3.02 Installation


- A. Install in accordance with manufacturer's instructions.
- B. Install with horizontal edges level.
- C. Locate panel signs and mount at heights indicated on drawings and in accordance with ADA Standards and ICC A117.1.
- D. Protect from damage until Date of Substantial Completion; repair or replace damaged items.

End of Section 10 1423

This page intentionally left blank

12/28/2024 8:57:52 AM
\\csag-fs01\lfrms\markw\Porterville_2022_Structural_danderson@csag.com.rvt

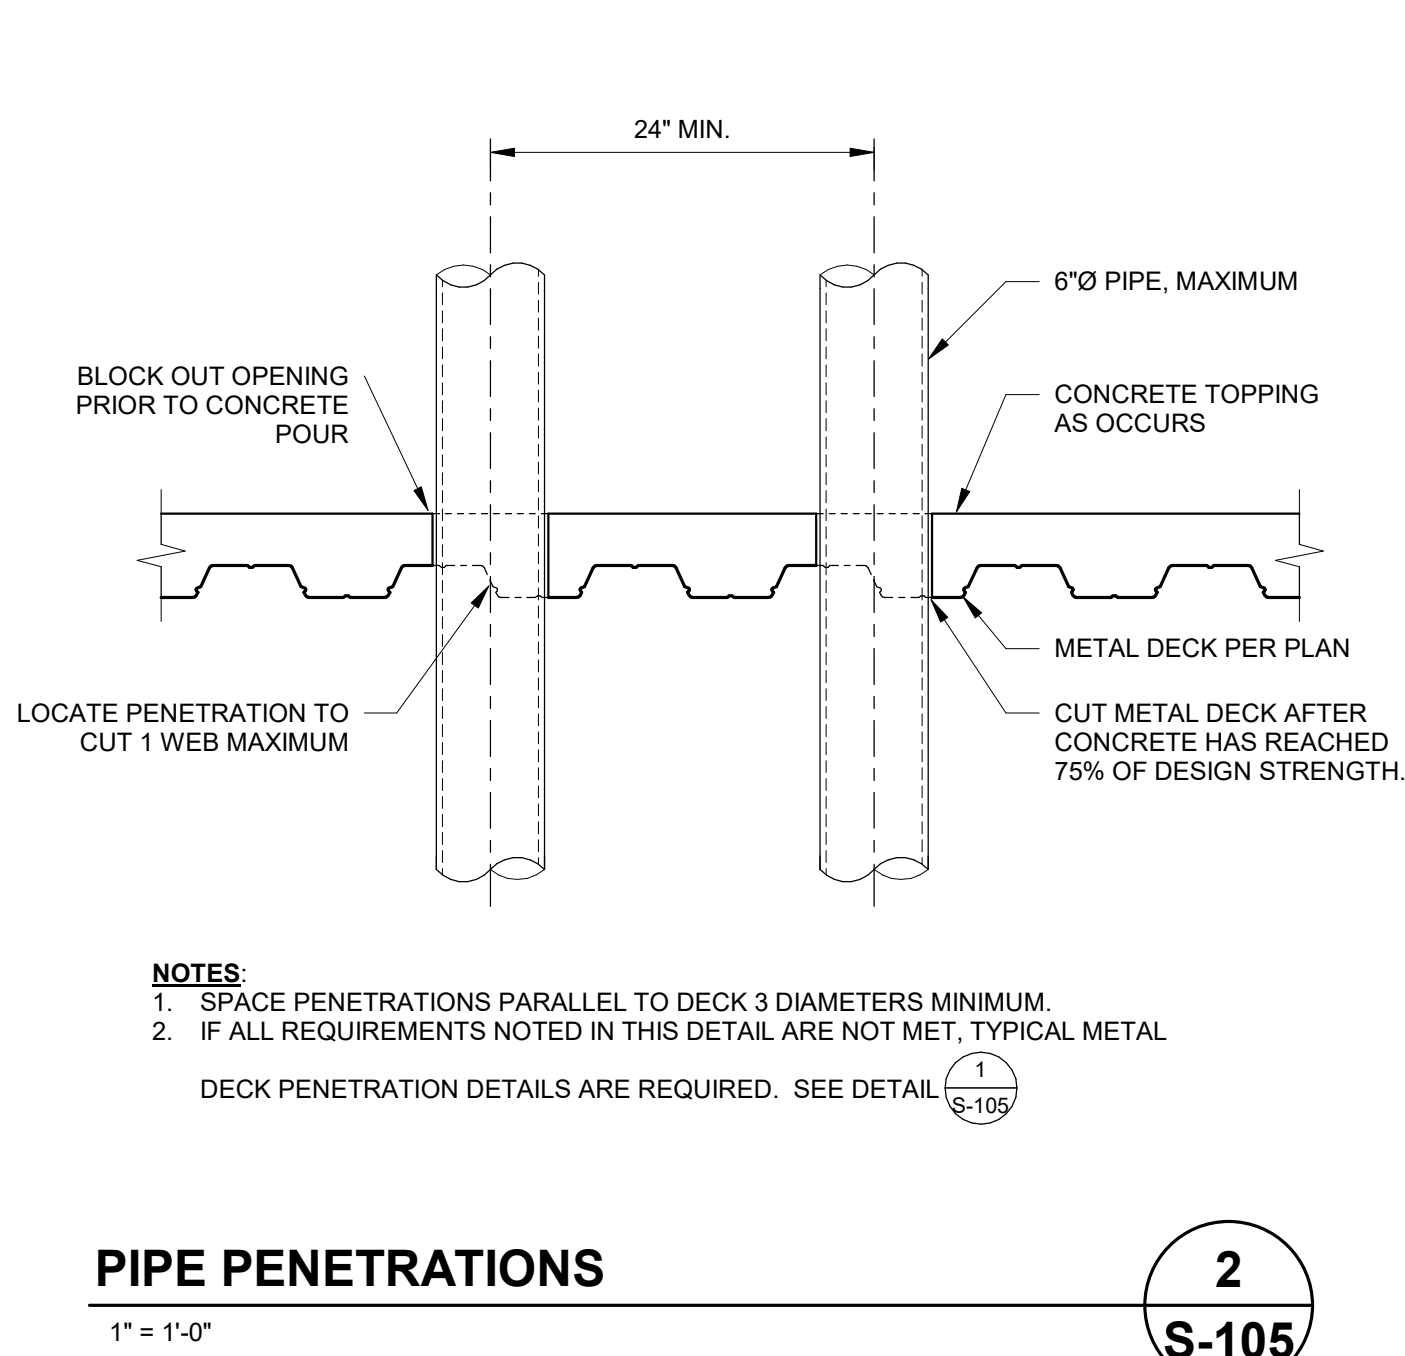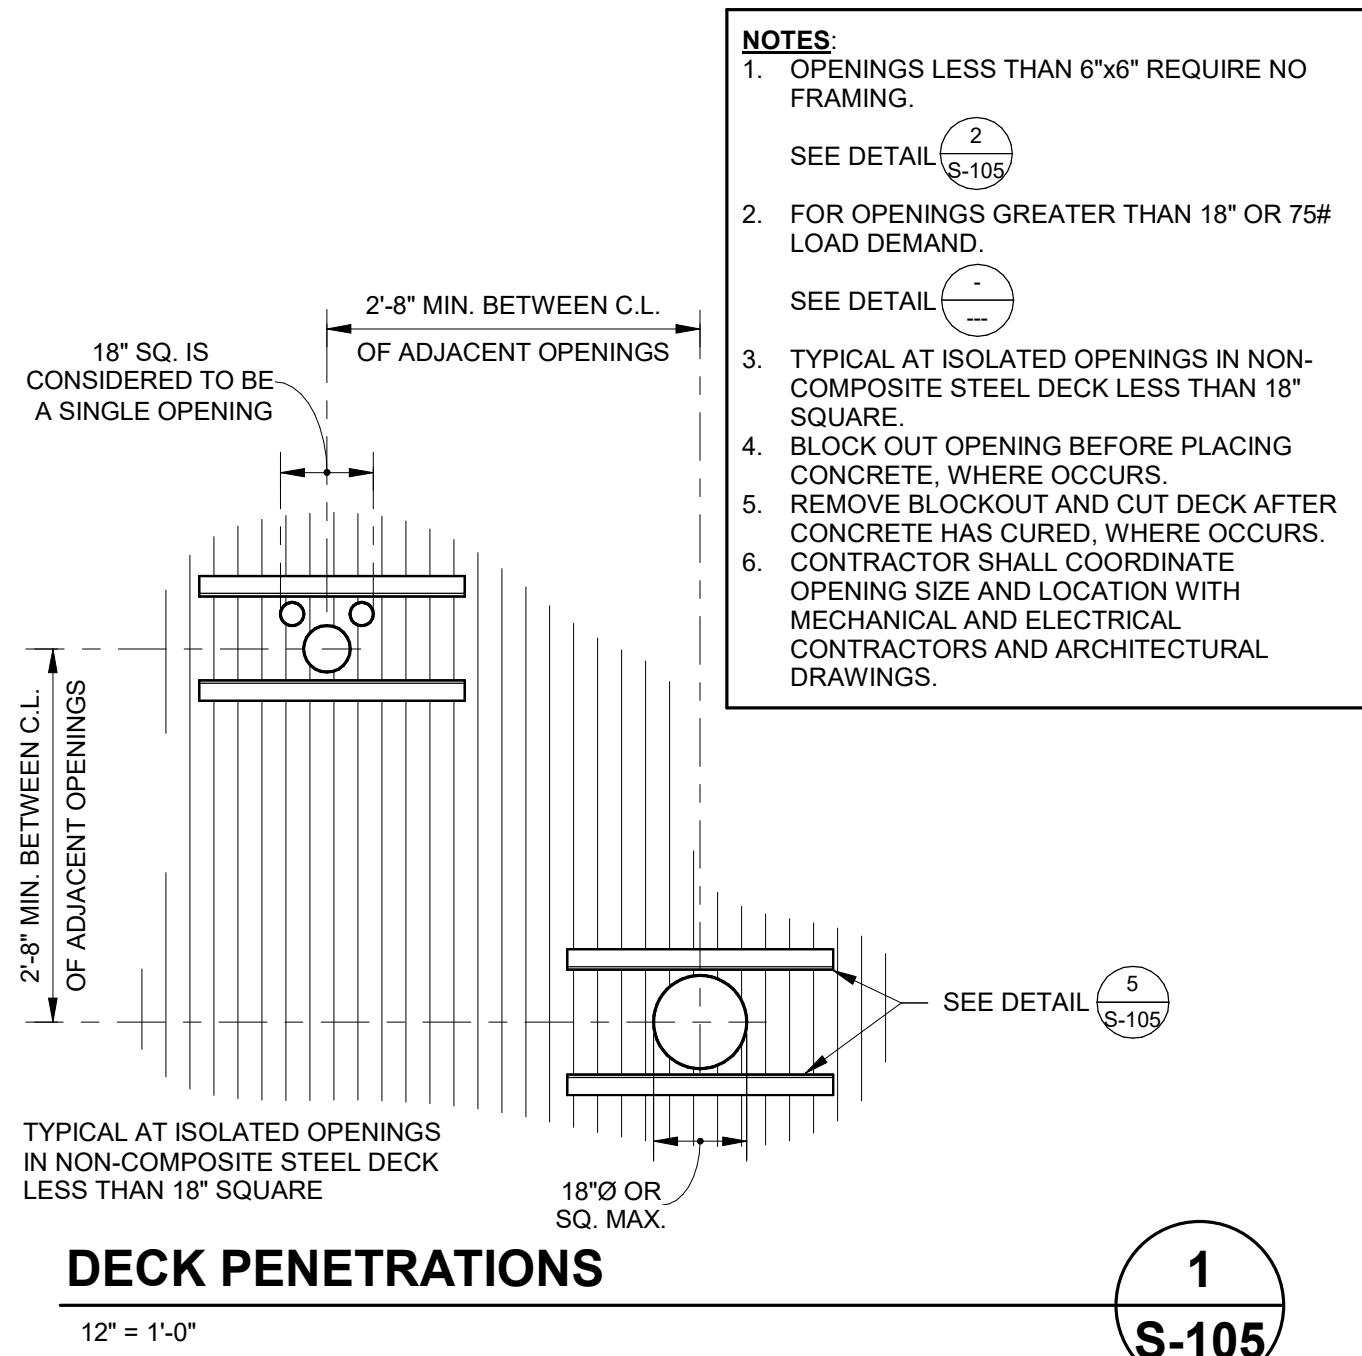

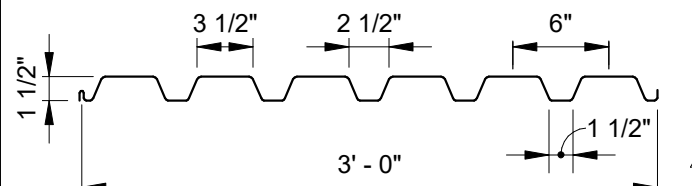STEEL DECK SCHEDULE										
TYPE	PRODUCT	IAPMO REPORT	HEIGHT (INCH)	GAGE	CONCRETE FILL (INCH)	REINFORCING	PROFILE	-1x MIN (IN ²)	+1x MIN (IN ²)	-Sx MIN (IN ²)
1	VERCO HSB-36 ACOUSTICAL	UES ER-2018	1.5	18	N/A	N/A		0.299	0.293	0.322
								0.306		ACOUSTICAL ROOF DECK

- NOTE:**
- METAL DECK SHALL BE CONTINUOUS OVER 3 SPANS WHERE POSSIBLE. CONTRACTOR SHALL DETERMINE SHORING REQUIREMENTS FOR DECK INSTALLATION.
 - METAL DECK SHALL BEAR A MINIMUM OF 2 INCHES AT ENDS AND 4 INCHES AT INTERMEDIATE SUPPORTING MEMBERS.
 - DECK FLUTES SHALL RUN PERPENDICULAR TO SUPPORTING MEMBERS UNLESS SHOWN OTHERWISE.
 - CONCRETE FILL THICKNESS IS MEASURED FROM TOP OF DECK TO TOP OF CONCRETE. CONTRACTOR TO COMPENSATE FOR FRAMING AND DECK DEFLECTION TO MAINTAIN LEVEL.
 - NO CONDUITS SHALL BE RUN WITHIN THE CONCRETE FILL UNLESS SPECIFICALLY DETAILED ON THE STRUCTURAL DRAWINGS.
 - MECHANICAL, ELECTRICAL, OR PLUMBING UTILITIES HUNG FROM STEEL DECK SHALL NOT EXCEED 100# PER HANGER AND SHALL BE SPACED SO THAT THE TOTAL UTILITY WEIGHT DOES NOT EXCEED 5 PSF.
 - PROVIDE BENT PLATE CLOSURES AT ALL DECK EDGES @ CONG FILL LOCATIONS, U.N.O.
 - THE CONTRACTOR SHALL PROTECT STEEL DECK DURING CONSTRUCTION. ANY DECKING WHICH IS FOUND TO BE DAMAGED SHALL BE REMOVED AND REPLACED AT THE CONTRACTOR'S EXPENSE.
 - AT WWF SPLICES OVERLAP ADJACENT MATS A MINIMUM OF 14". THERE SHALL BE A MINIMUM OF 2" BETWEEN CROSS WIRES OF THE LAPPED MATS.








METAL DECK SCHEDULE

NO SCALE

3
S-105

METAL DECK ATTACHMENT ⁽³⁾				
TYPE	TRANSVERSE SUPPORTS ^(1,2)	PARALLEL SUPPORTS ⁽²⁾	SIDE SEAMS	REMARKS
1	36/4	PUDDLE WELDS @ 12" O.C.	VERCO SIDELAP CONNECTIONS @ 36" O.C.	

- NOTE:**
- WELD DESIGNATION IS AS FOLLOWS:
A. 36/7/4 DENOTES 36 INCH WIDE DECK, 7 WELDS @ END PANEL SUPPORTS, 4 WELDS @ INTERIOR PANEL SUPPORTS.
B. 24/4 DENOTES 24 INCH WIDE DECK, 4 WELDS AT ALL PANEL SUPPORTS.
 - PUDDLE WELDS SHALL HAVE 1/2" EFFECTIVE DIAMETER. SEE 
 - A HEADED STUD WELDED THRU DECK MAY REPLACE A SINGLE DECK WELD.

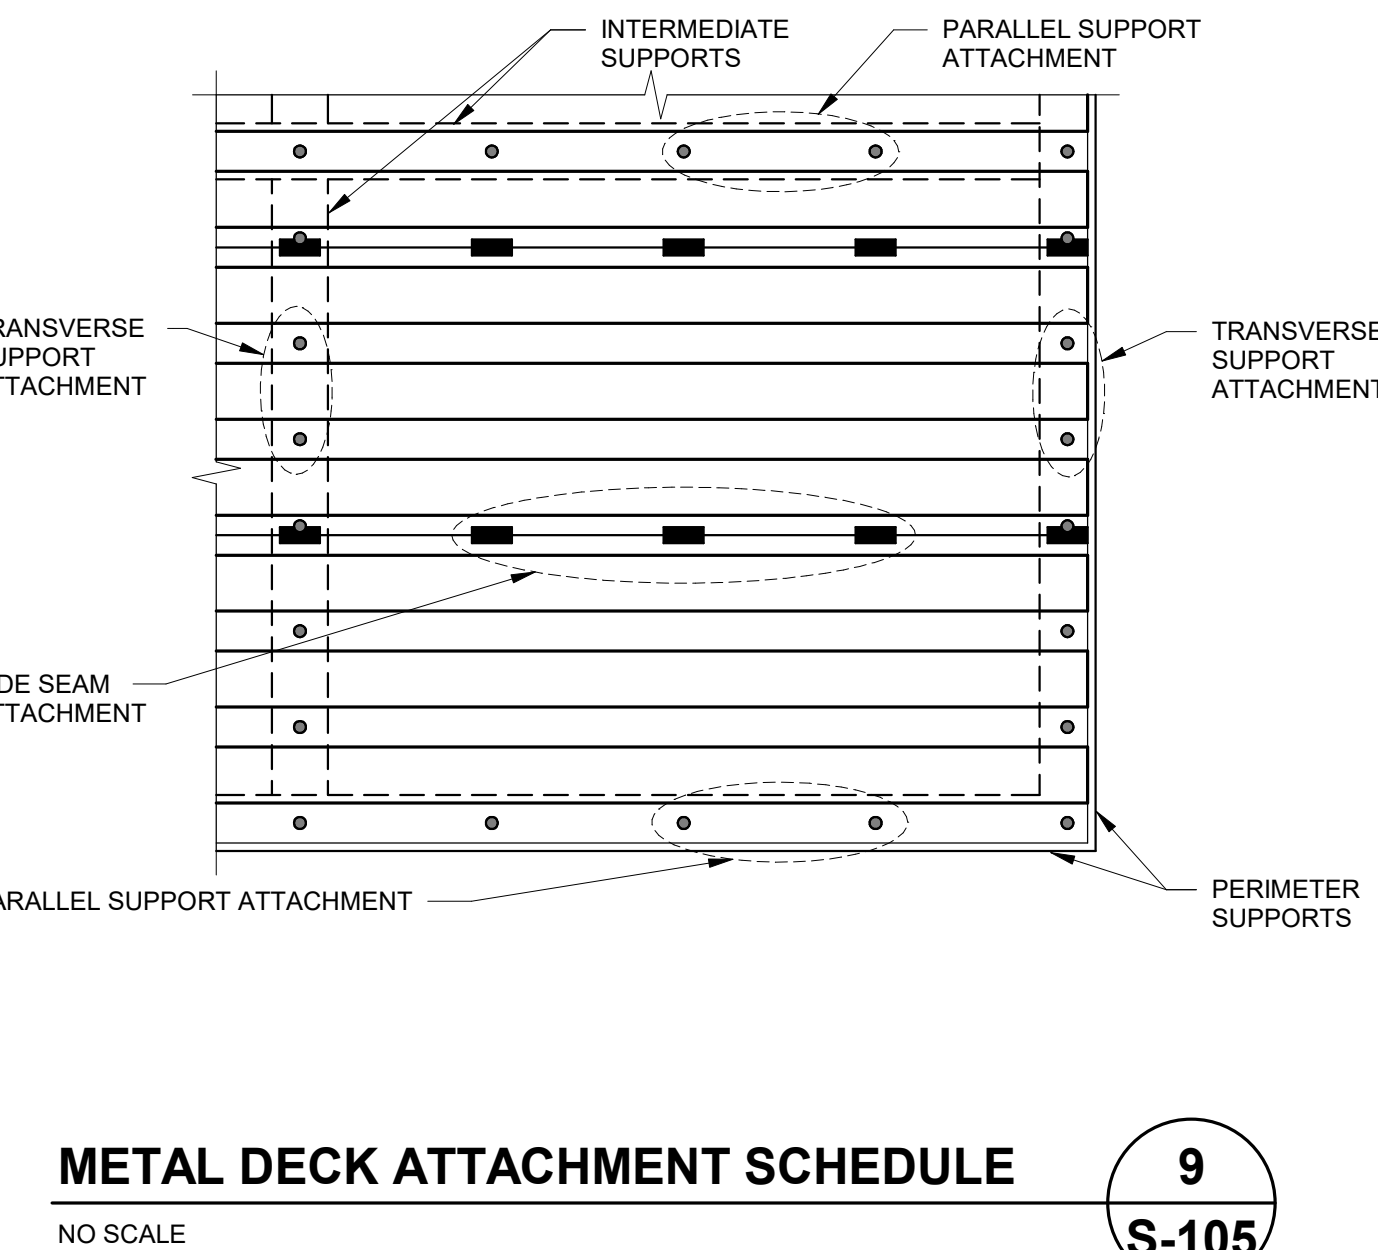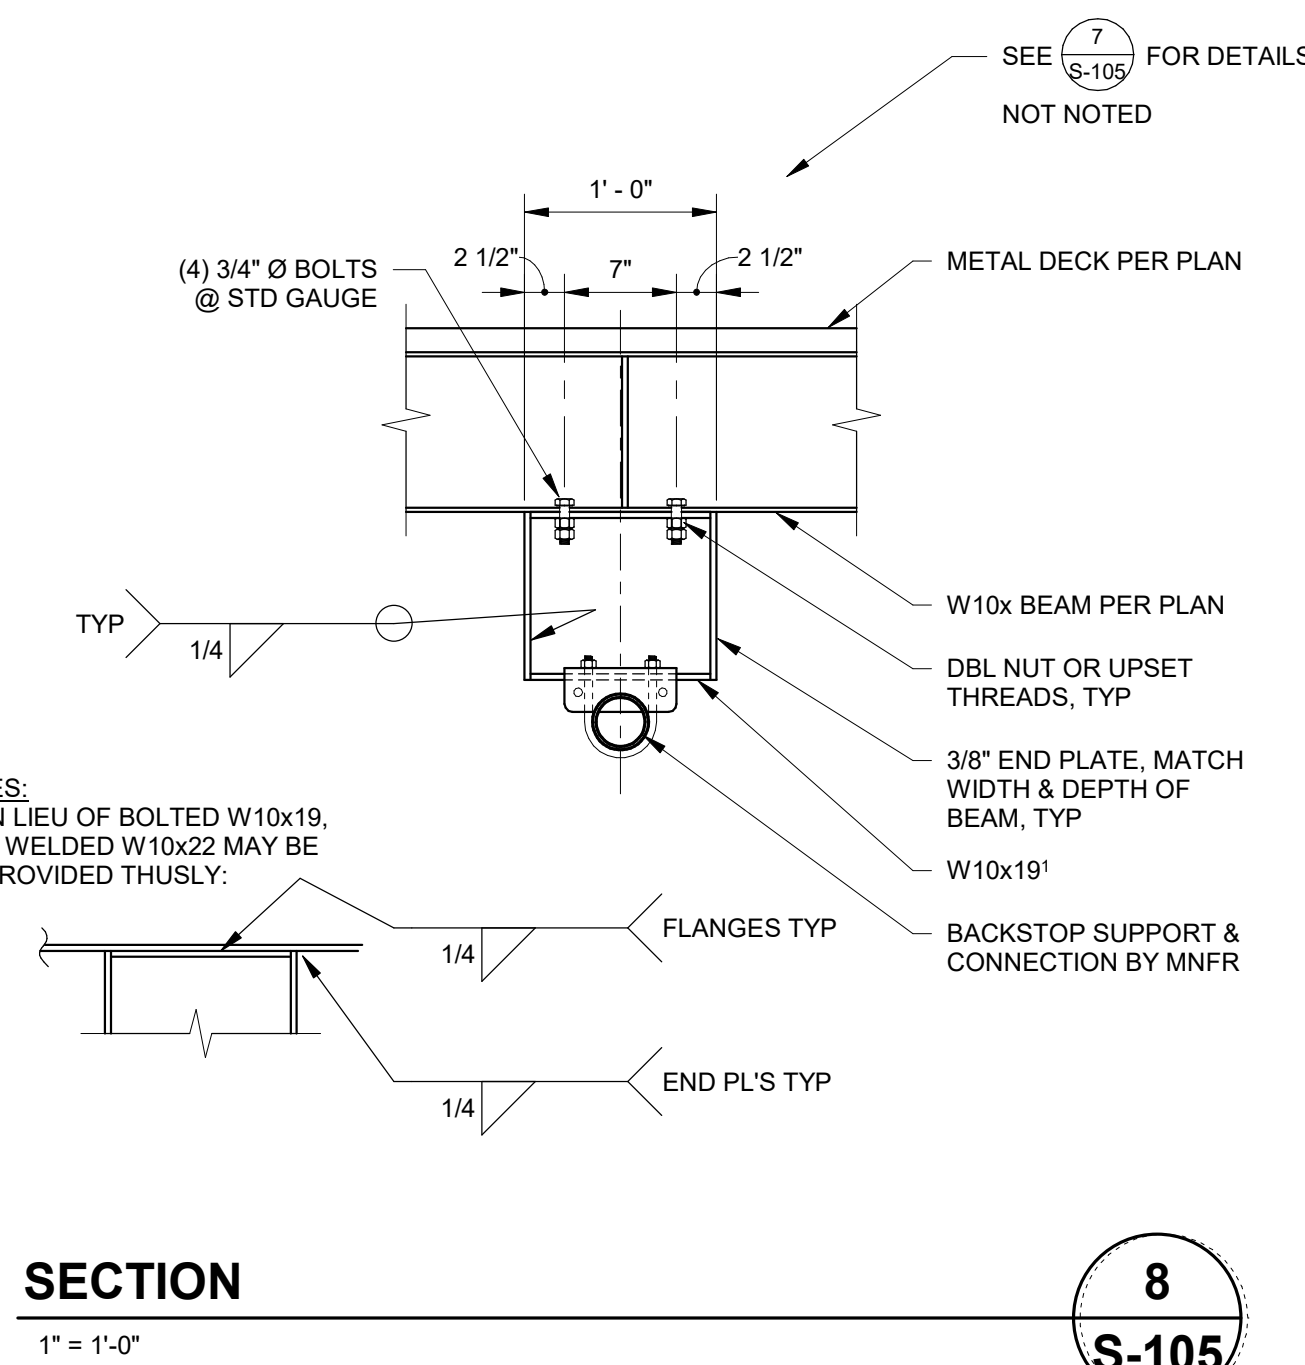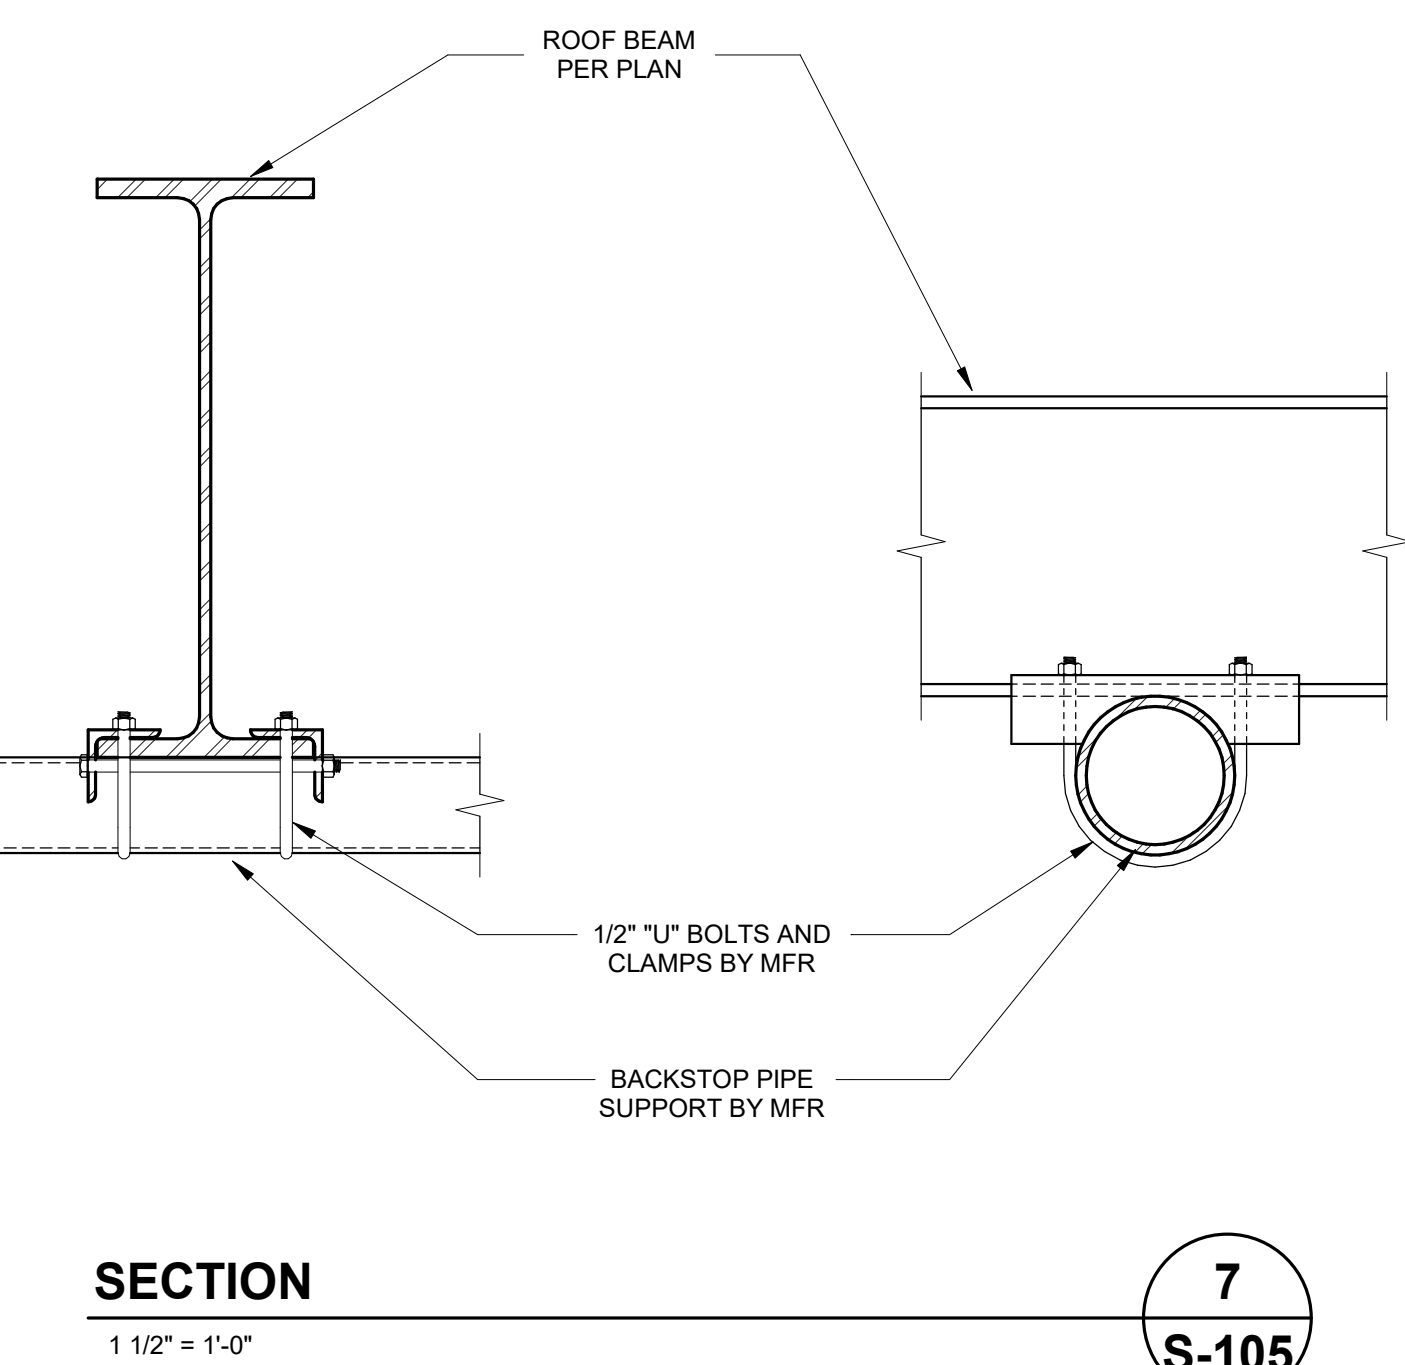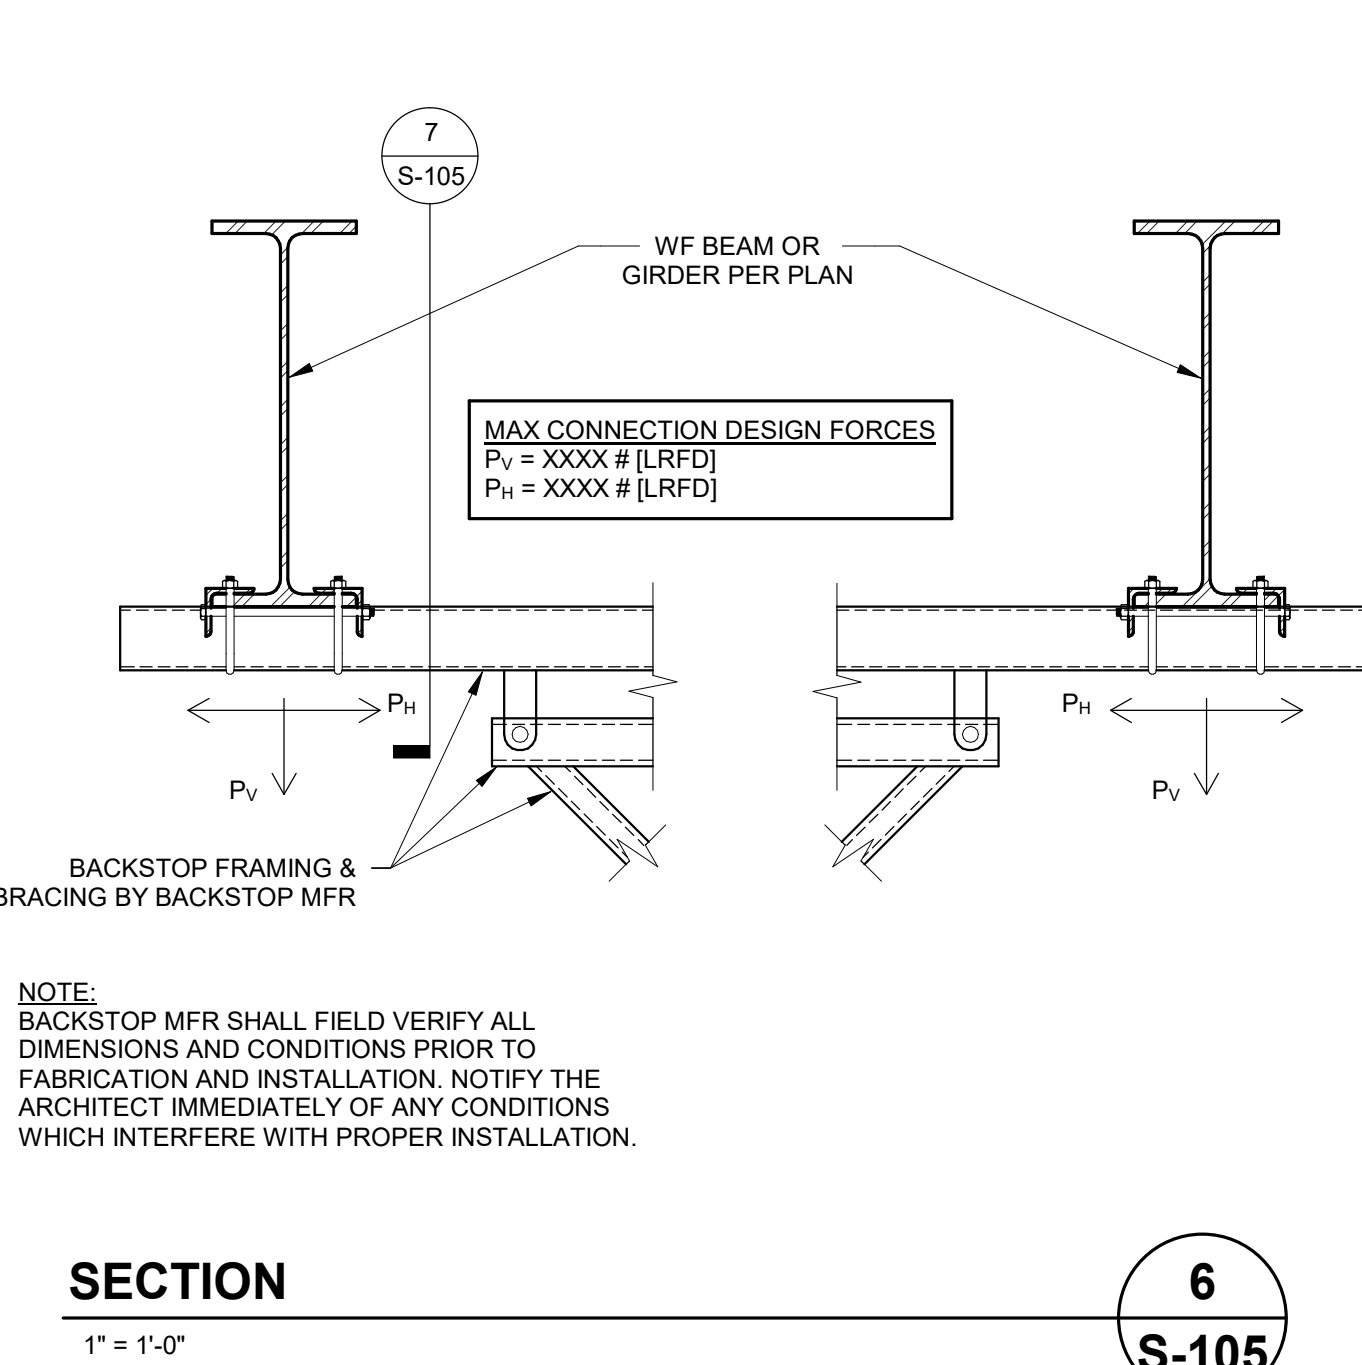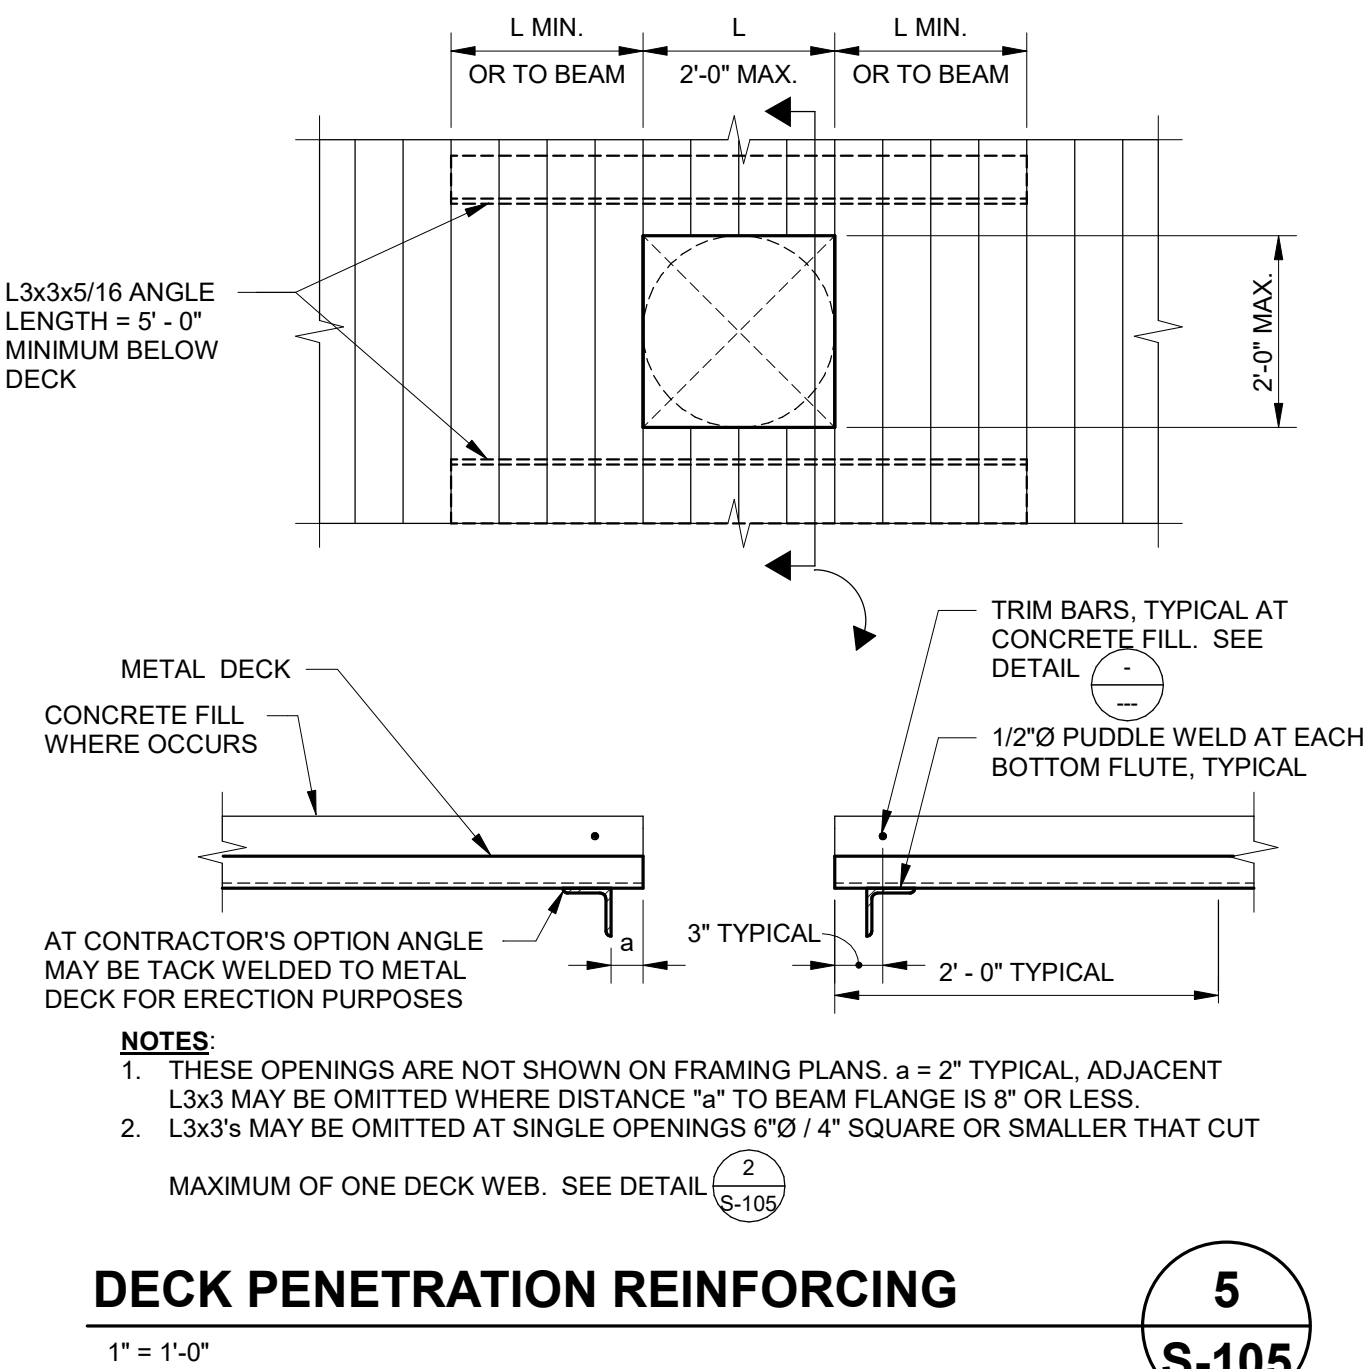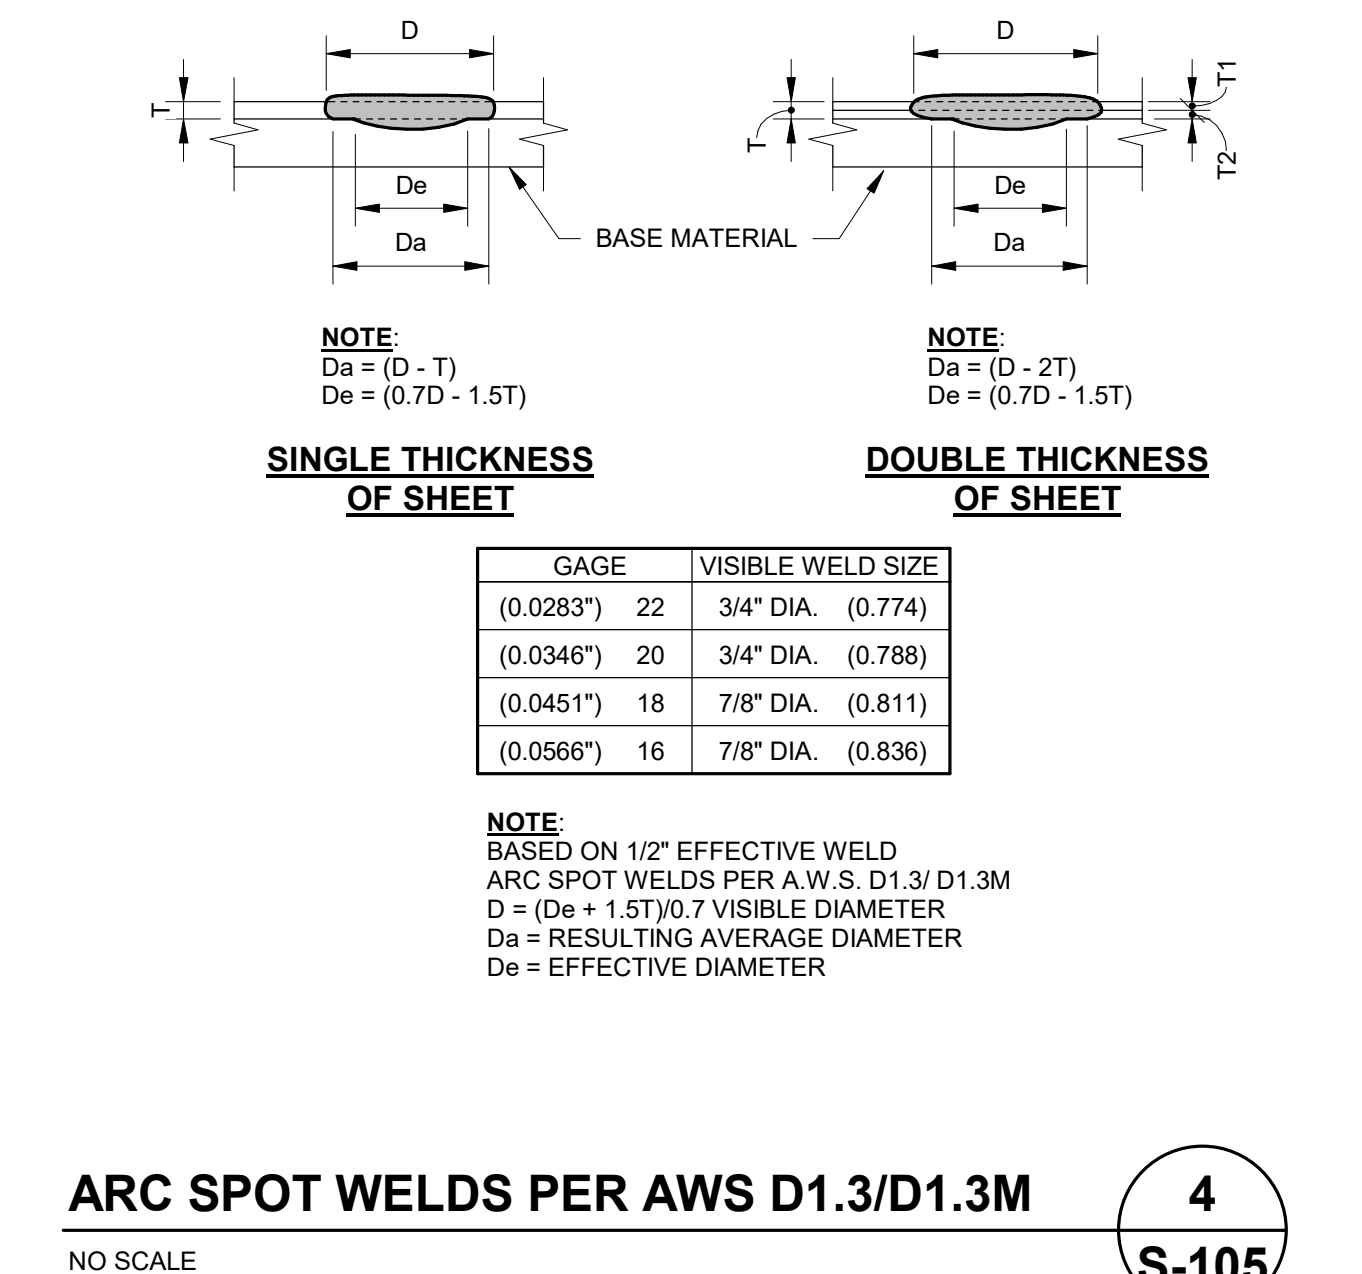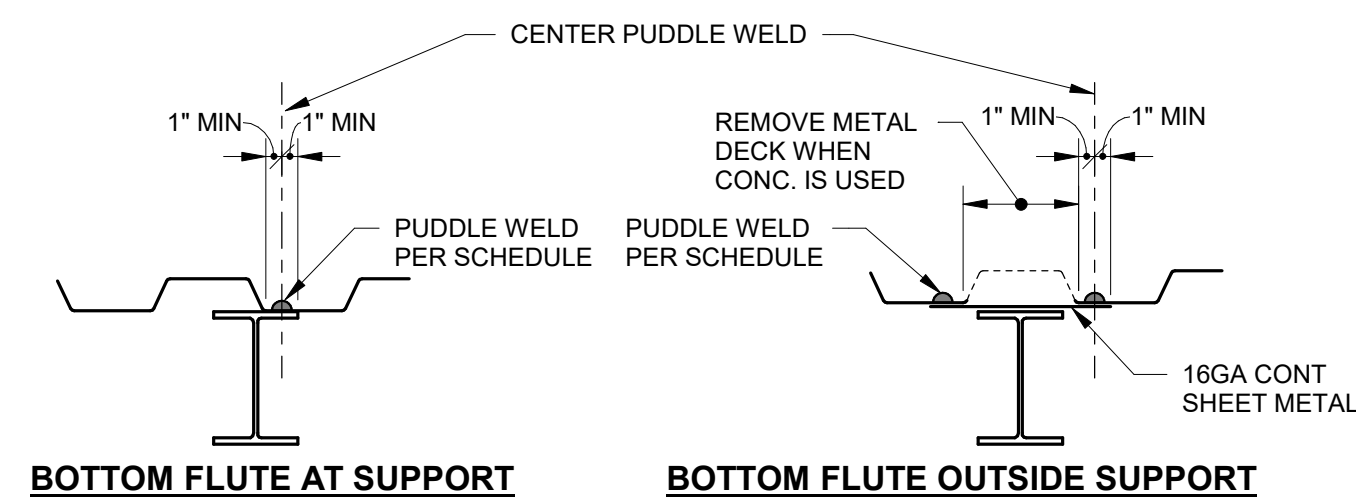

NO.	REVISION	DATE
	Plan Check Revision 1	5/17/24
	ADDENDUM 6	12/20/24
		
		
		

PROJECT MANAGER

DRAWN BY

CHECKED BY

DATE

09.10.24


PROJECT NUMBER

2883-01-RC22

SHEET


S-105

12/28/2024 8:57:52 AM
\\csag-1-fs01\lfrms\markw\Porterville_2022_Structural_danderson@csag.com.rvt

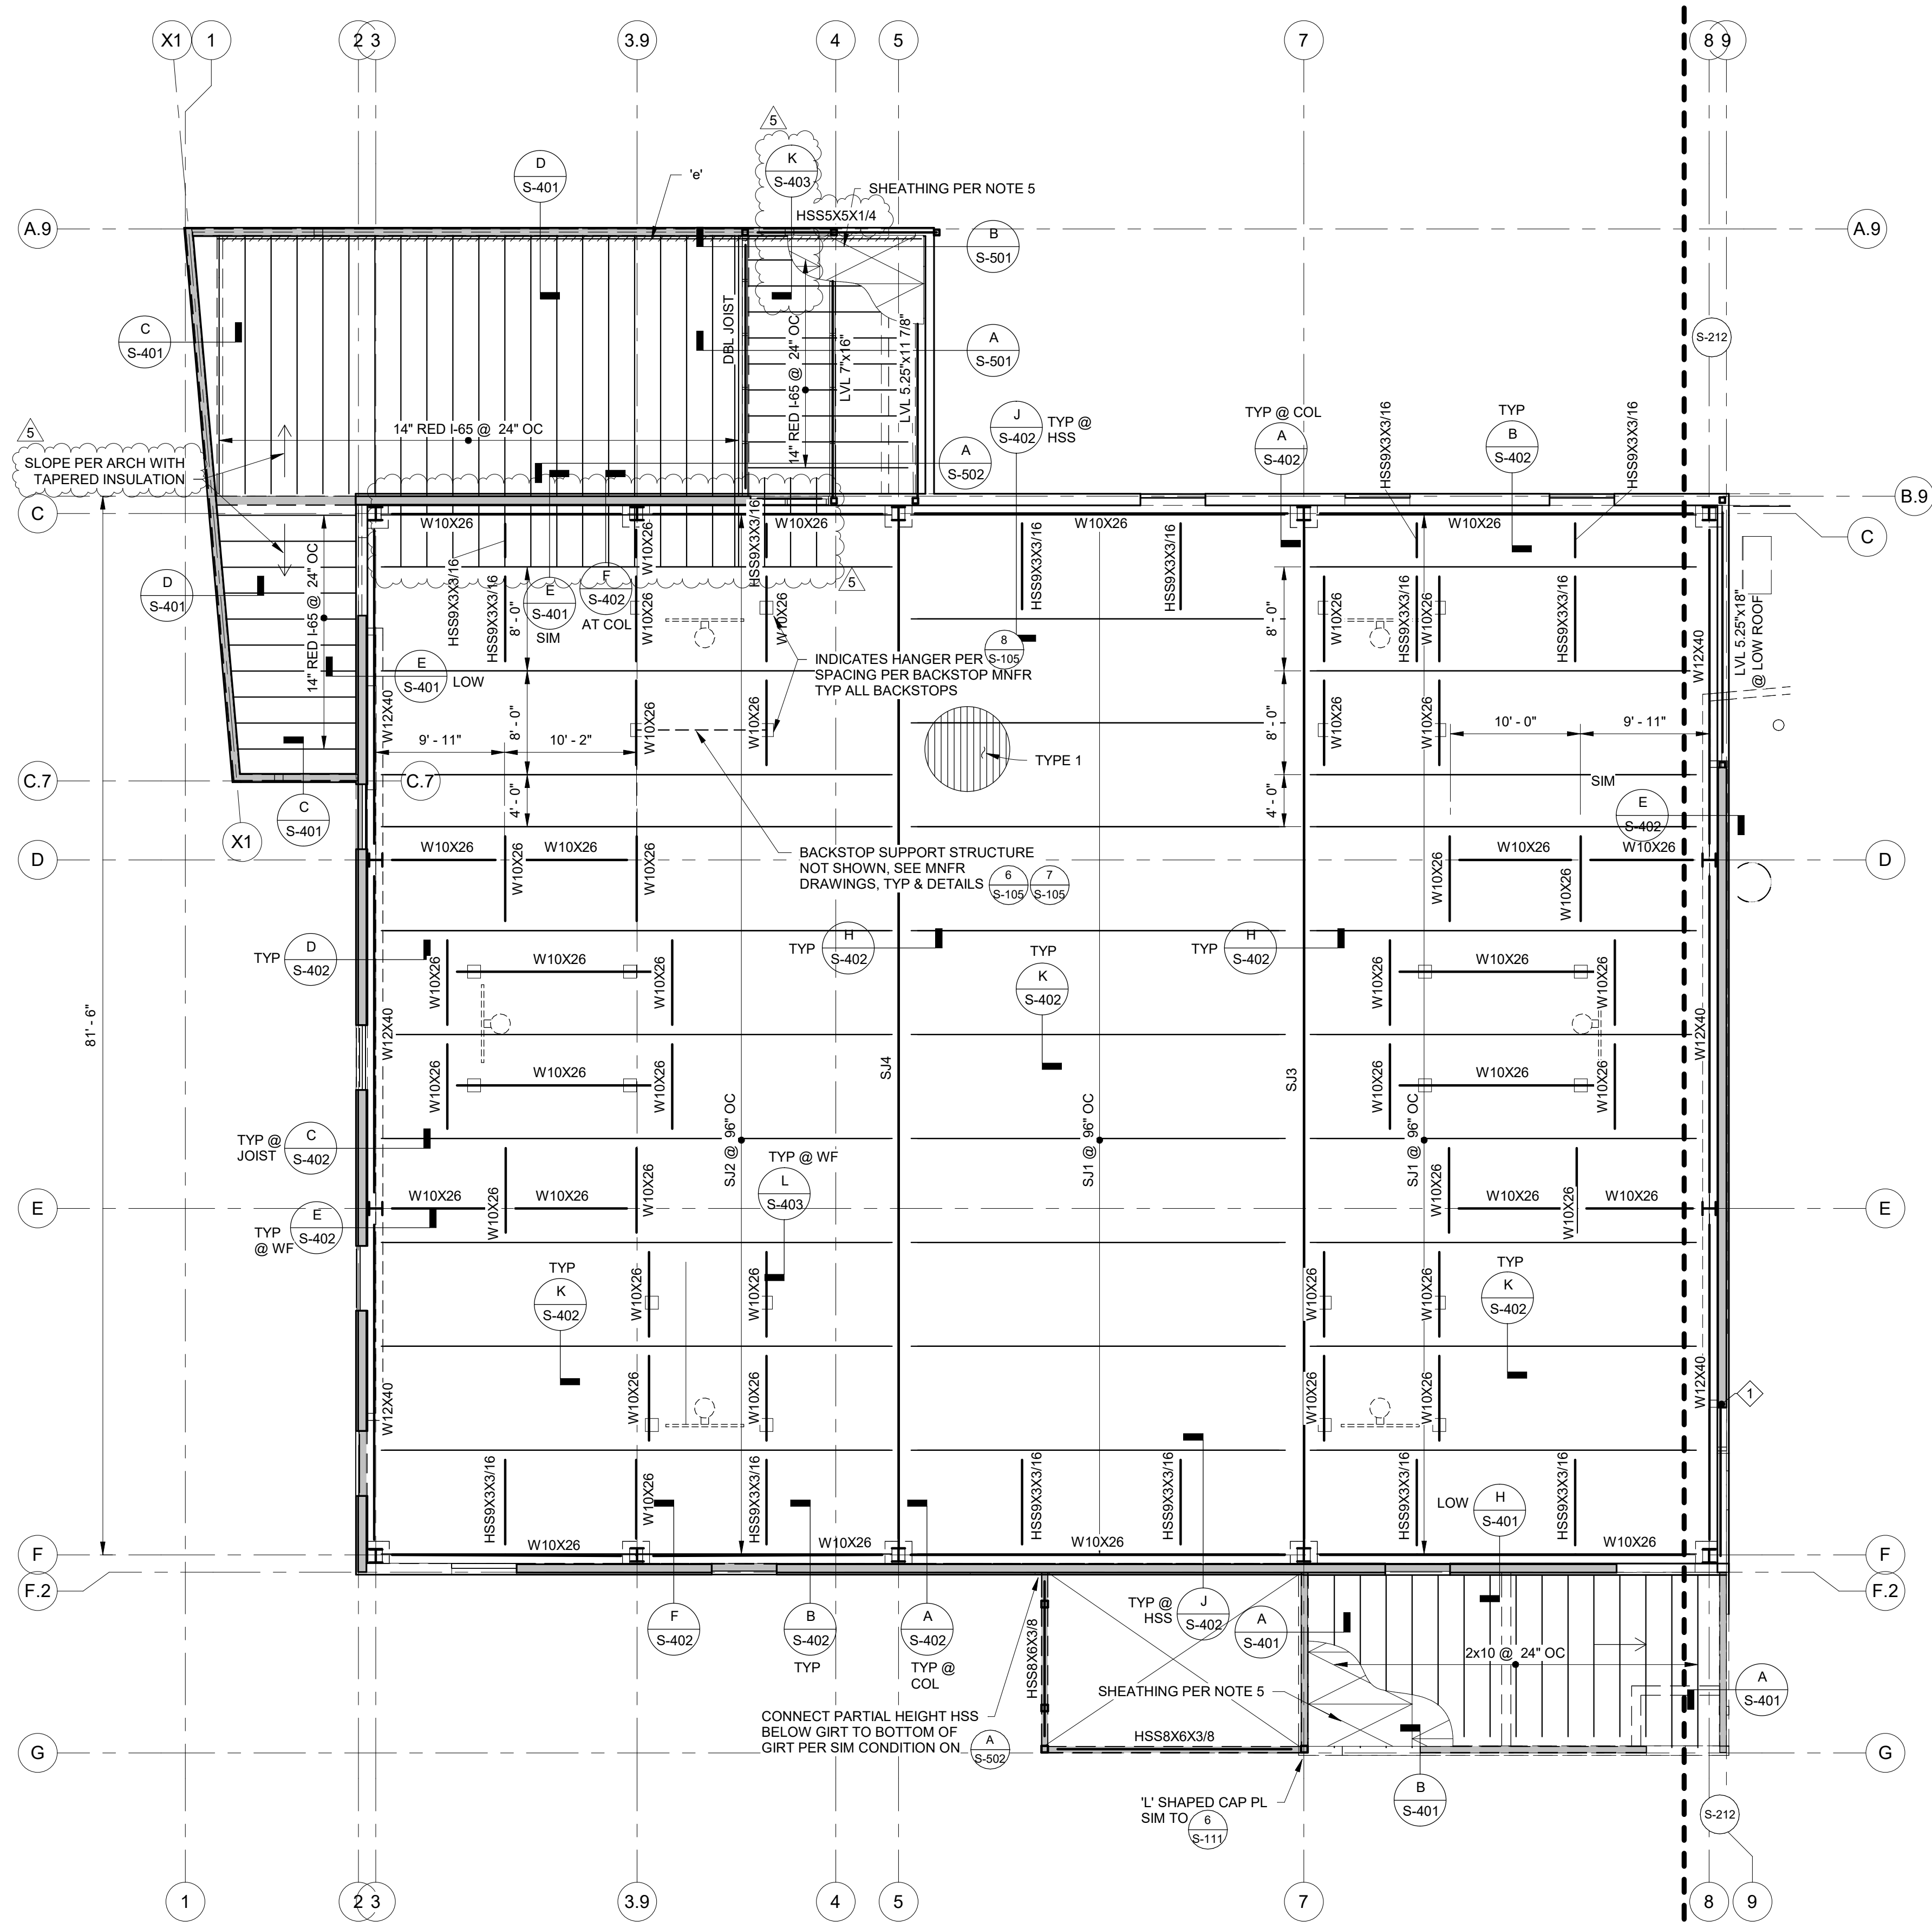

ROOF FRAMING PLAN - NORTH

1/8" = 1'-0"

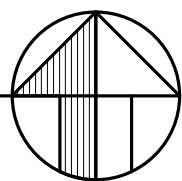

ROOF FRAMING NOTES:

- REFER TO GENERAL NOTES & SPECIFICATIONS ON SHEET S-001 & S-002.
- SEE SHEET S-101 - S-111 FOR TYPICAL FRAMING DETAILS.
- SEE ARCHITECTURAL DRAWINGS FOR ROOF ELEVATIONS.
- CONTRACTOR TO VERIFY ALL DIMENSIONS AND ELEVATIONS SHOWN WITH ARCHITECTURAL DRAWINGS AND INFORM BOTH ARCHITECT AND ENGINEER OF ANY CONFLICTING INFORMATION.
- ROOF SHEATHING SHALL CONSIST OF 1/2" CDX PLYWOOD W/ 10d @ 4" O.C. AT BOUNDARIES AND EDGES, 10d @ 12" O.C. FIELD NAILING. ALL PLYWOOD EDGES SHALL BE FULLY BLOCKED TYPICAL, U.N.O.
- ROOF DIAPHRAGM FASTENING SHALL BE APPROVED BY BUILDING DEPARTMENT PRIOR TO COVERING.
- INSTALL EXTRA 2x6 AT RIDGE LOCATIONS WHERE NECESSARY.
- SEE ARCHITECTURAL DRAWINGS FOR SIZE & LOCATION OF ROOF OPENINGS.
- VERIFY SIZE AND LOCATION OF ALL OPENINGS WITH ARCHITECTURAL DRAWINGS AND MECHANICAL DRAWINGS. NOTIFY STRUCTURAL ENGINEER IMMEDIATELY OF ANY DISCREPANCIES, TYPICAL U.N.O.
- FIRE SPRINKLER PIPING SHALL NOT BE SUPPORTED BY MEMBERS 6" OR LESS IN DEPTH. DESIGN OF THE ATTACHMENT TO THE SUPPORTING MEMBERS SHALL BE THE RESPONSIBILITY OF THE SPRINKLER INSTALLER.
- THE SIZE, LOCATIONS AND ORIENTATIONS OF ALL MECHANICAL UNITS, CURBS, SLEEPERS AND OPENINGS SHALL BE VERIFIED WITH THE UNIT SUPPLIERS. ANY CONFLICTS SHALL BE BROUGHT TO THE ATTENTION OF THE ENGINEER IMMEDIATELY.
- ROOF JOISTS SHALL BE BRIDGED EVERY 10 FEET BY SOLID 2X BLOCKING OR BY 1x3 WOOD CROSS BRIDGING OR NAILED STEEL CROSS BRIDGING OF EQUAL STRENGTH.
- ALL RAFTER TO BEAM/GIRDER CONNECTIONS SHALL BE W/ SIMPSON HU HANGERS, U.N.O.
- CONTRACTOR TO USE SKEWED HANGERS IN LIEU OF HANGER SHOWN AS REQUIRED.
- ALL 4x BEAM TO POST CONNECTIONS SHALL BE WITH EPC OR PC POST CAPS, U.N.O.
- ALL 6x BEAM OR GL BEAM TO POST CONNECTIONS SHALL BE WITH ECC OR CC COLUMN CAPS, U.N.O. SEE (S-107)
- TYPICAL HSS COLUMN IN STUD WALL SHALL EXTEND UP TO BOTTOM OF WALL DBL TOP PLATE & SHALL BE ALIGNED WITH AN ADDITIONAL JOIST OR 2 BAYS OF BLKD. SEE (S-111)
- SEE ARCHITECTURAL DRAWINGS FOR SIZE & LOCATION OF DECK PENETRATIONS.
- NO MECHANICAL EQUIPMENT, DUCTWORK, PIPING, ETC SHALL BE HUNG FROM STEEL DECKING UNLESS APPROVED BY THE STRUCTURAL ENGINEER.
- SEE ARCHITECTURAL DRAWINGS FOR EDGE OF DECK LOCATIONS.

- 1 A101 DETAIL/SECTION VIEW WITH VIEW DIRECTION ARROW, DETAIL NUMBER AND SHEET REFERENCE.
- 1 GRID
- INDICATES WALL BELOW
- INDICATES SHEARWALL BELOW
- SIMPSON STRAP. SEE PLAN.
- INDICATES FRAMED DECK OPENING. MATCH JOIST SIZE FRAMING ALL AROUND WITH SIMPSON HU HANGERS EA END
- INDICATES DIRECTION OF ROOF SLOPE. S.A.D.
- INDICATES NEW MECHANICAL UNITS ABOVE ROOF. S.M.D. PROVIDE 3x6 BLKG AROUND PERIMETER OF UNIT AND OPENINGS FOR CURB ATTACHMENT WITH SIMPSON U HANGER EA END. SEE (S-107)
- 600# INDICATES MAXIMUM UNIT WEIGHT.
- INDICATES METAL DECK SEE SCHEDULE (S-105)
- 1 INDICATES HOLDOWN TAG. SEE (S-105)
- c' INDICATES CANTILEVER LVL BEAM OUT OVER COLUMN AND USE POST CAP PER (S-107)
- d' INDICATES SIMPSON CMSTC16x60' PER (S-107)
- e' INDICATES SIMPSON CS14x50' PER (S-107)



CONSULTANT

CORNERSTONE

structural engineering group

986 W. Alvarado, Suite 201
Fresno, California 93711
559.320.3200
fax 559.320.3201

AGENCY

PORTERVILLE COMMUNITY CENTER

N 4TH ST, PORTERVILLE, CA 93257

ROOF FRAMING PLAN - NORTH

NO.	REVISION	DATE
5	ADDENDUM 6 / 7	12/20/24
△		
△		
△		
△		
△		

PROJECT MANAGER

DRAWN BY

CHECKED BY

DATE

09.10.24

PROJECT NUMBER


2883-01-RC22

SHEET

S-213


CONSTRUCTION DOCUMENTS

12/28/2024 8:57:53 AM
\\csag-fs01\lfrms\markw\Porterville_2022_Structural_danderson@csag.com.rvt

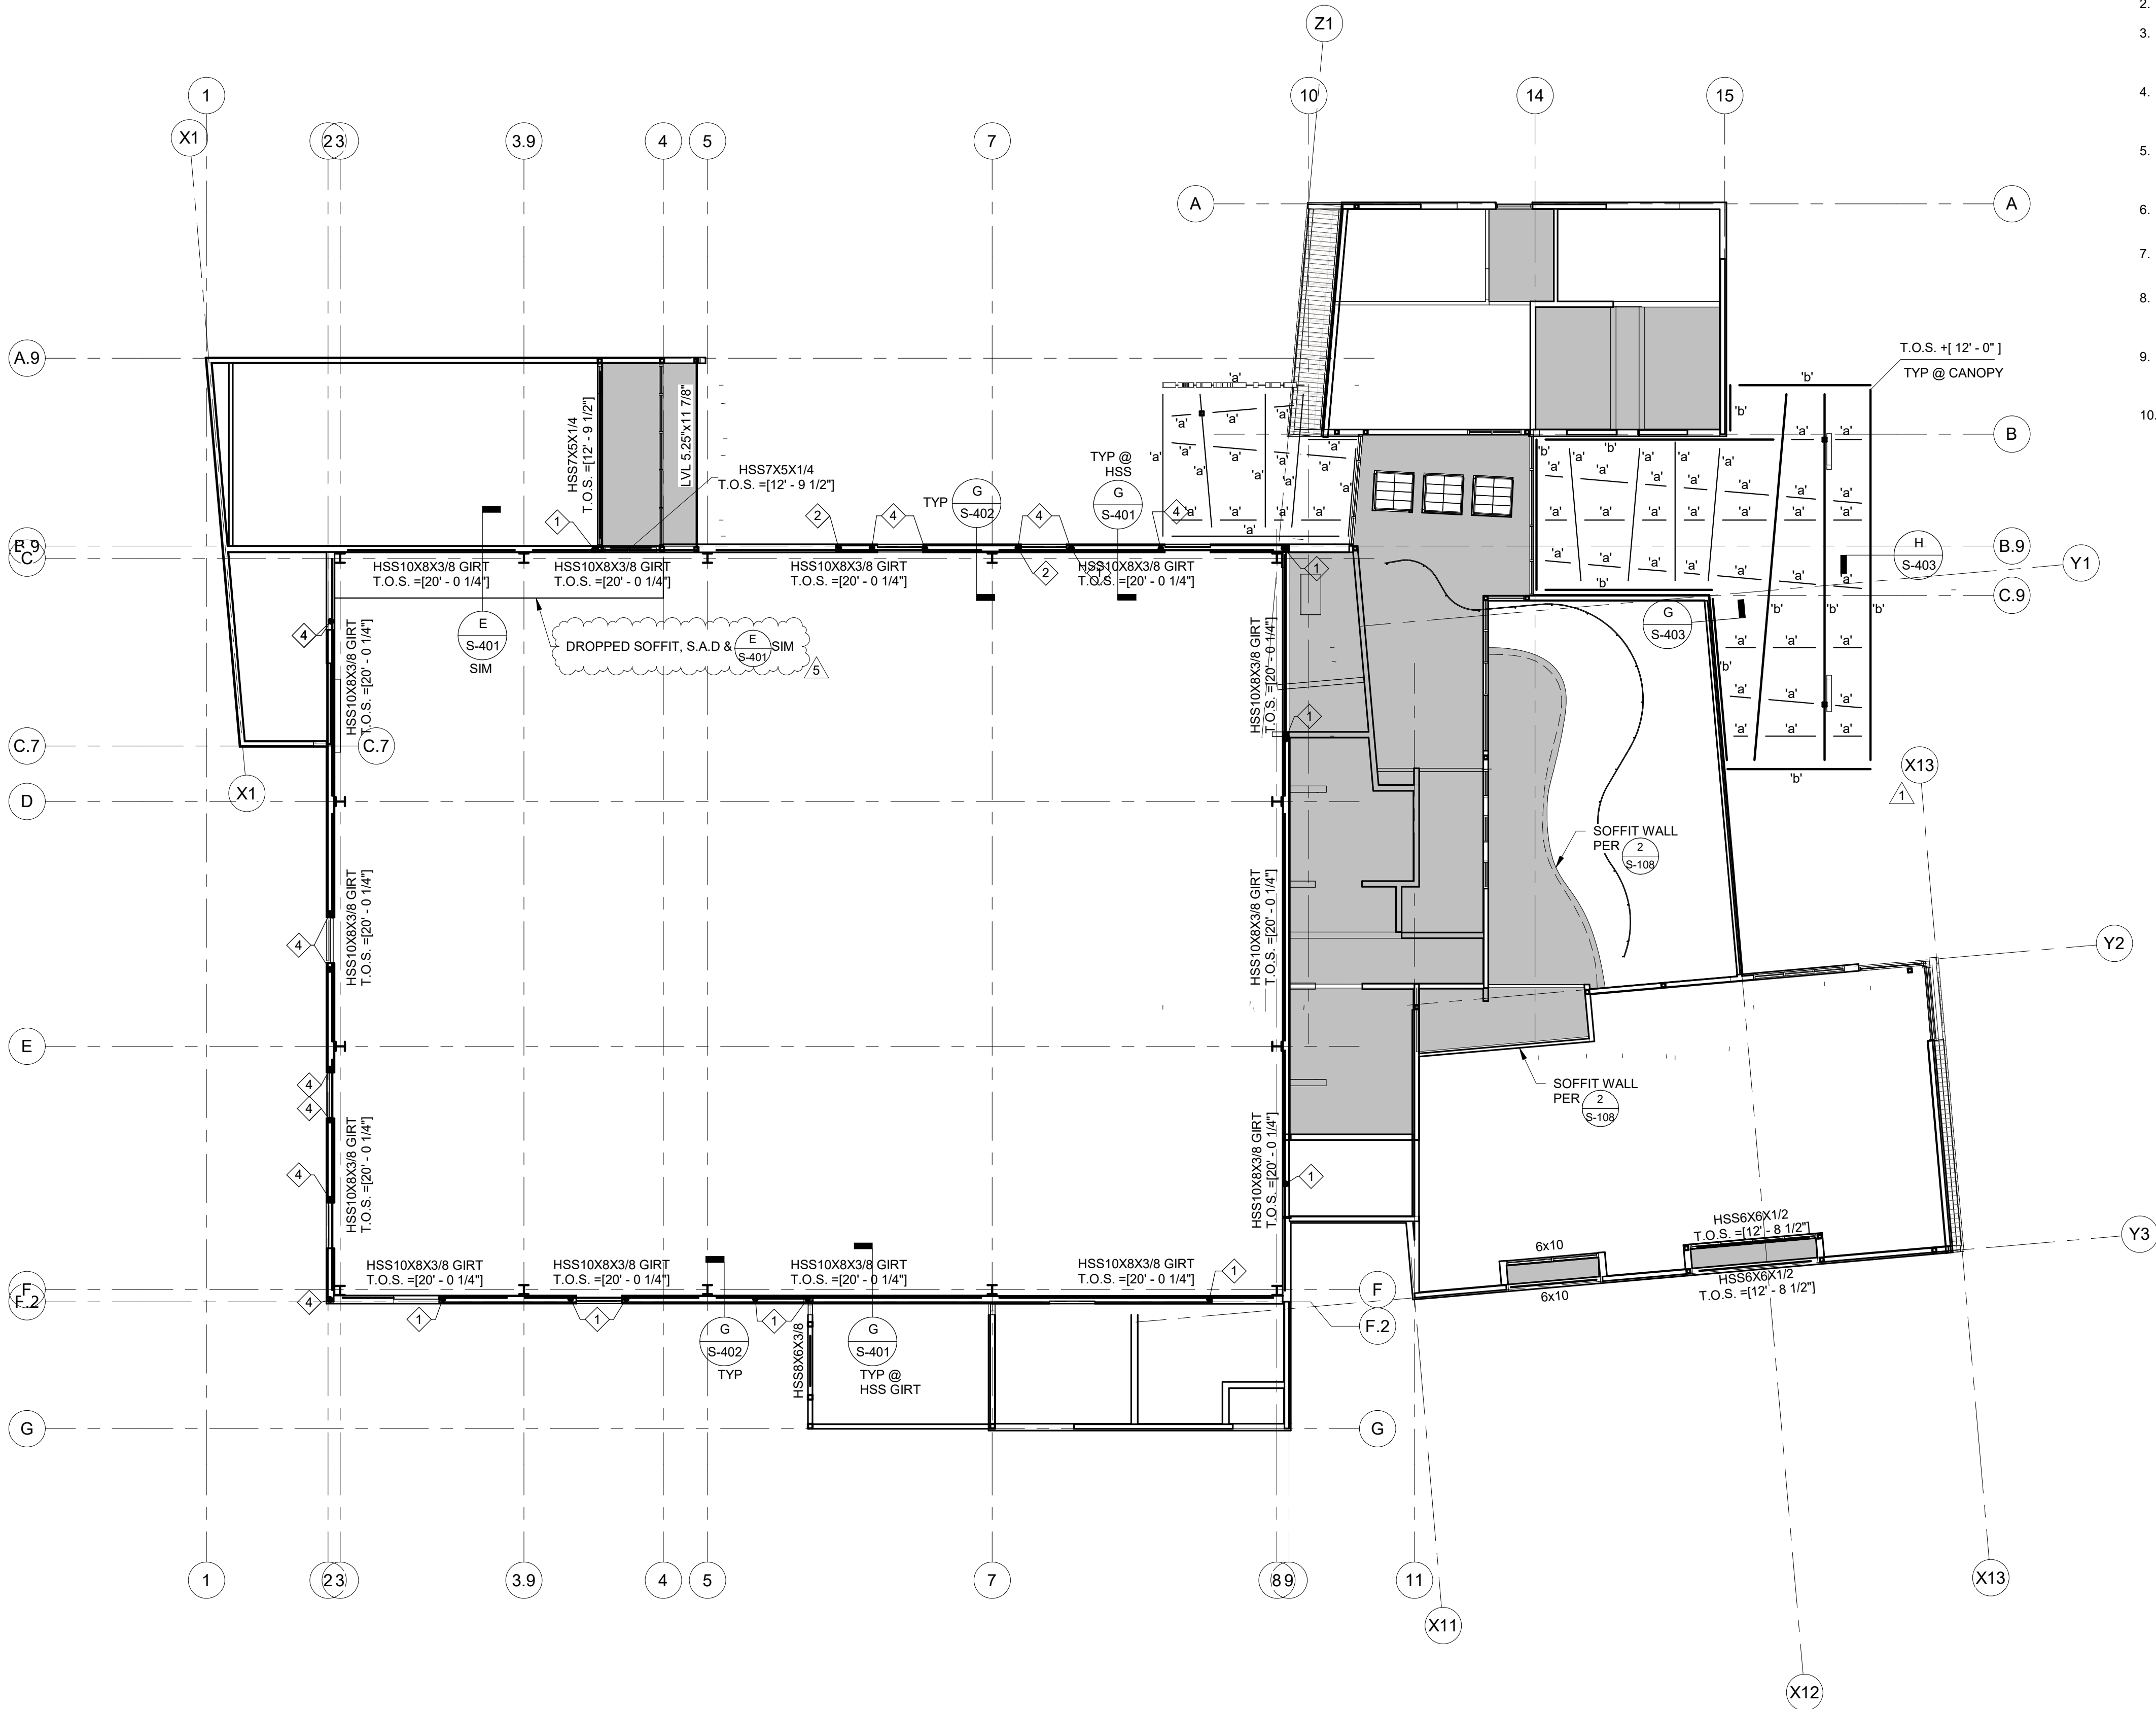

CEILING & LOW FRAMING PLAN

3/32" = 1'-0"

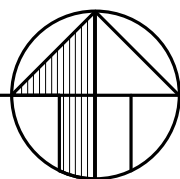

CEILING FRAMING NOTES:

1. REFER TO GENERAL NOTES & SPECIFICATIONS ON SHEET S0.01 & S0.02.
2. SEE SHEET S1.01-S1.11 FOR TYPICAL DETAILS.
3. AT CEILING FRAMING, PROVIDE GYPSUM BOARD (THICKNESS PER ARCH, 1/2" MIN, 1 1/4" MAX), W/ #6 SELF DRILLING DRYWALL SCREWS @ 7" OC EDGE FASTENING & 12" OC FIELD FASTENING IN COMPLIANCE WITH CBC SECTION 2508.6
4. AT NON SHEARWALLS SUPPORTING CEILING FRAMING, PROVIDE GYPSUM BOARD FULL HEIGHT (THICKNESS PER ARCH, 1/2" MIN), W/ #6 SELF DRILLING DRYWALL SCREWS @ 7" OC EDGE FASTENING & 12" OC FIELD FASTENING
5. CONTRACTOR TO VERIFY ALL DIMENSIONS AND ELEVATIONS SHOWN WITH ARCHITECTURAL DRAWINGS AND INFORM BOTH ARCHITECT AND ENGINEER OF ANY CONFLICTING INFORMATION.
6. NO PENETRATIONS FOR PIPING, CONDUIT, OR DUCTWORK SHALL BE MADE THRU THE JOISTS UNLESS APPROVED BY THE ENGINEER.
7. ALL DIMENSIONS ARE TO FACE OF WALL, UNLESS NOTED OTHERWISE.
8. INDICATES CEILING JOISTS PER $\frac{1}{S-108}$
9. 'a' INDICATES HSS8x3x1/4
10. 'b' INDICATES HSS8x3x1/2



rrmdesign.com | (805) 543-1794
3765 SOUTH HIGUERA STREET, SUITE 102
SAN LUIS OBISPO, CA 93401
THE INCLUDED DRAWINGS, SPECIFICATIONS, SERIAL ORDERS AND ARRANGEMENTS REPRESENTED THEREBY ARE AND SHALL REMAIN THE PROPERTY OF RRM DESIGN GROUP AND NO PART THEREOF SHALL BE REPRODUCED, COPIED, EITHER IN WHOLE OR IN PART, WITHOUT THE WRITTEN CONSENT OF RRM DESIGN GROUP. VISUAL CONTACT WITH THESE DRAWINGS OR SPECIFICATIONS SHALL CONSTITUTE CONCLUSIVE EVIDENCE OF ACCEPTANCE OF THEIR RESPECTIVE SUBMITTAL OF THESE DOCUMENTS FOR PUBLIC AGENCY REVIEW. RRM DESIGN GROUP COPYRIGHT 2023
RRM IS A CALIFORNIA CORPORATION



CONSULTANT

CORNERSTONE

structural
engineering
group

986 W. Alvarado, Suite 201
Fresno, California 93711
559.320.3200
fax 559.320.3201

AGENCY

**PORTERVILLE COMMUNITY
CENTER**

N 4TH ST, PORTERVILLE, CA 93257

**CEILING & TRELLIS FRAMING
PLAN**

NO.	REVISION	DATE
1	Plan Check Revision 1	5/17/24
5	ADDENDUM 6	12/20/24

PROJECT MANAGER

DRAWN BY

CHECKED BY

DATE

09.10.24

PROJECT NUMBER













2883-01-RC22

SHEET

S-221

CONSTRUCTION DOCUMENTS

12/28/2024 8:57:54 AM
\\csag-fs01\lfrms\markw\Porterville_2022_Structural_danderson@cag.com.rvt

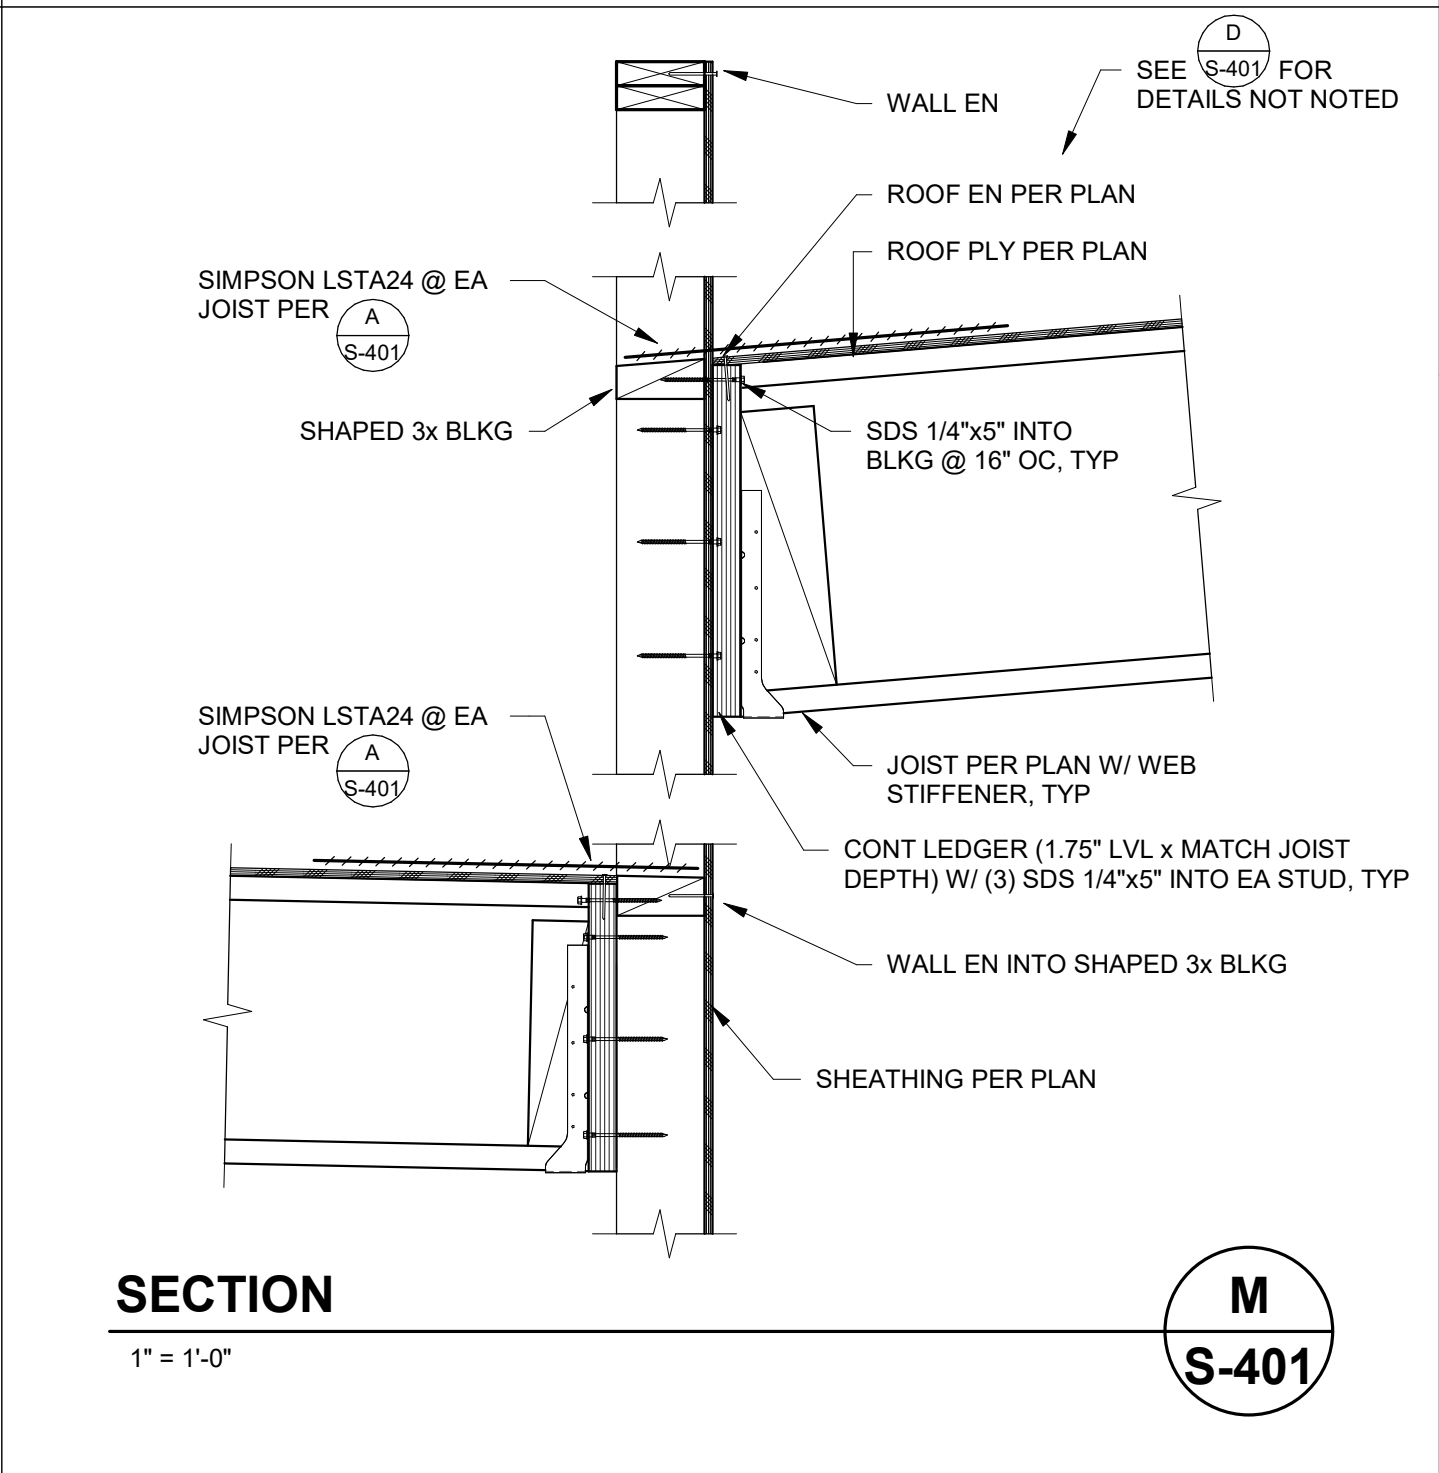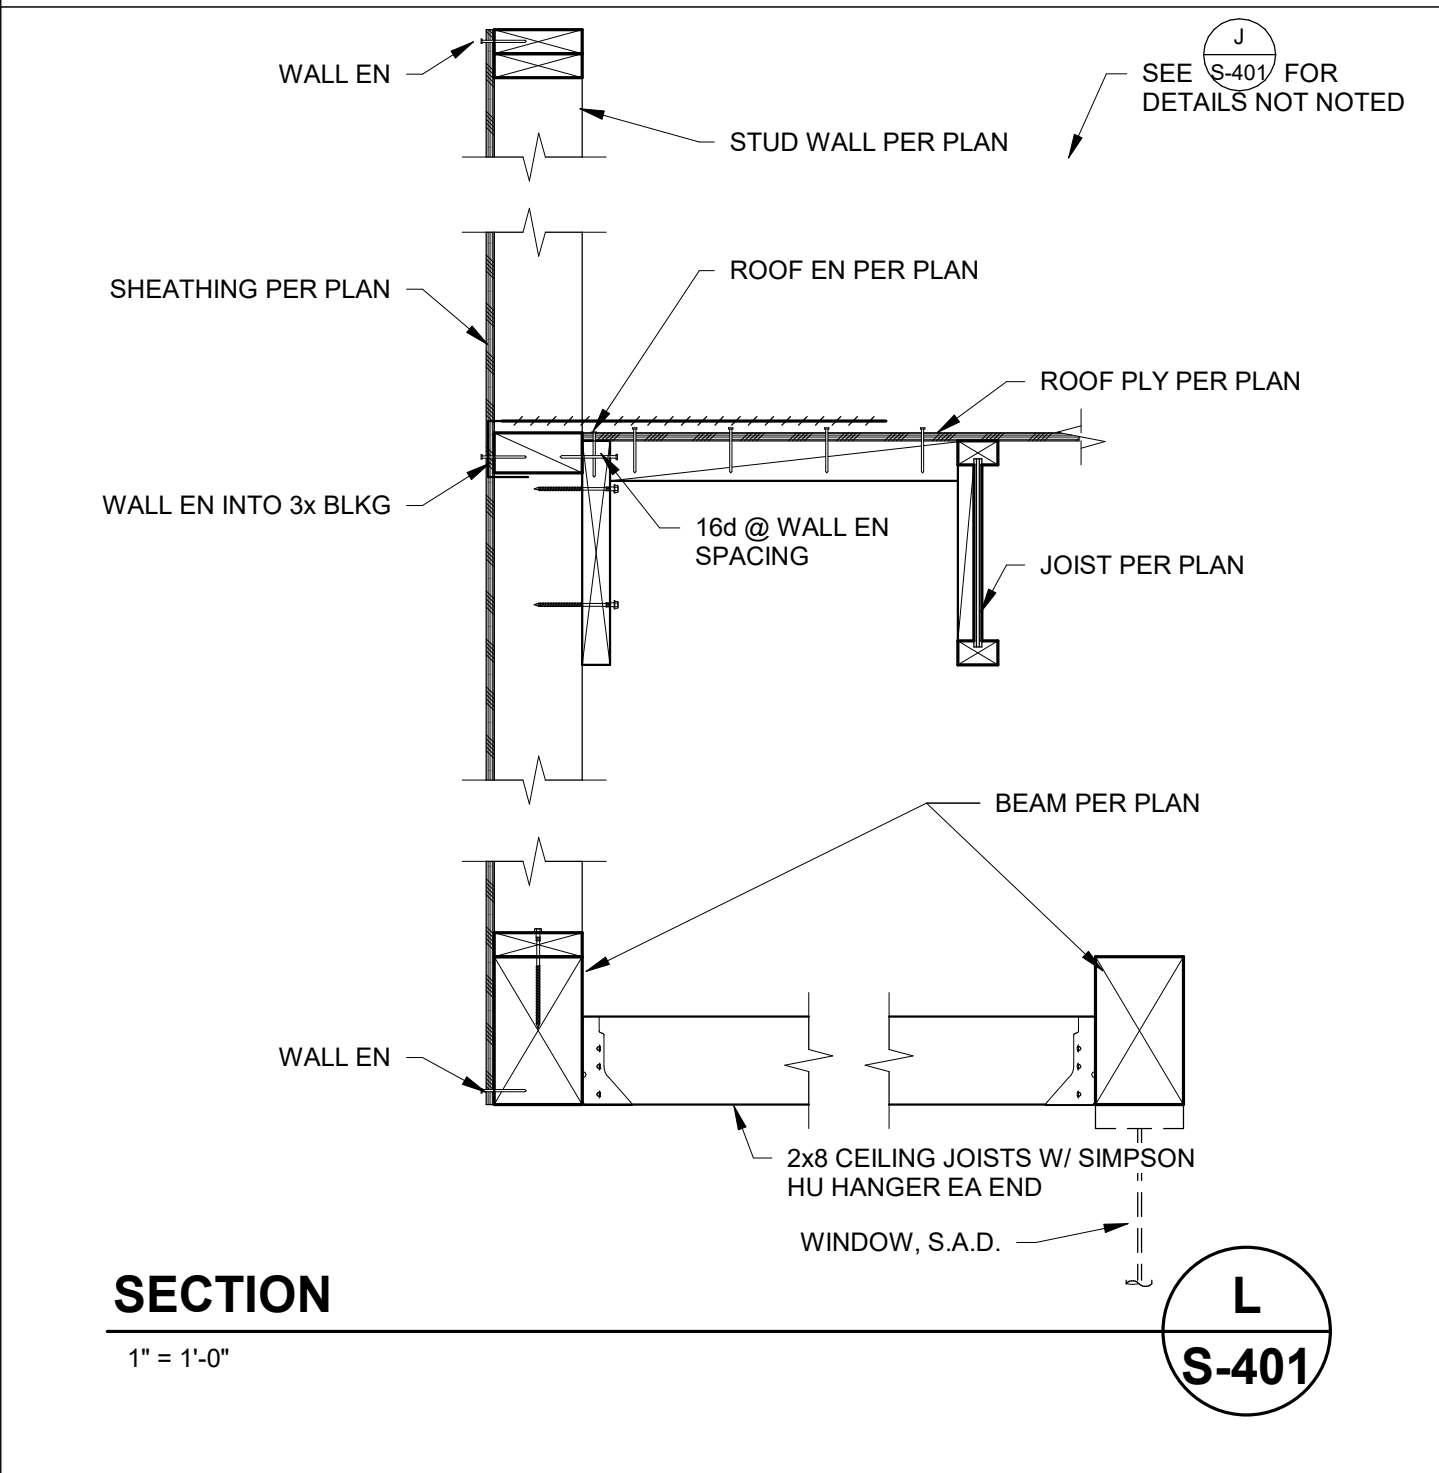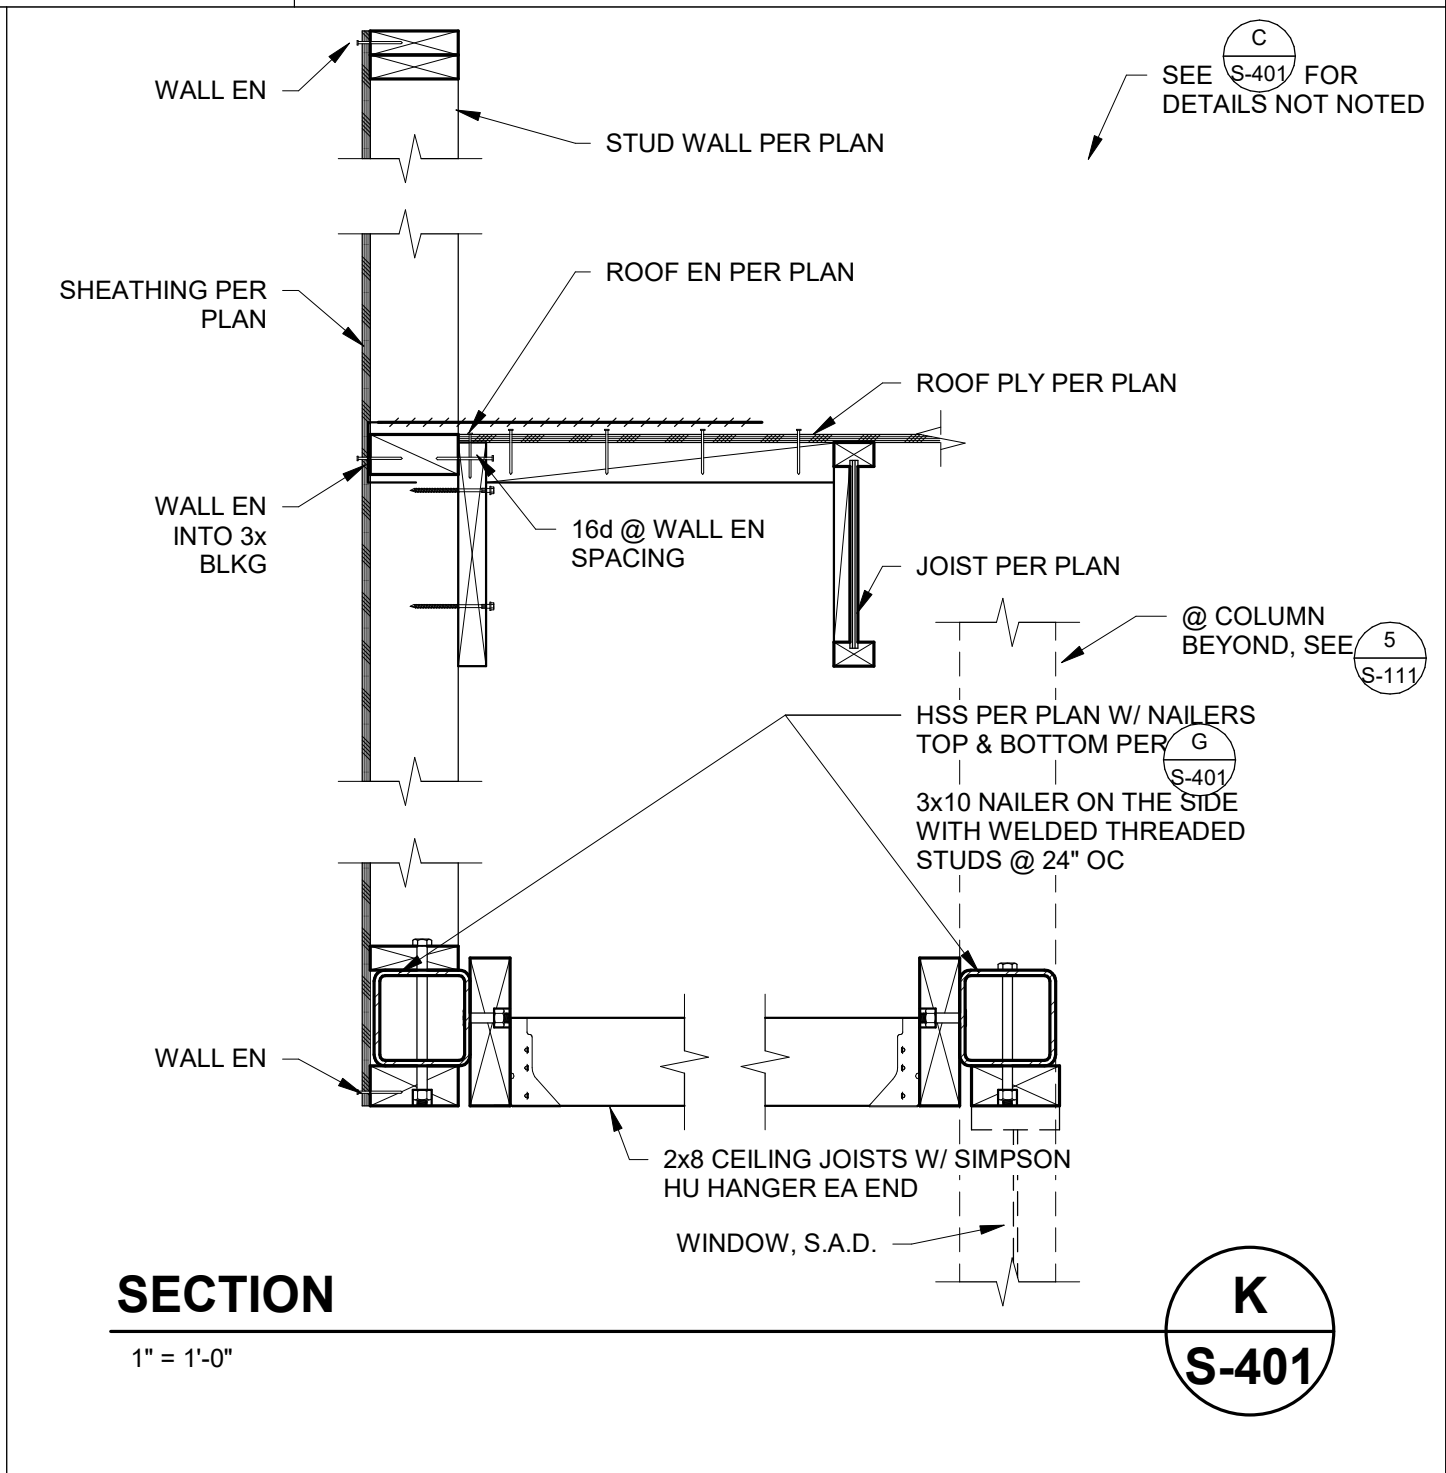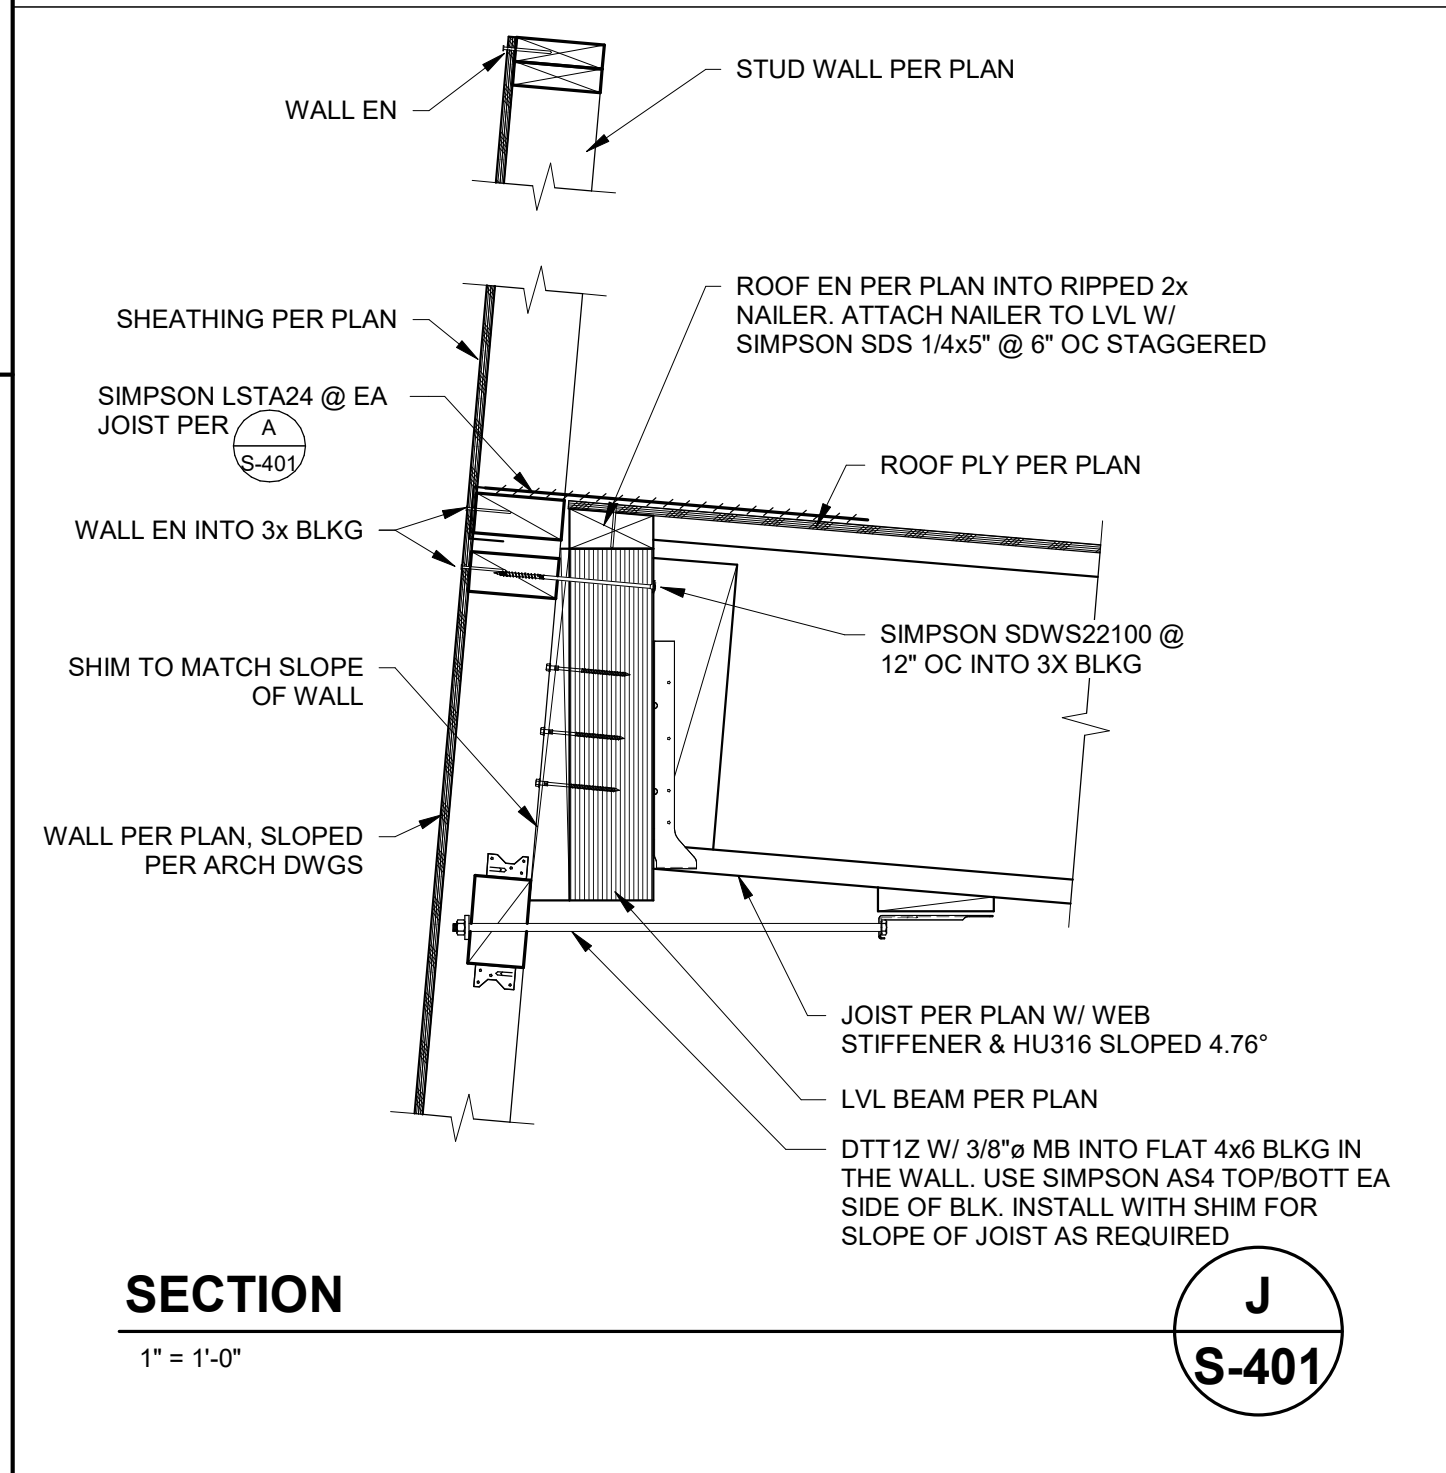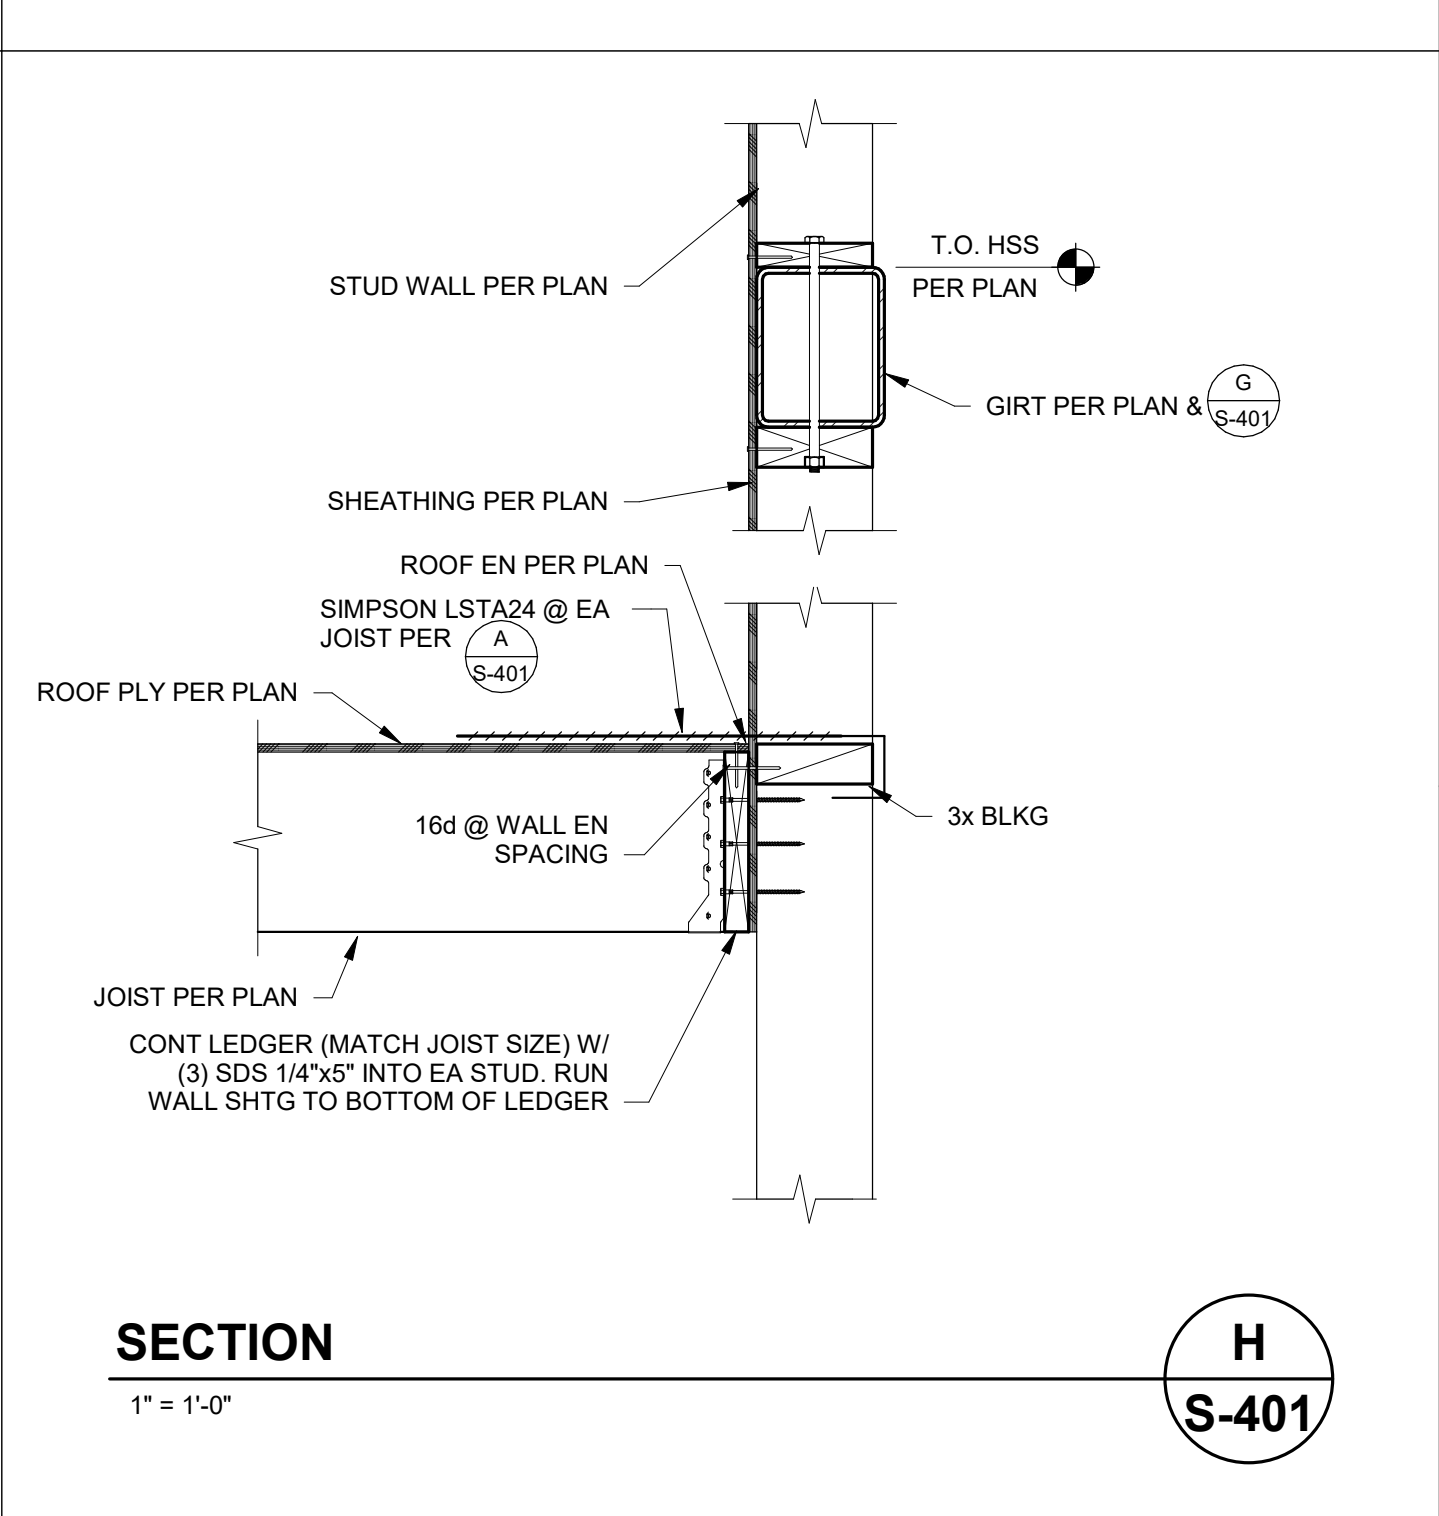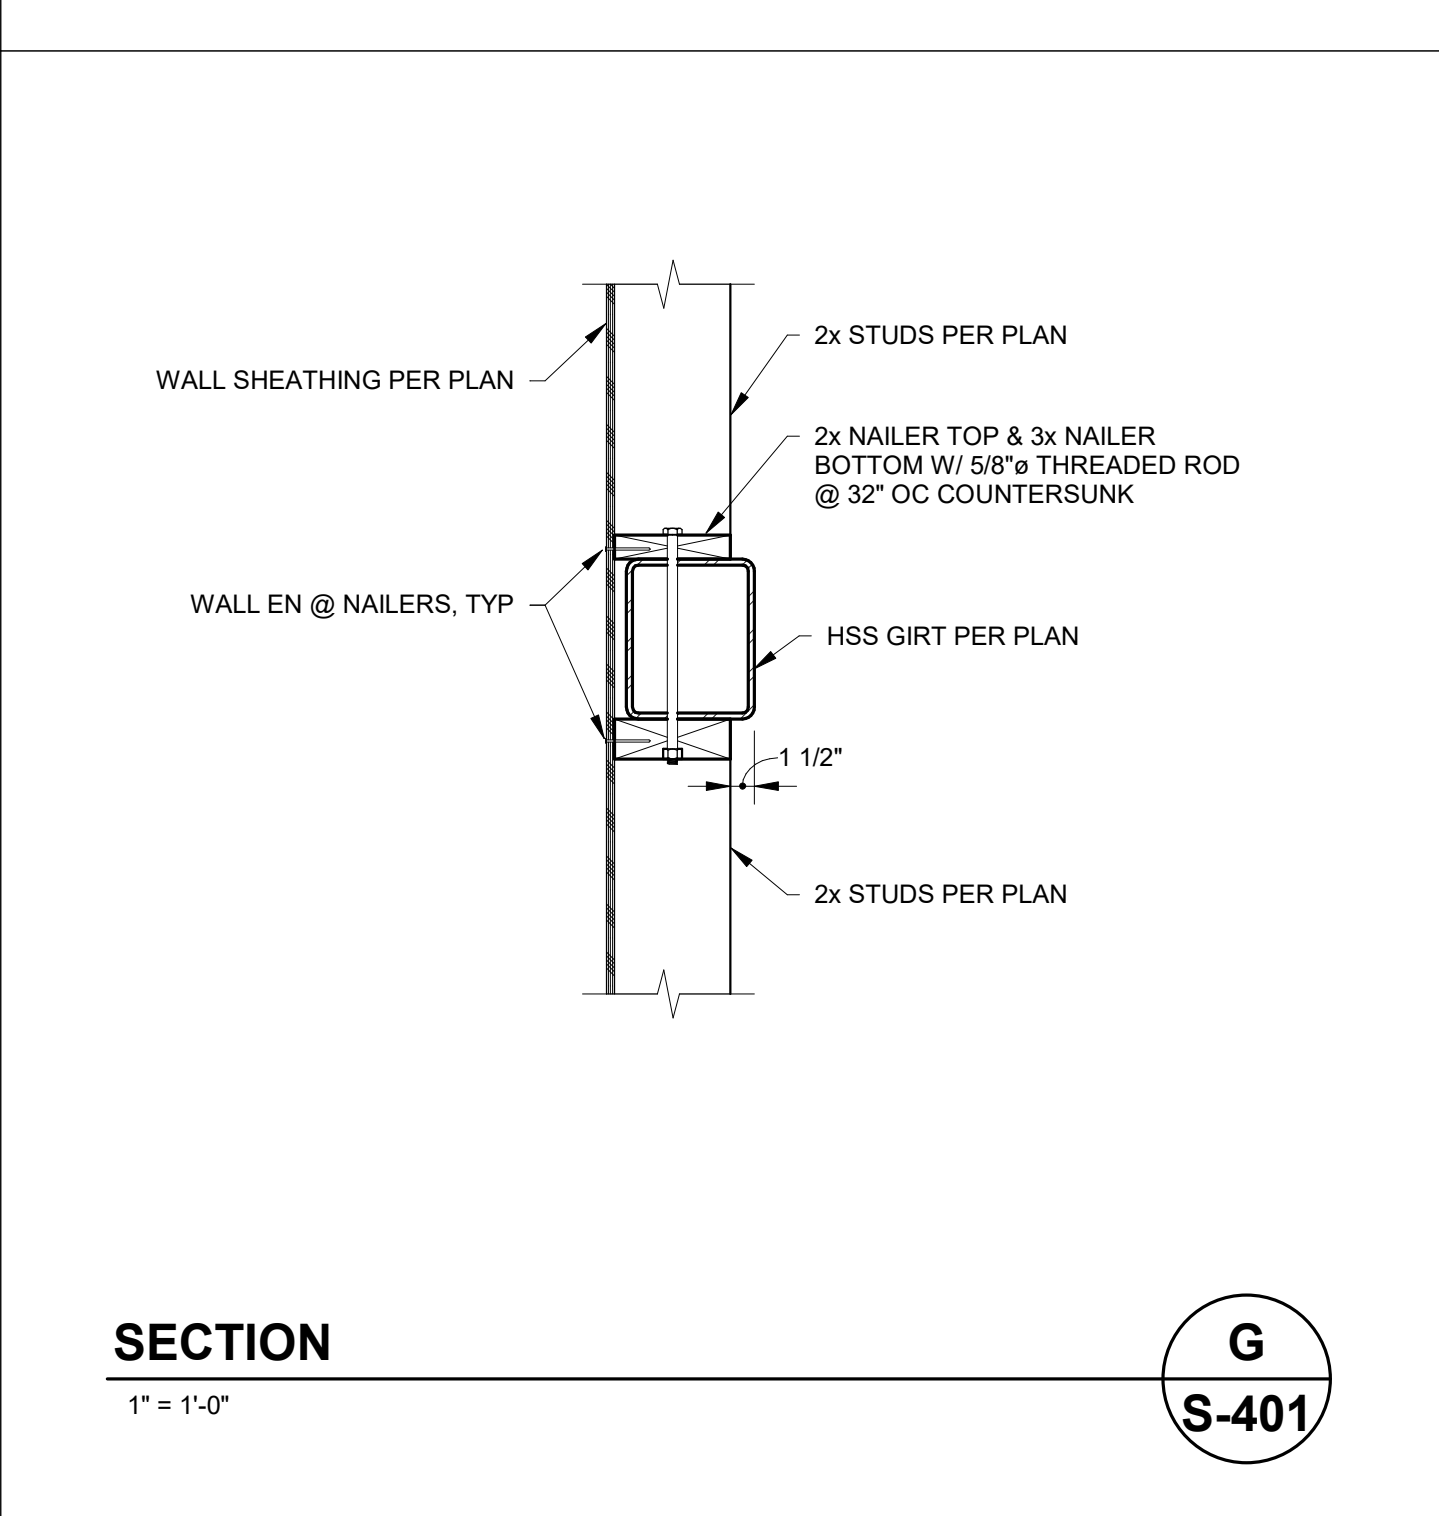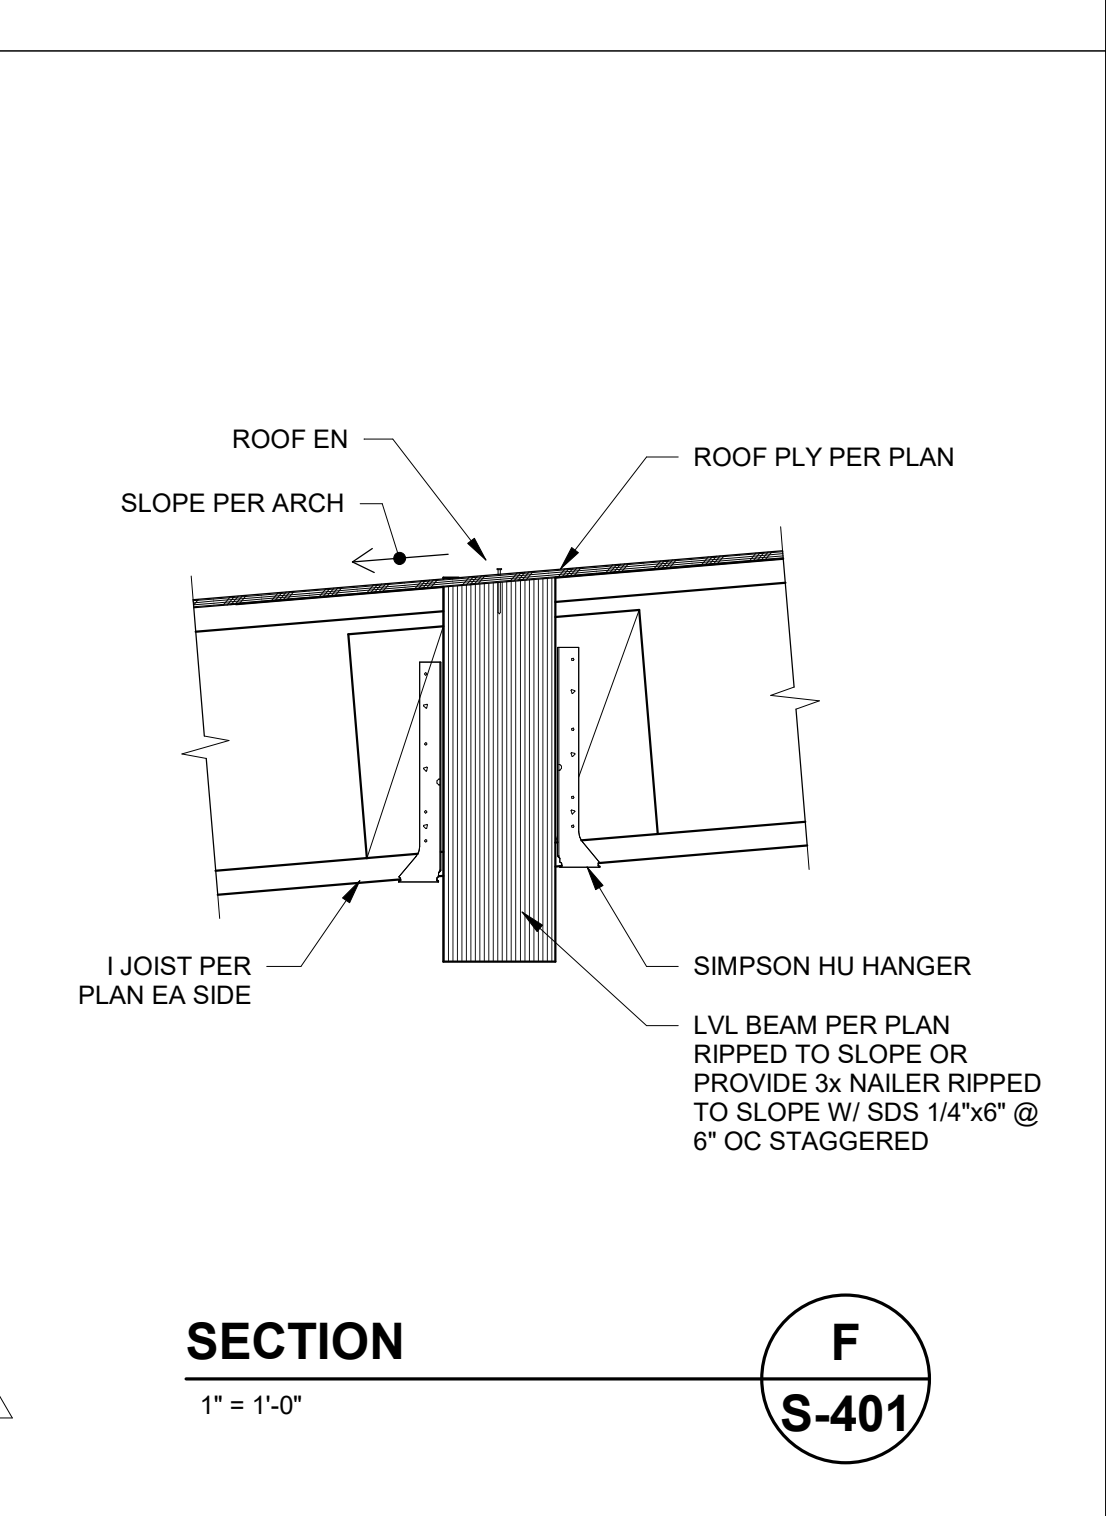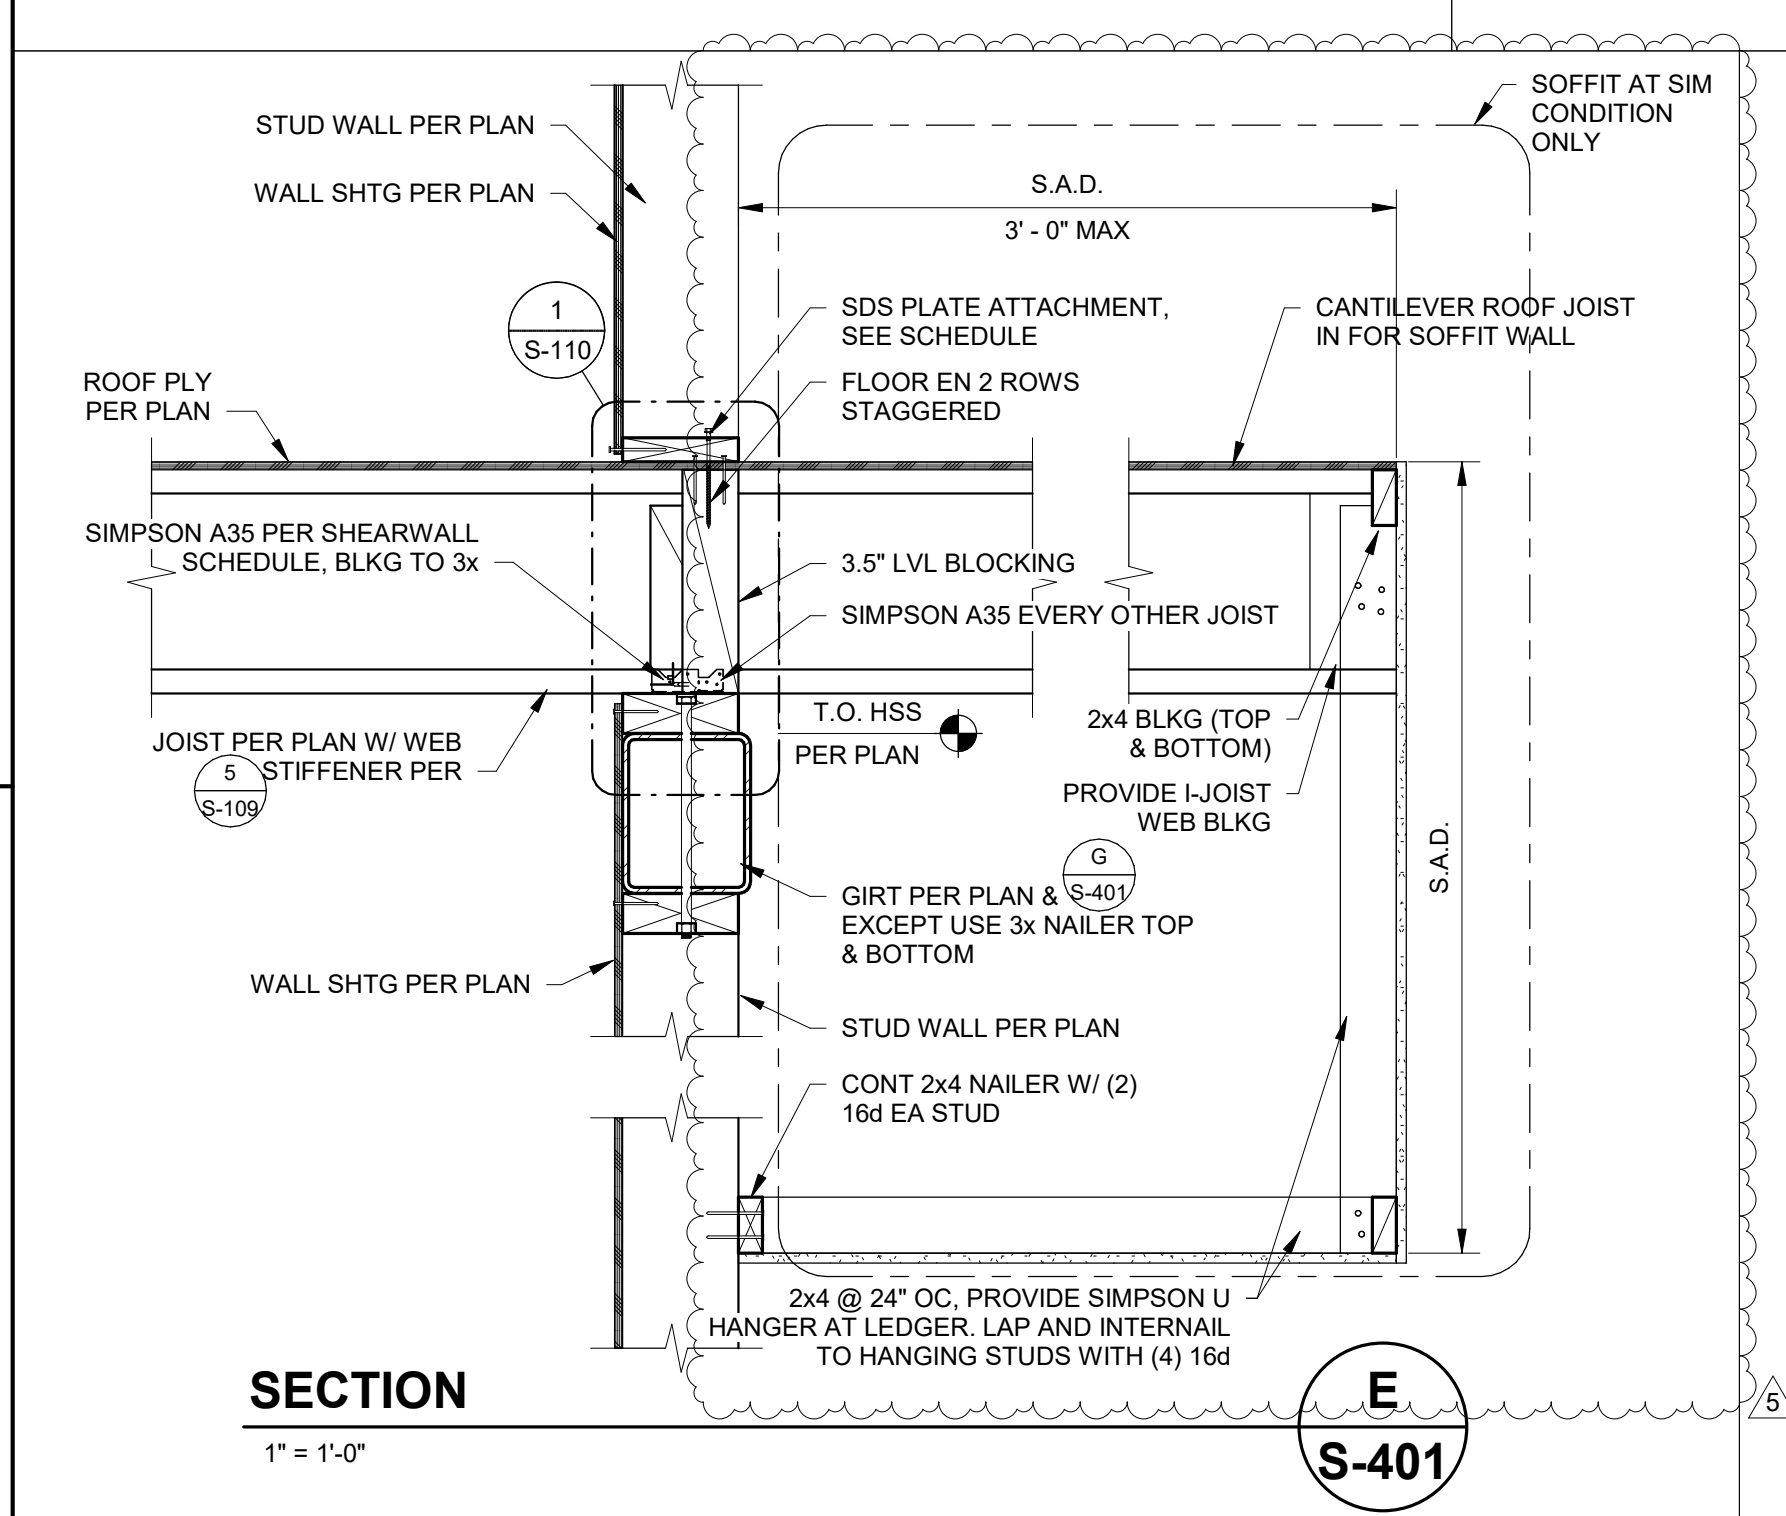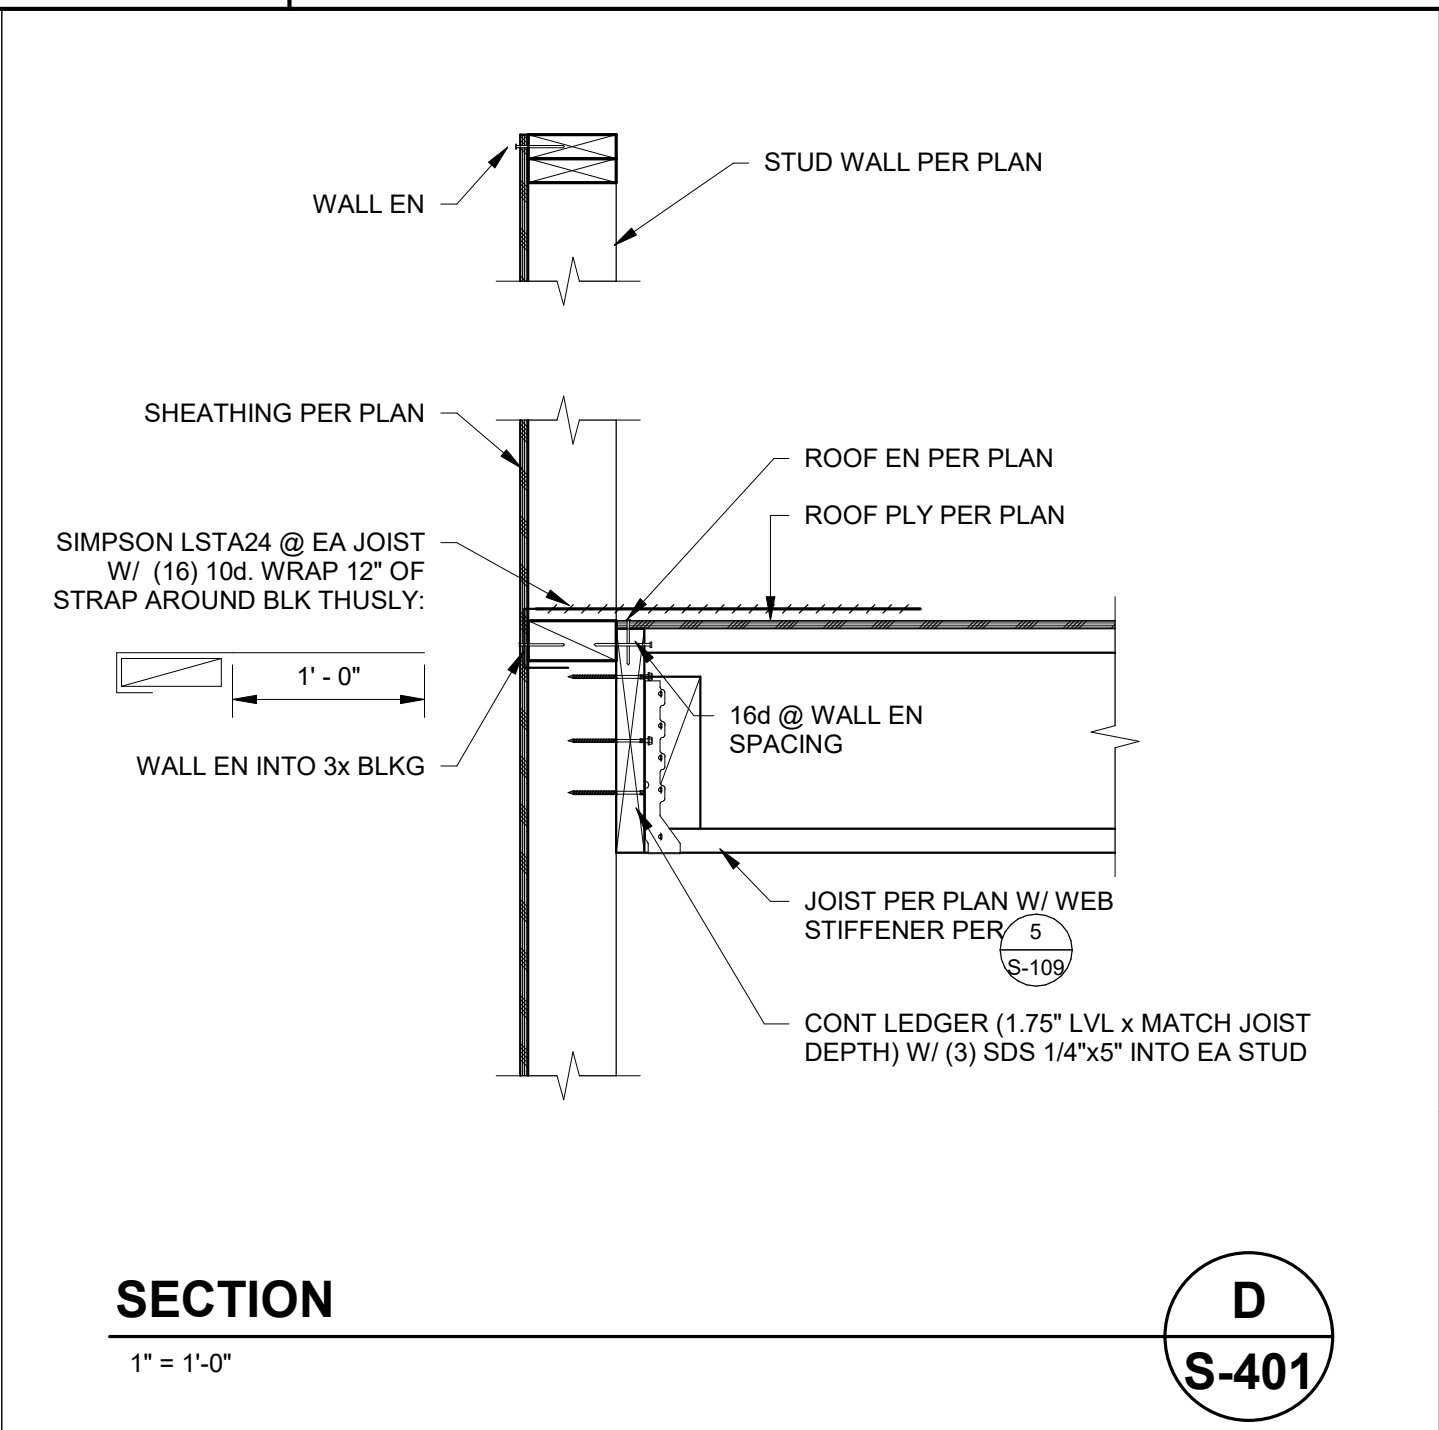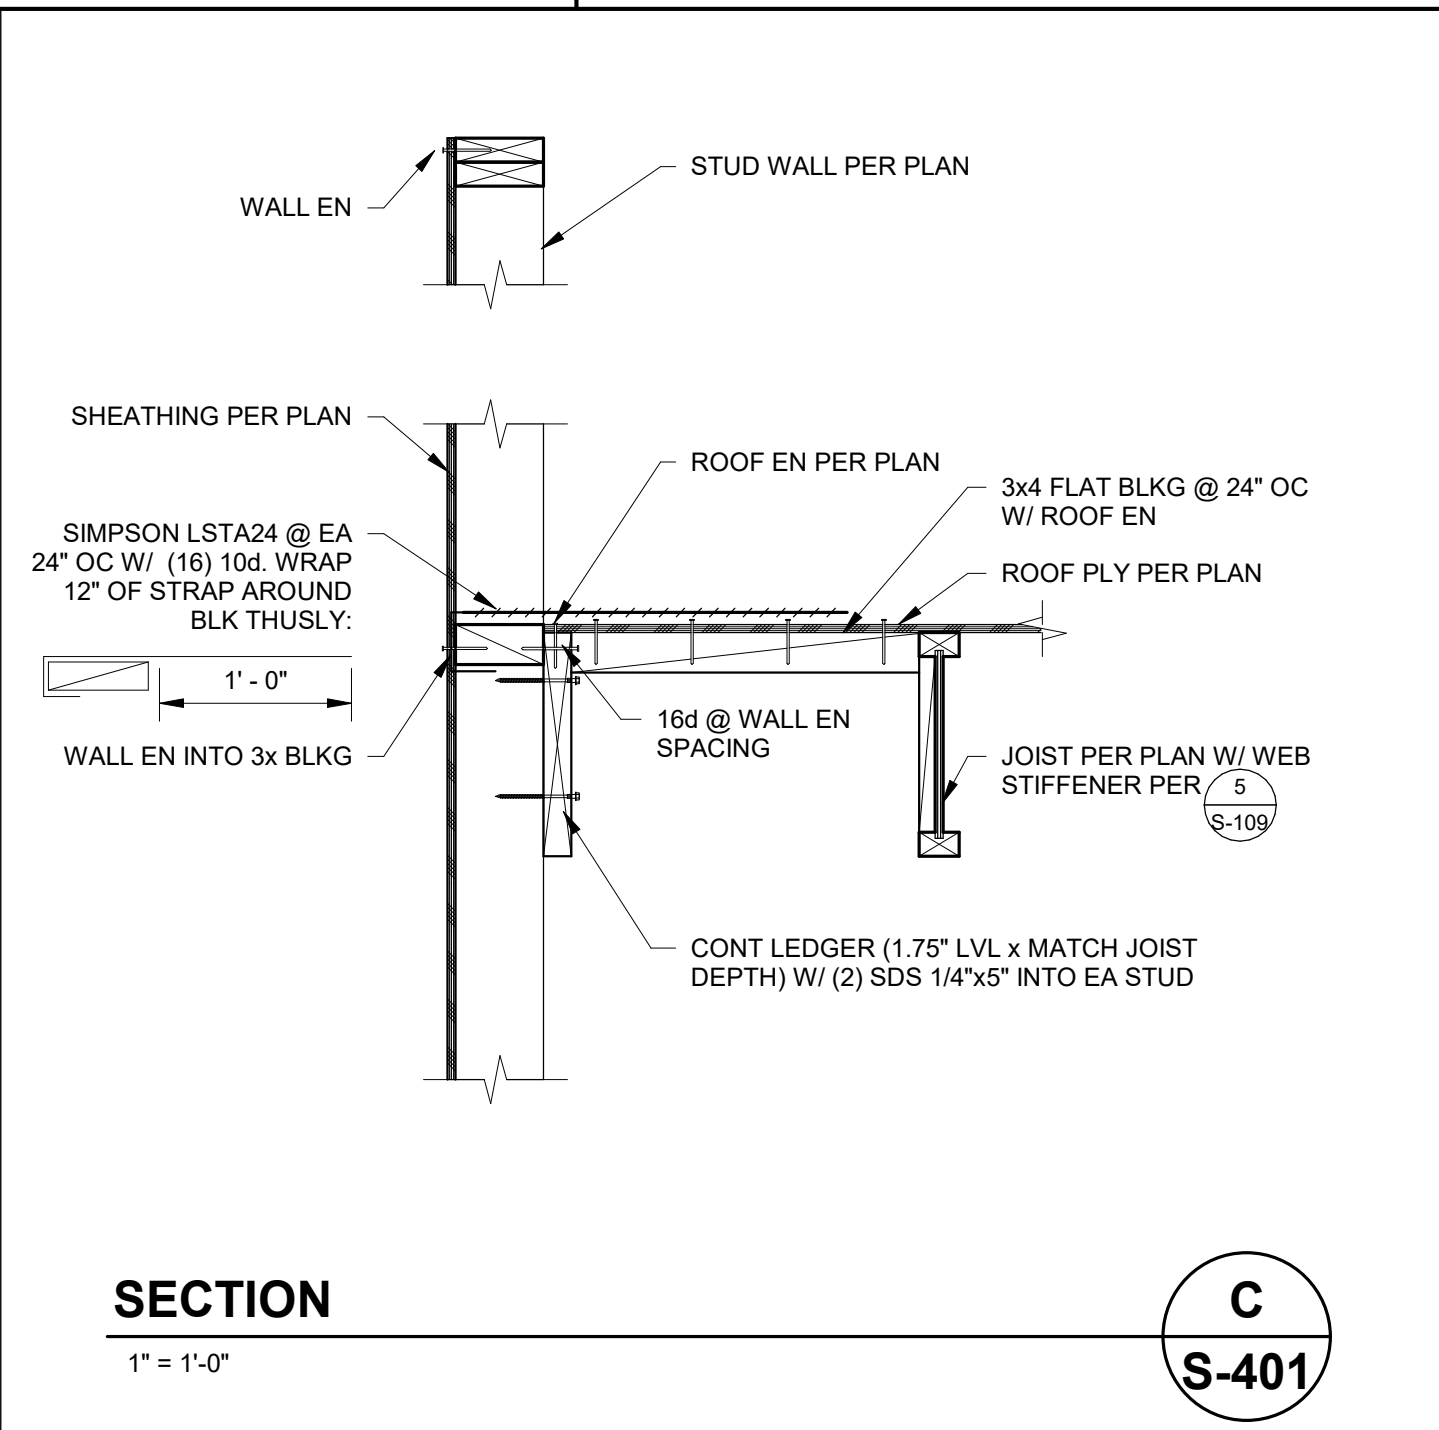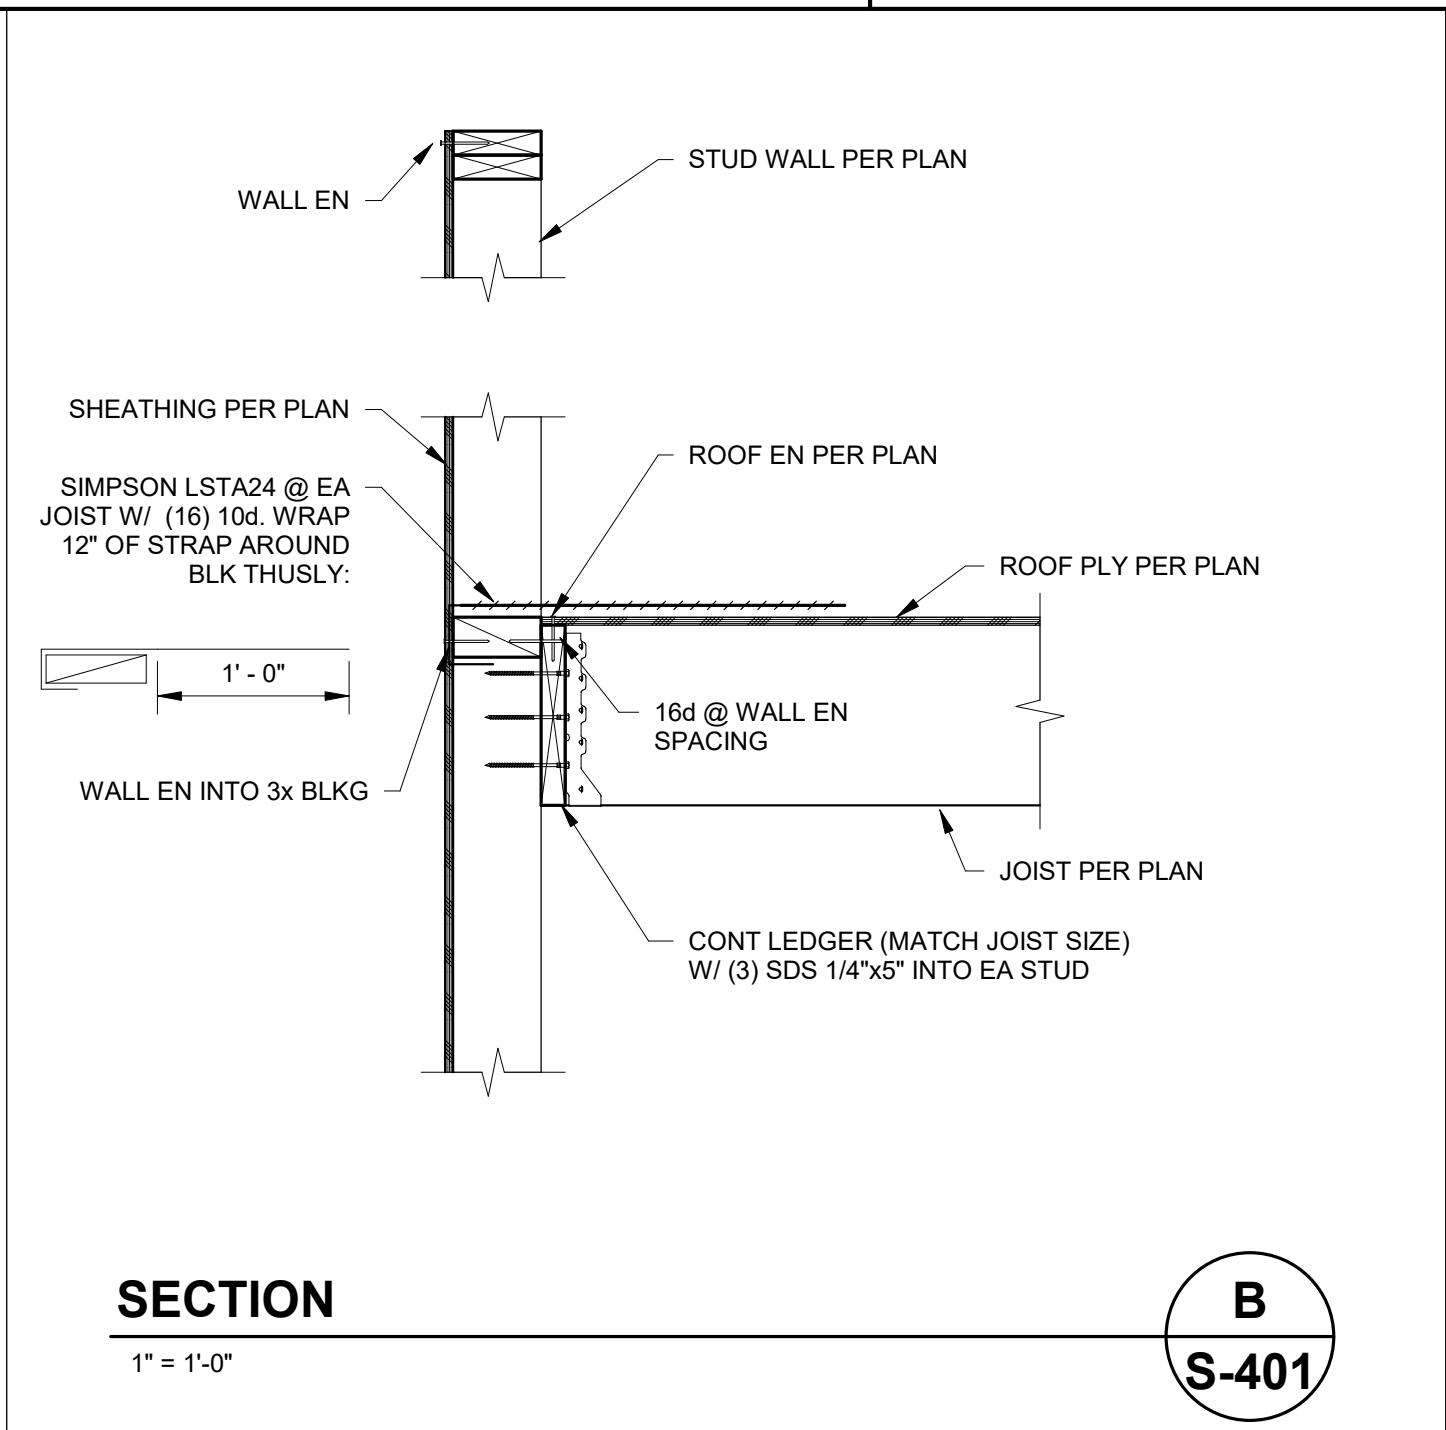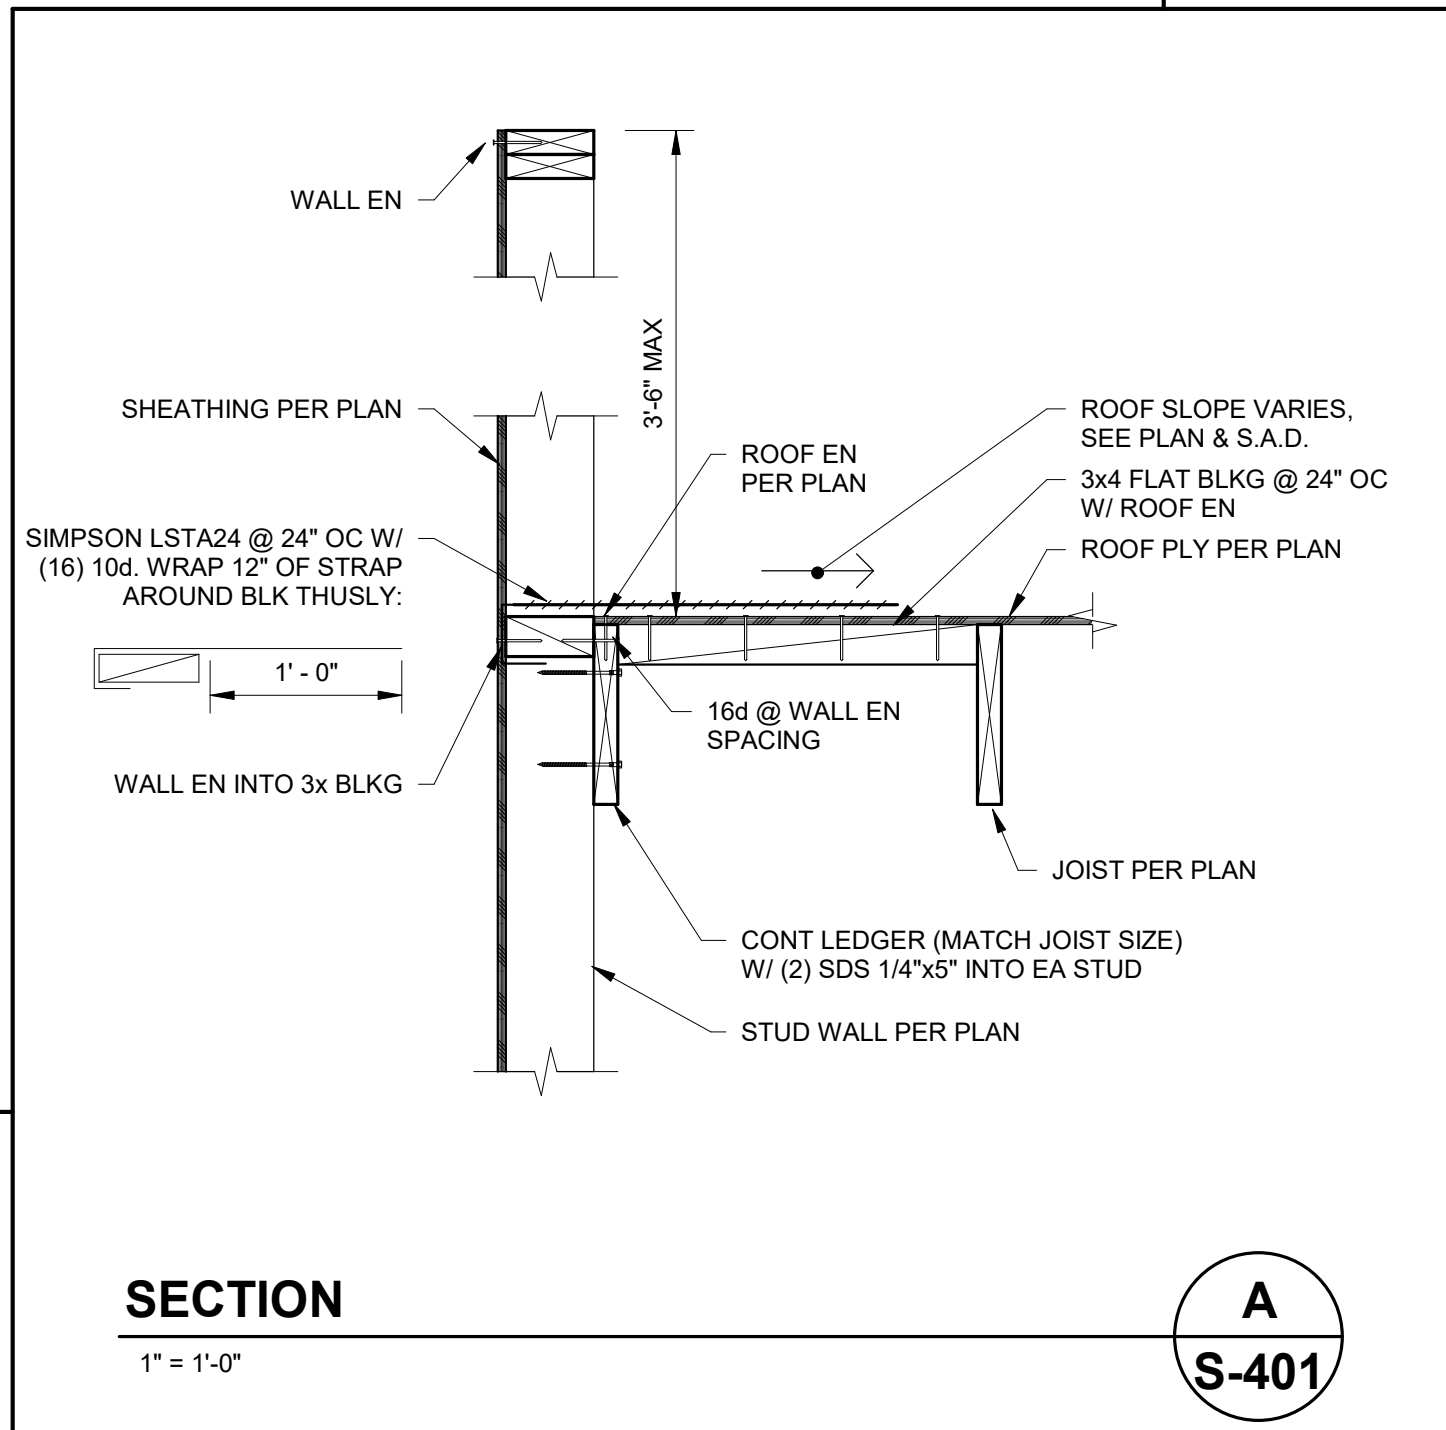

CONSULTANT
CORNERSTONE
structural engineering group
986 W. Alvarado, Suite 201
Fresno, California 93711
559.320.3200
fax 559.320.3201


AGENCY

PORTERVILLE COMMUNITY CENTER
N 4TH ST, PORTERVILLE, CA 93257
ROOF FRAMING DETAILS No. 1

NO.	REVISION	DATE
5	ADDENDUM 6	12/20/24
4		
3		
2		
1		
PROJECT MANAGER		
DRAWN BY		CHECKED BY
DATE		
09.10.24		
PROJECT NUMBER		
2883-01-RC22		
SHEET		
S-401		


CONSTRUCTION DOCUMENTS

1/2/2025 1:54:28 AM
Autocad Doss\2883-01_Porterville Fourth St Community Center\2883-01-RC22_Porterville_v22.rvt

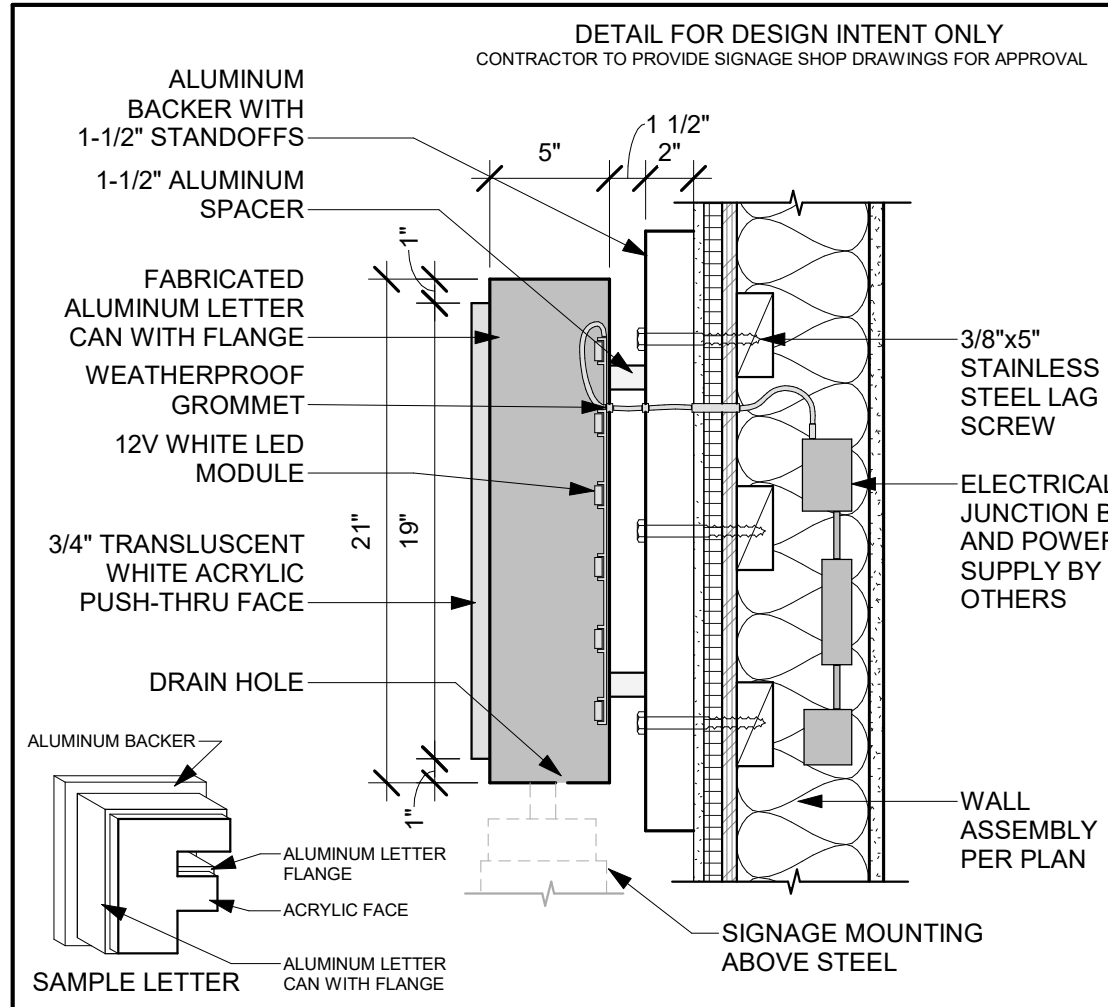


61 BUILDING SIGNAGE DETAIL

SCALE: 1 1/2" = 1'-0"

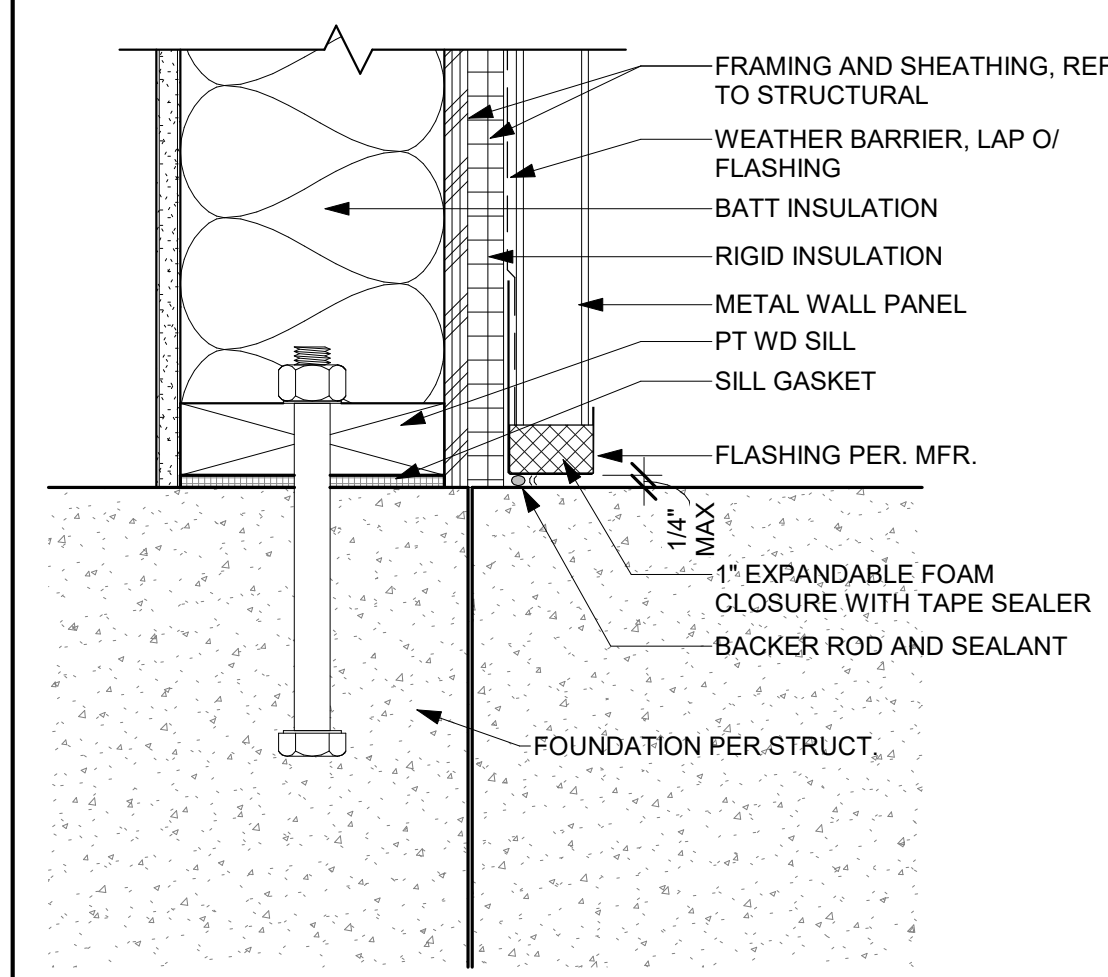


62 METAL PANEL WALL AT LEVEL CONC.

SCALE: 3" = 1'-0"

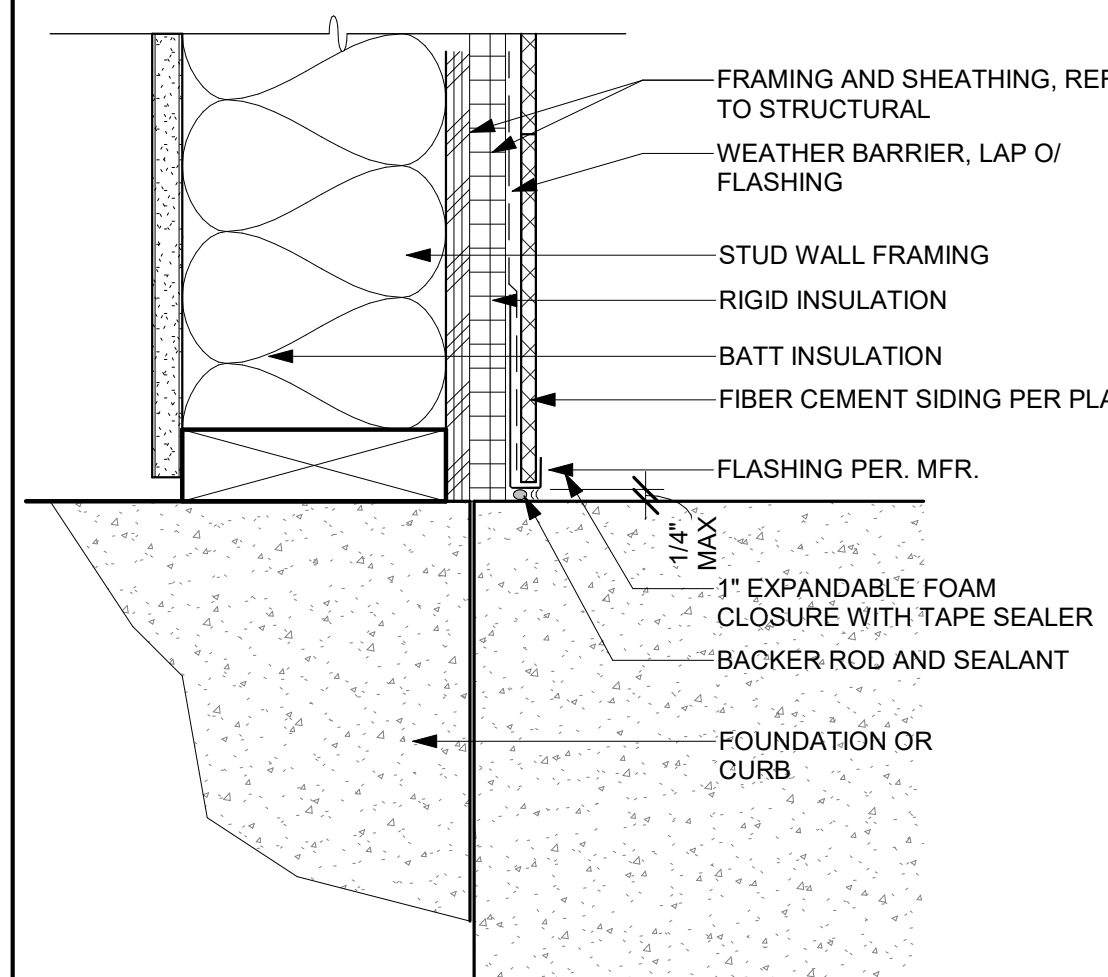


63 FIBER CEMENT WALL AT LEVEL CONC.

SCALE: 3" = 1'-0"

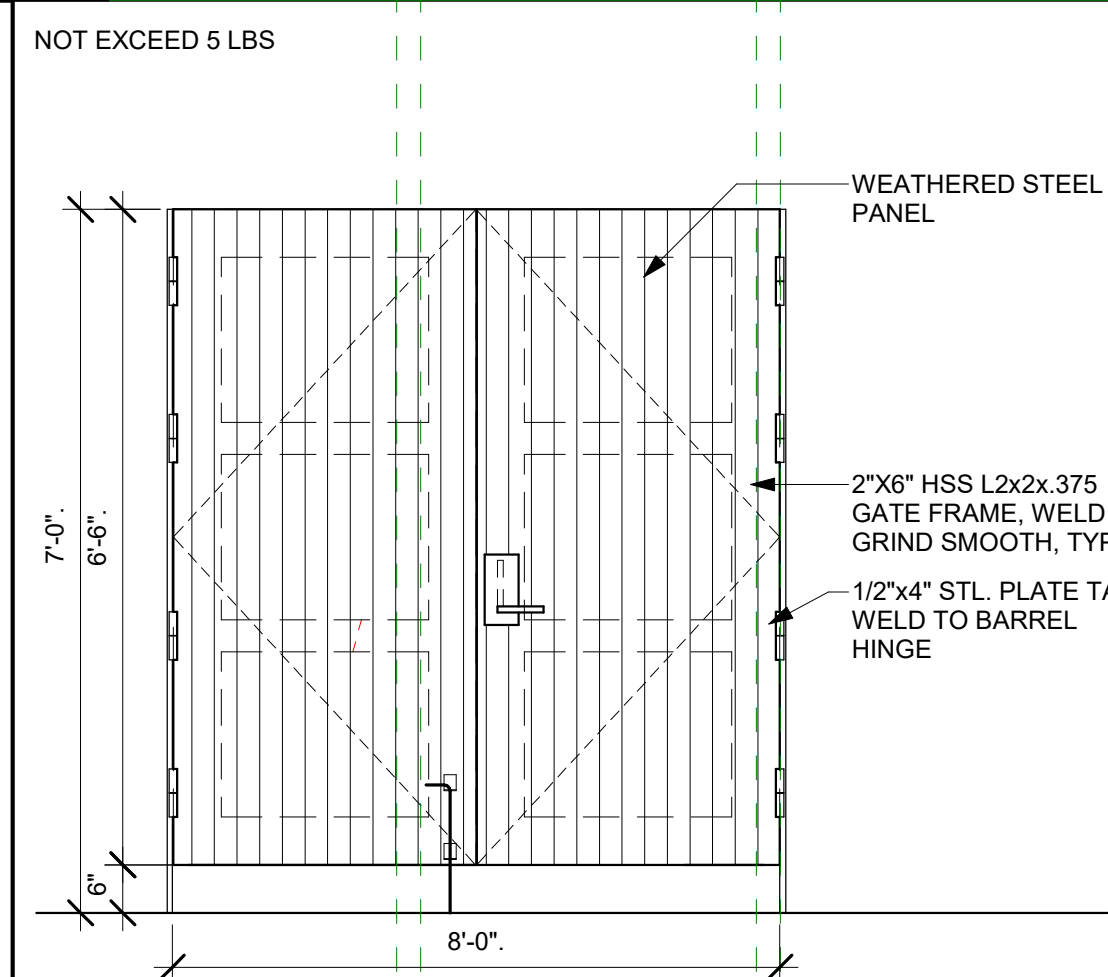


64 ELECTRICAL YARD GATE

SCALE: 1/2" = 1'-0"

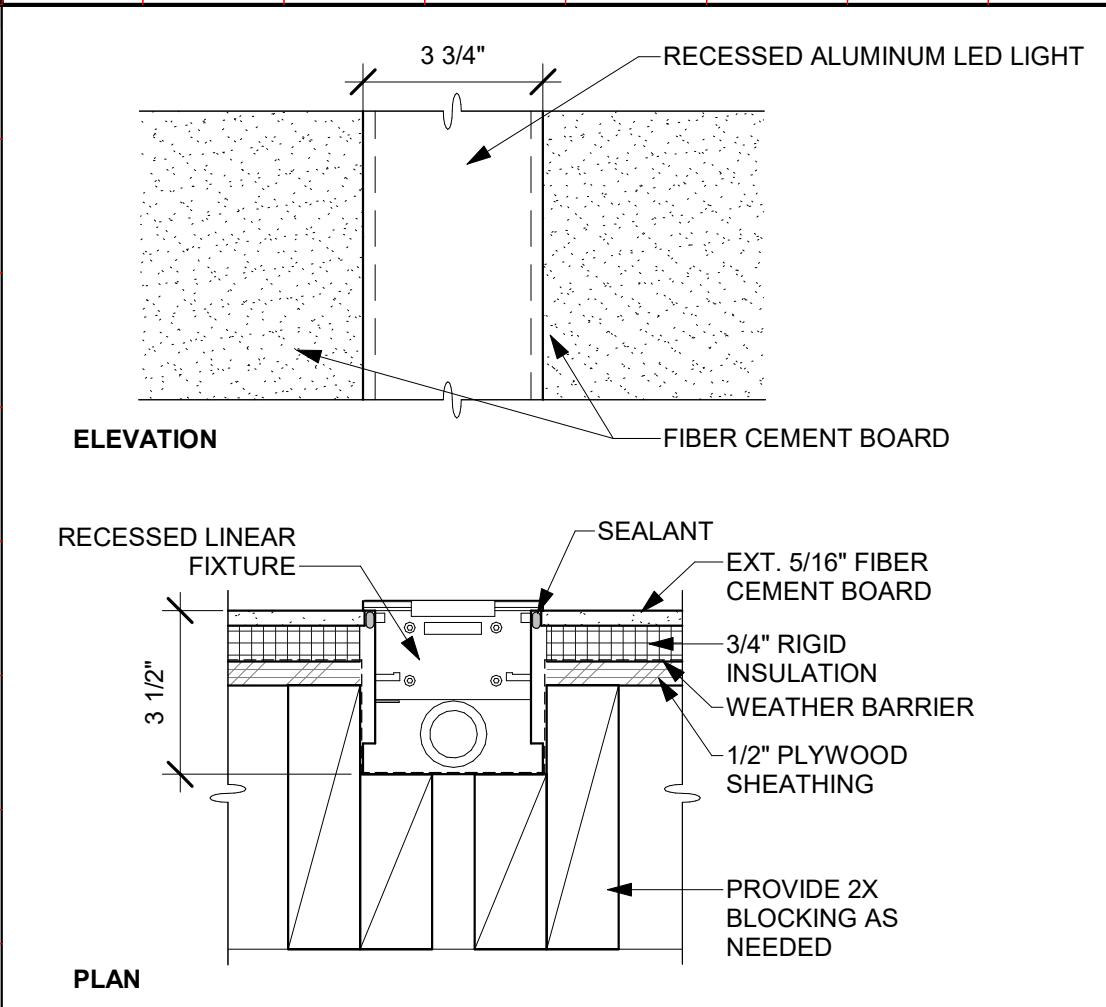


51 LED STRIP LIGHT 2

SCALE: 3" = 1'-0"

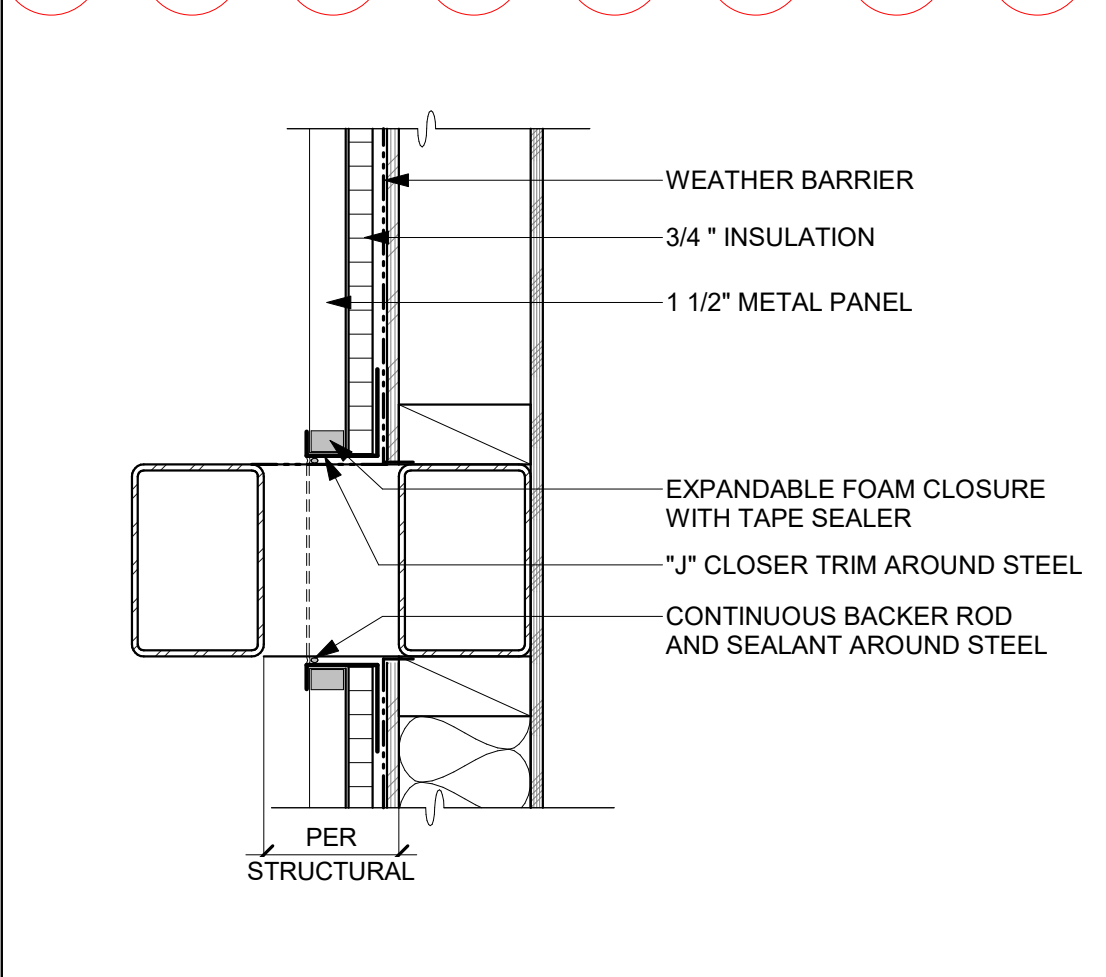


52 STEEL PENETRATION-MTL PANEL WALL

SCALE: 1 1/2" = 1'-0"

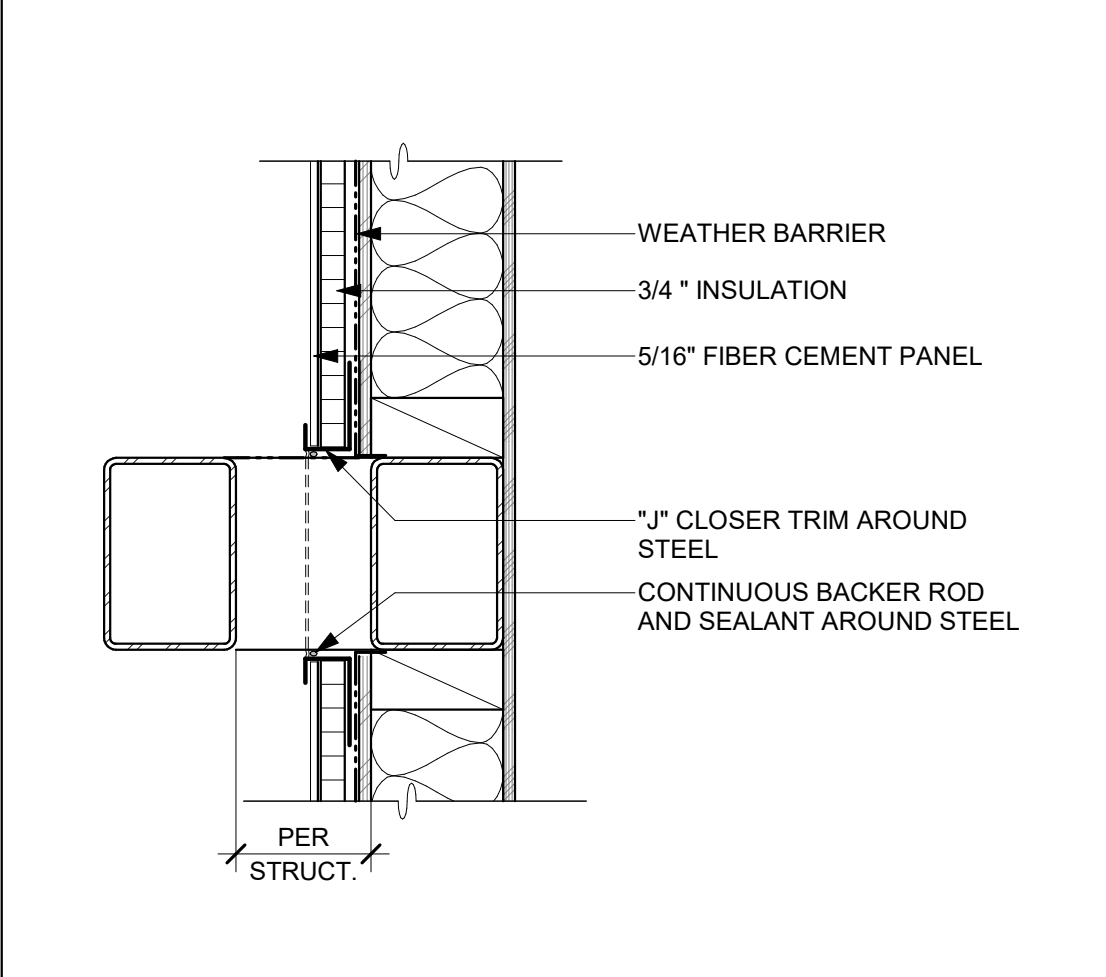


53 STEEL PENETRATION-FIBER CEMENT

SCALE: 1 1/2" = 1'-0"

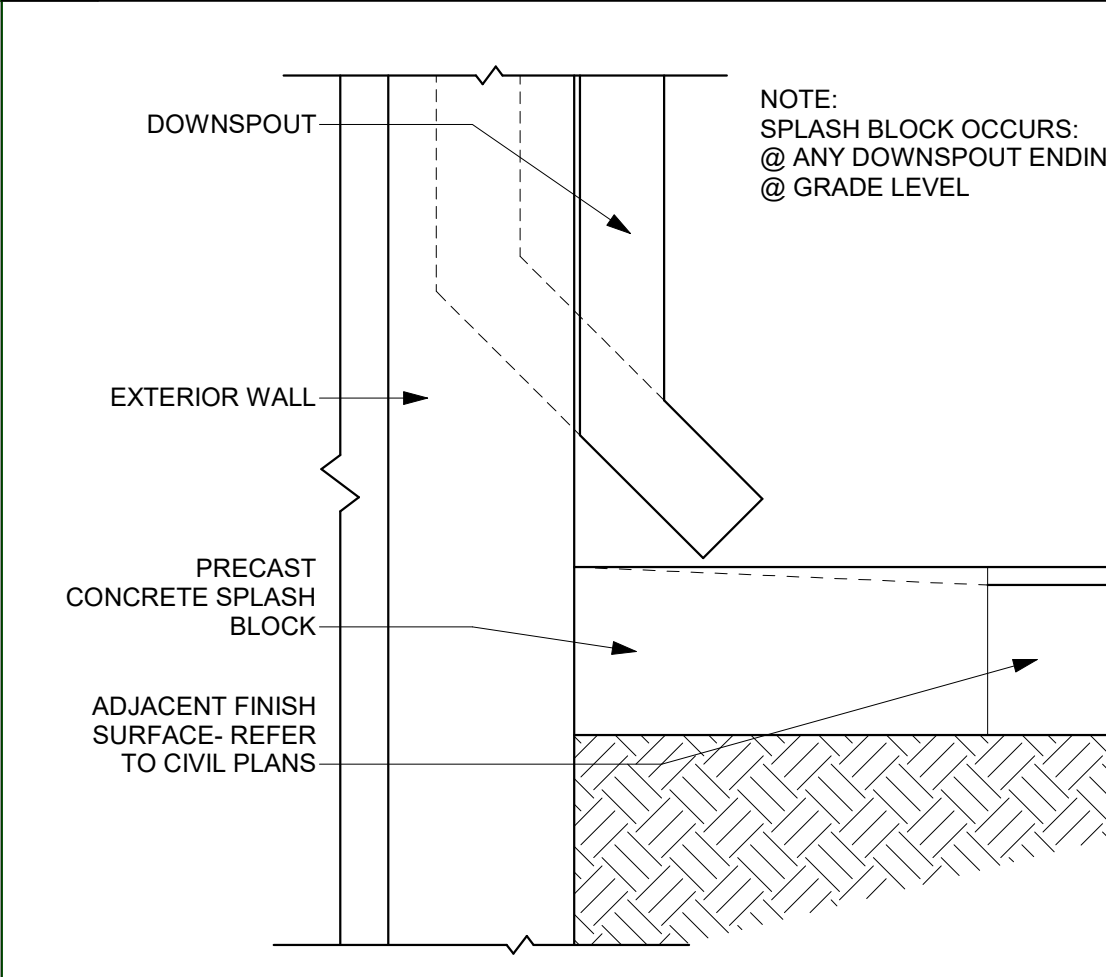


54 SPLASH BLOCK

SCALE: 1 1/2" = 1'-0"

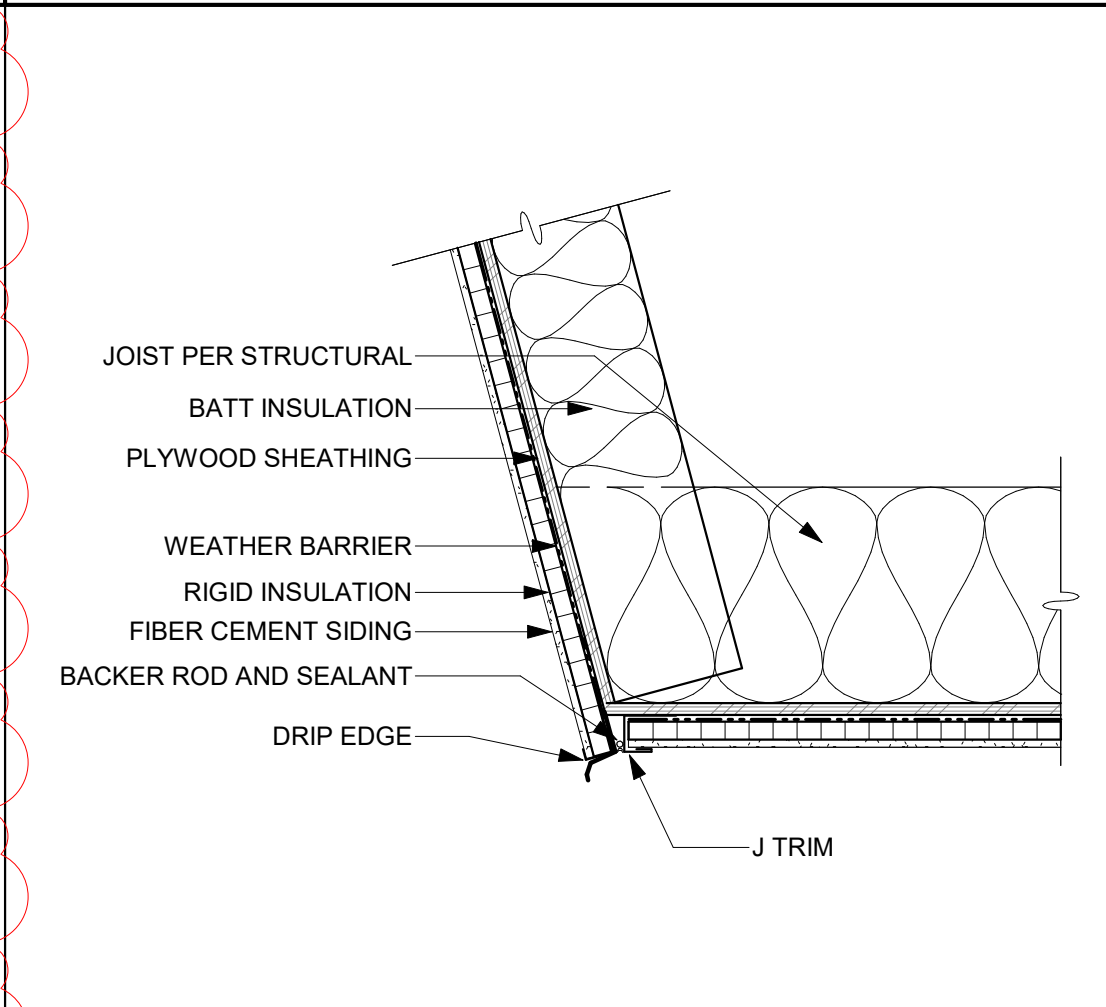


41 EXTERIOR OVERHANG

SCALE: 1 1/2" = 1'-0"

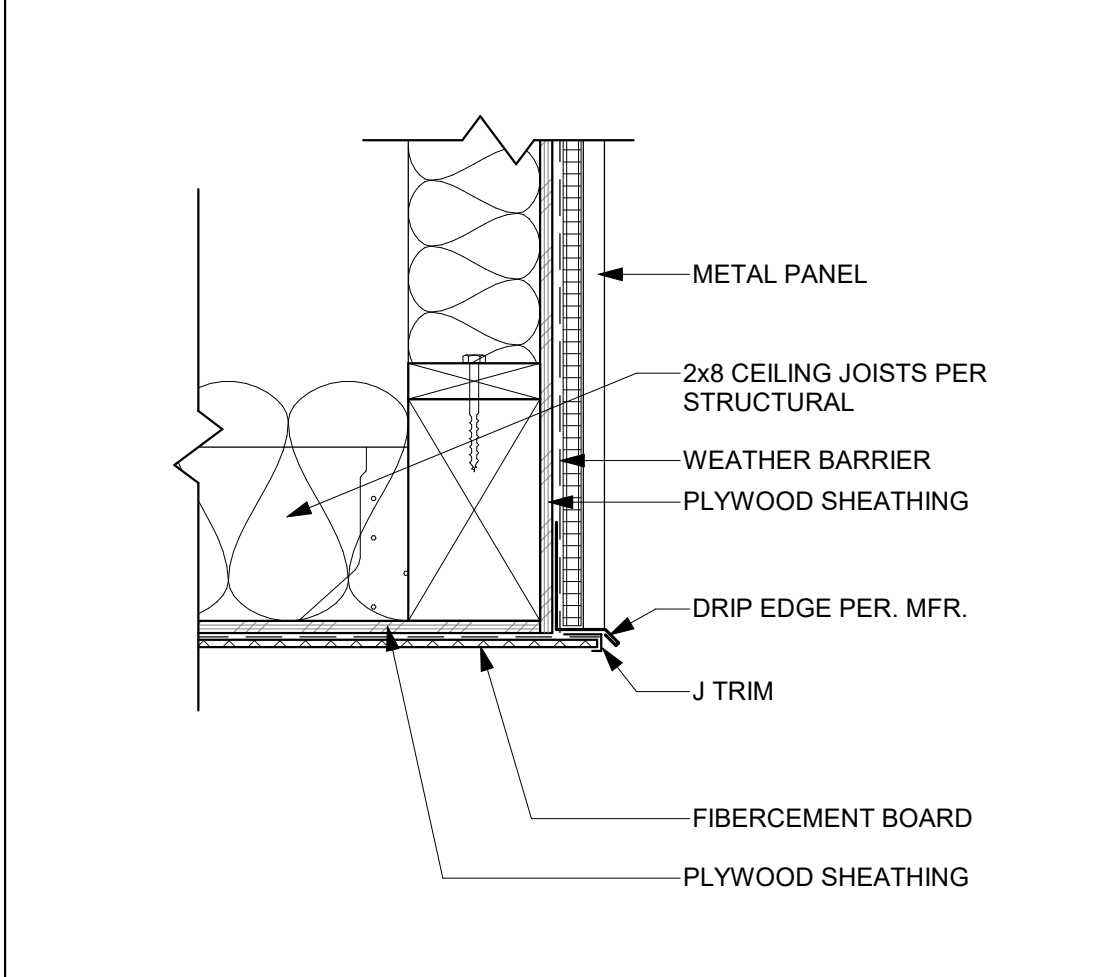


42 EXT. FIBERCEMENT SOFFIT TO WALL

SCALE: 1 1/2" = 1'-0"

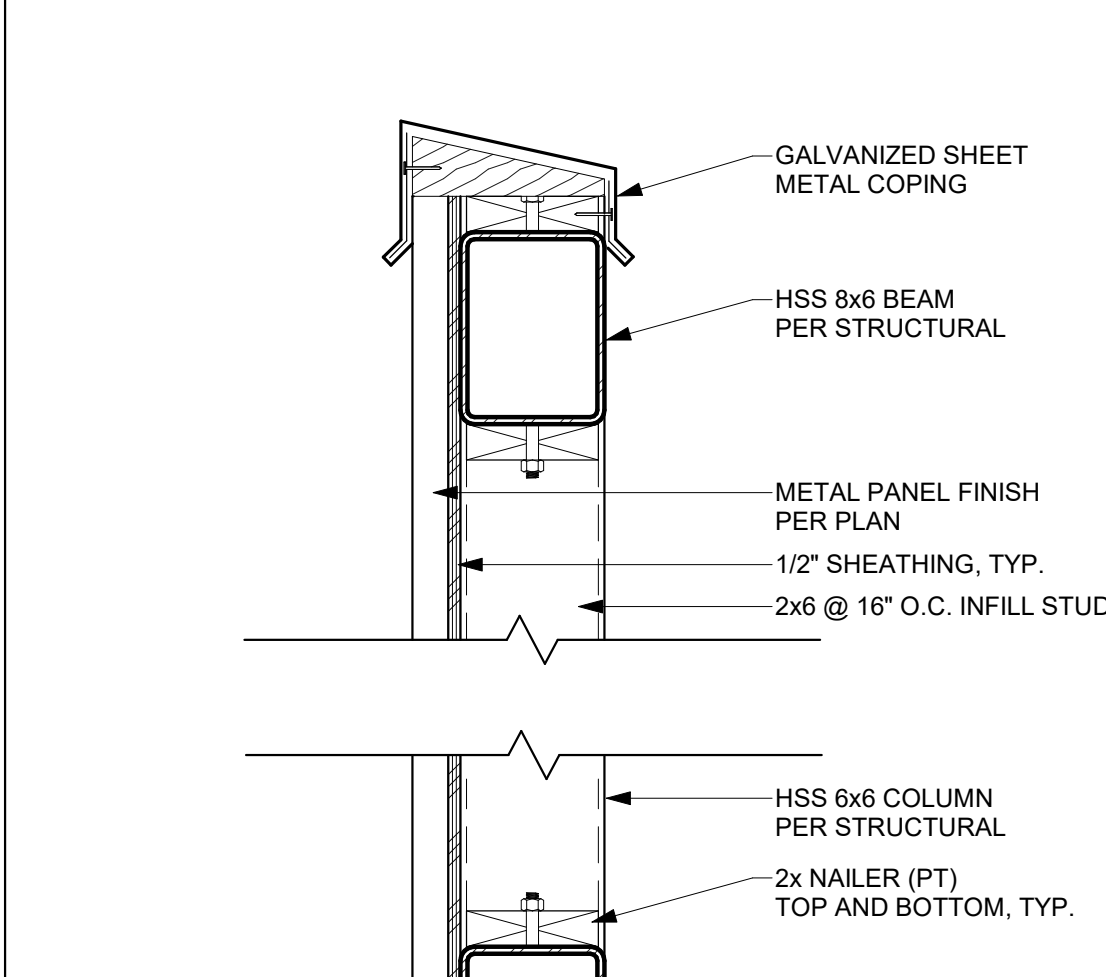


44 ENCLOSURE WALL

SCALE: 1 1/2" = 1'-0"

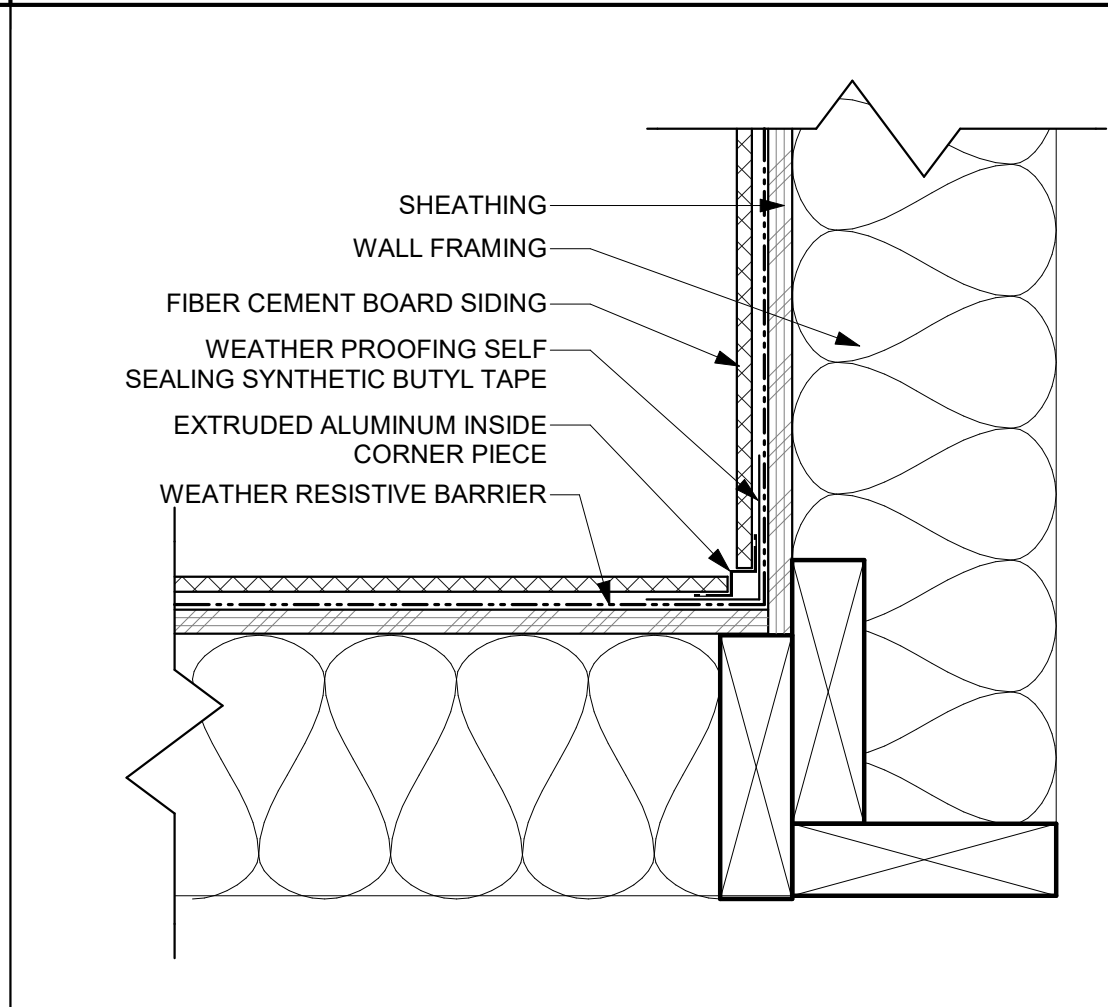


31 FIBER CEMENT BOARD - INSIDE CORNER

SCALE: 3" = 1'-0"

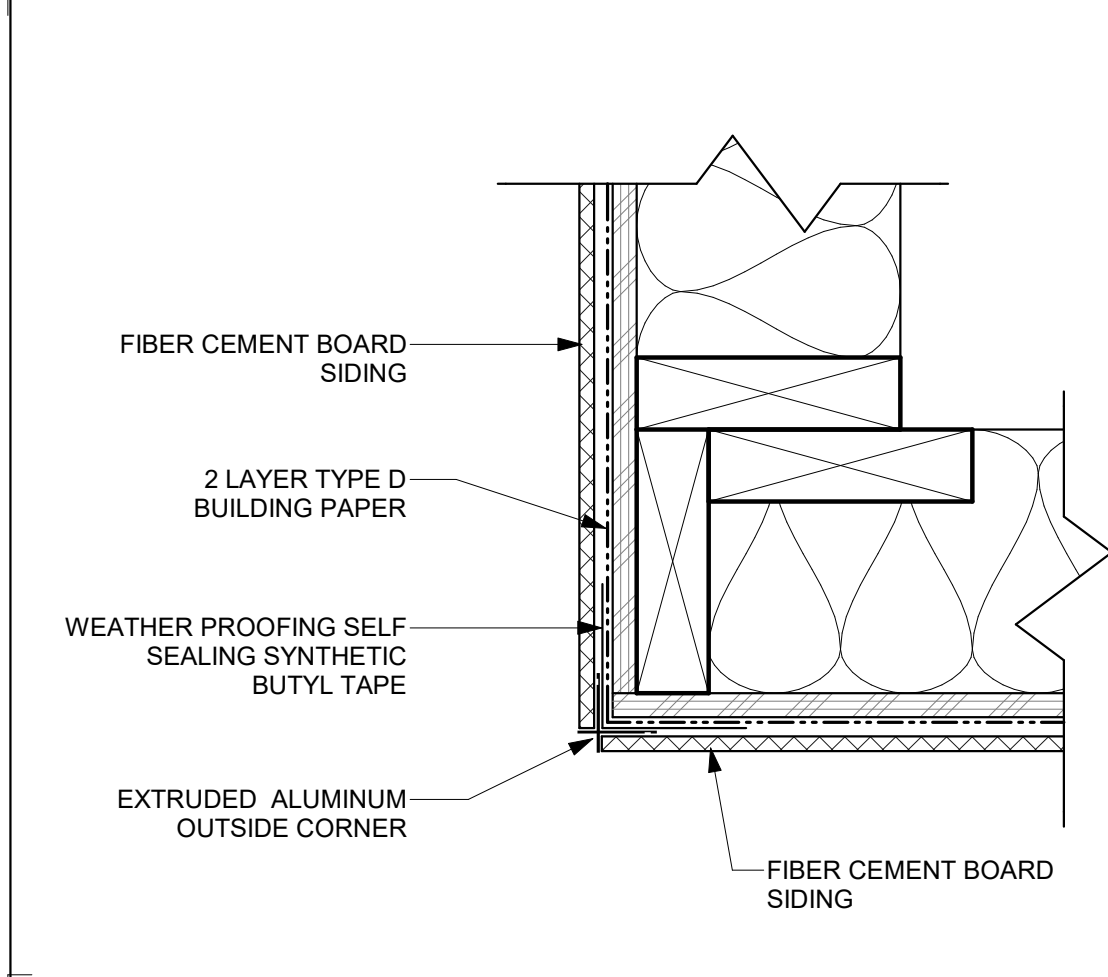


32 FIBER CEMENT BOARD - EXT. CORNER

SCALE: 3" = 1'-0"

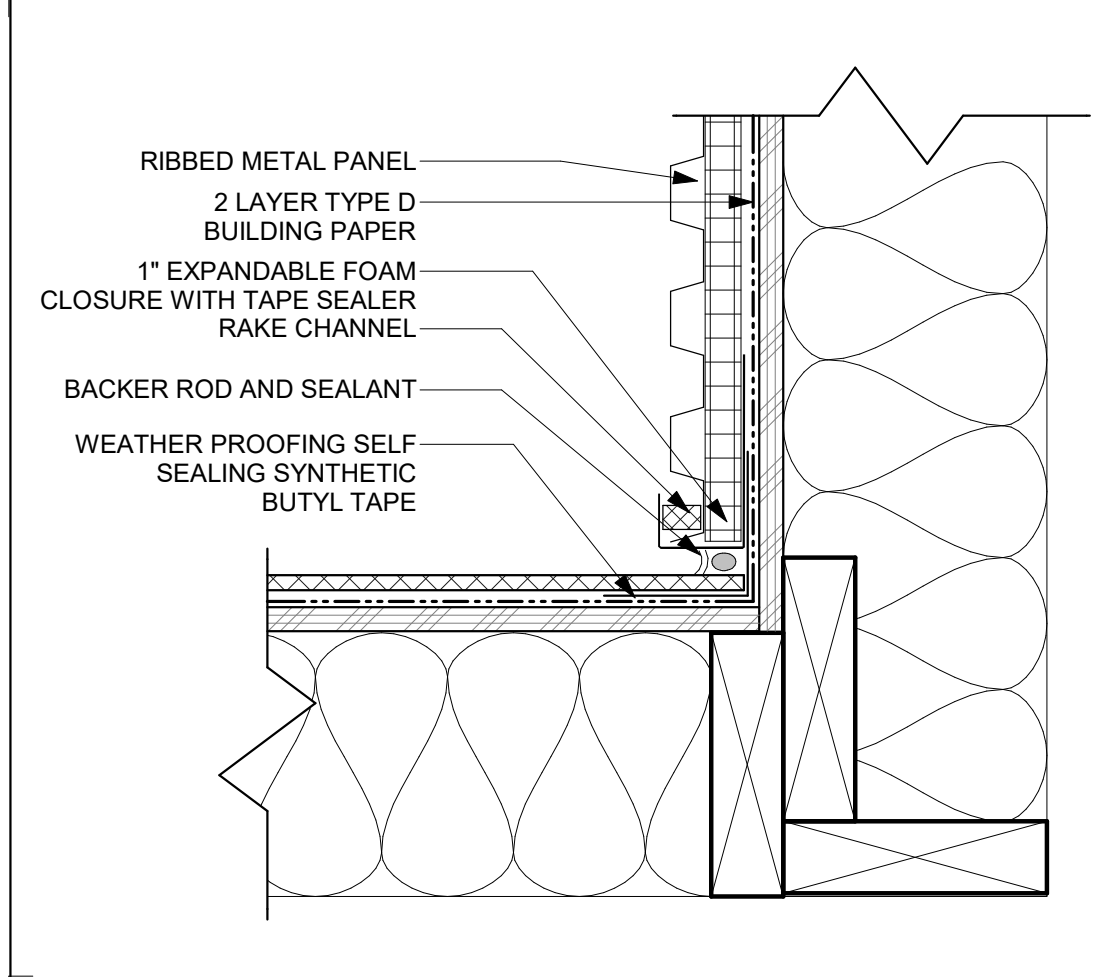


33 FIBER CEMENT BOARD TO MTL PANEL

SCALE: 3" = 1'-0"

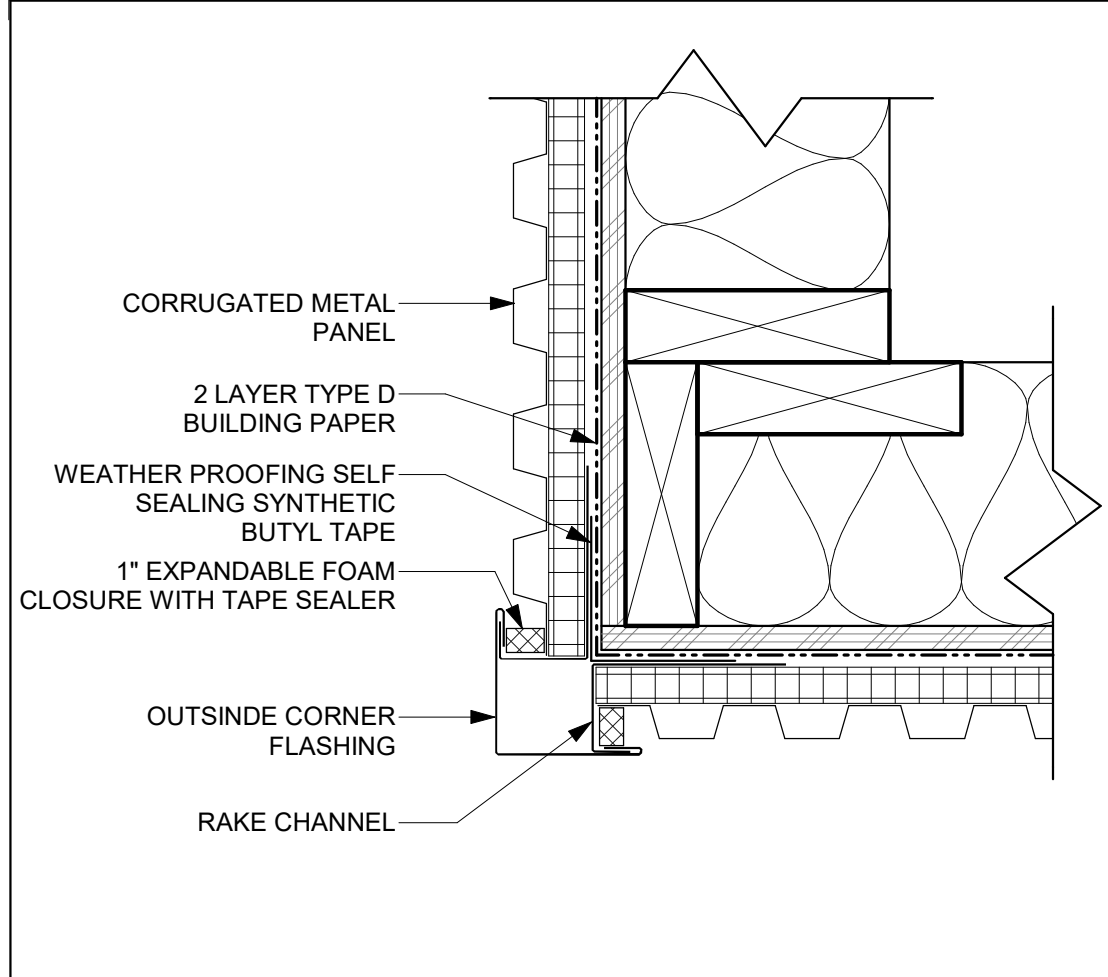


34 METAL PANEL - OUTSIDE CORNER

SCALE: 3" = 1'-0"

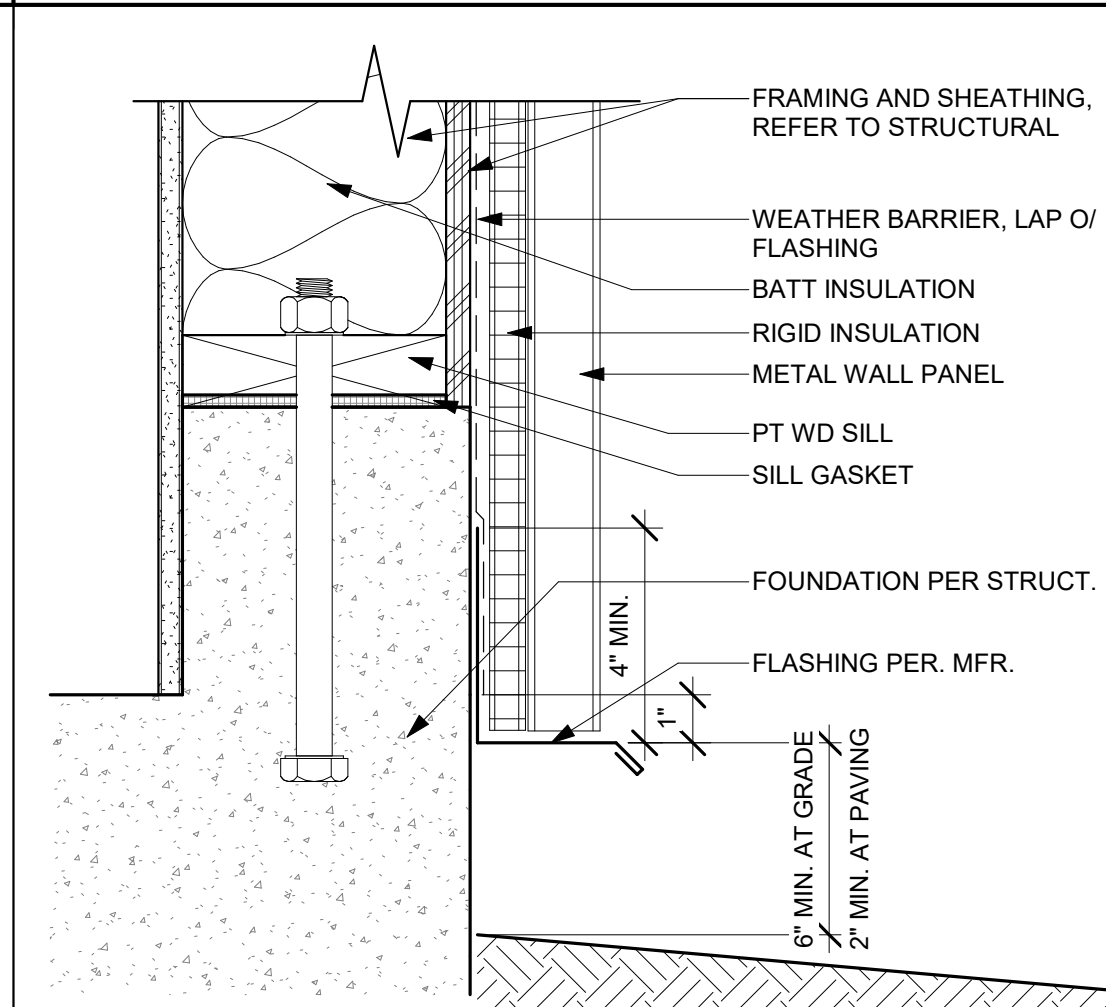


11 METAL PANEL WALL AT CURB

SCALE: 3" = 1'-0"

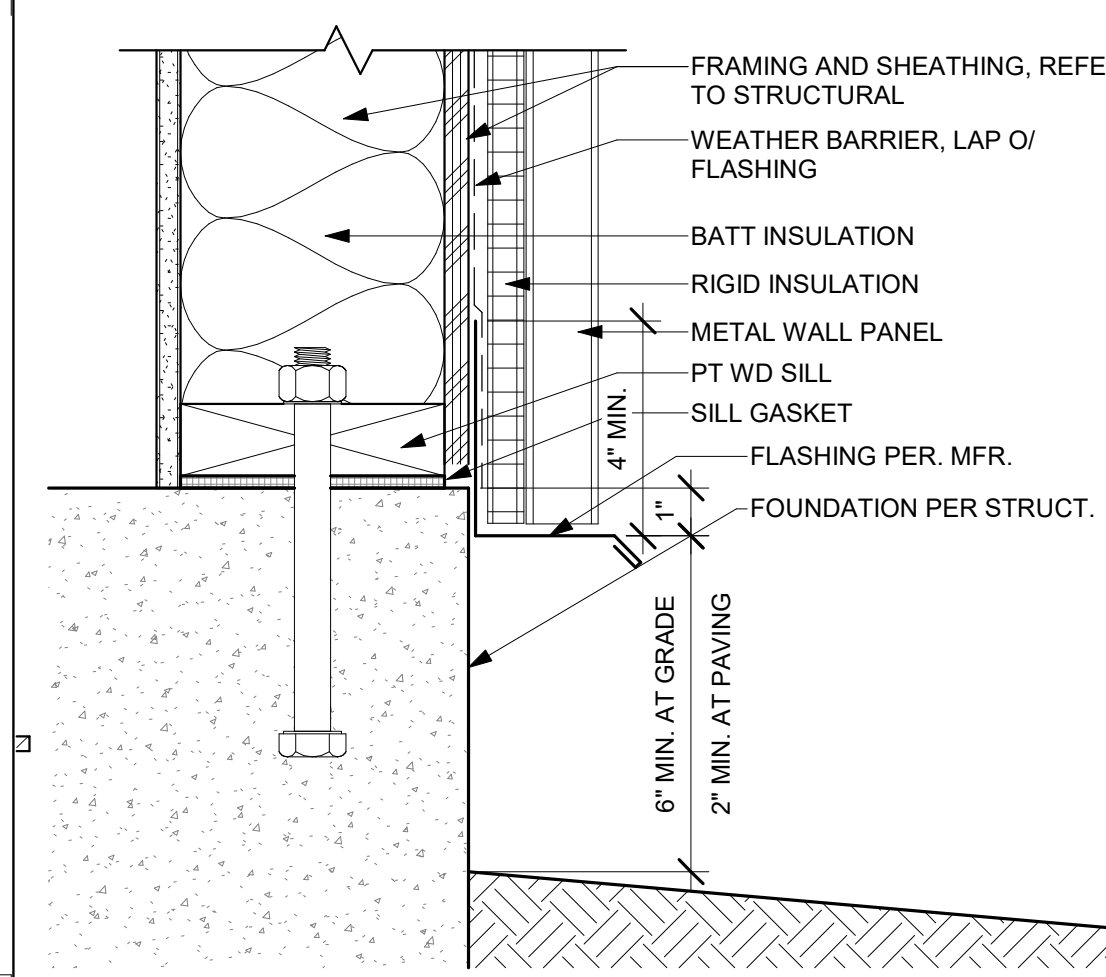


12 METAL PANEL WALL AT FINISH GRADE

SCALE: 3" = 1'-0"

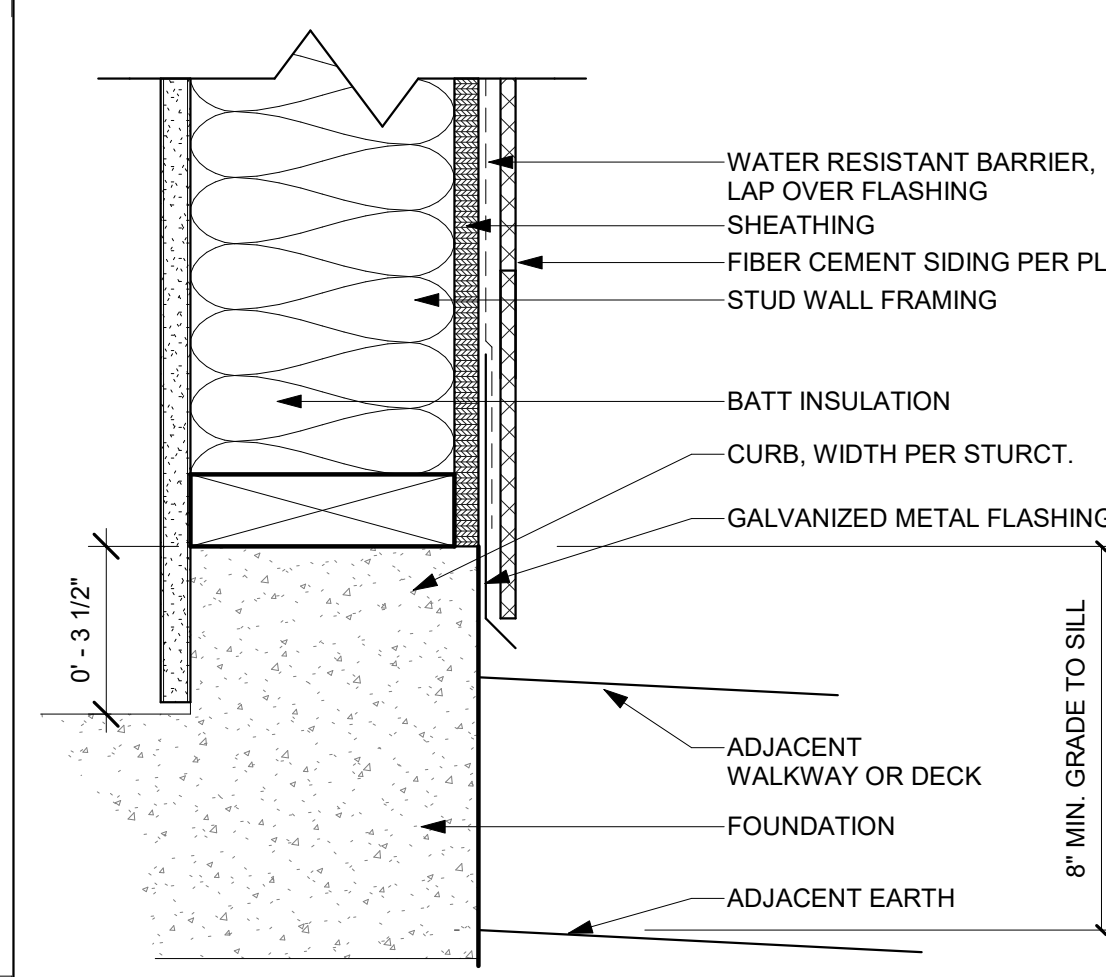

13 FIBER CEMENT WALL AT FINISH GRADE

SCALE: 3" = 1'-0"

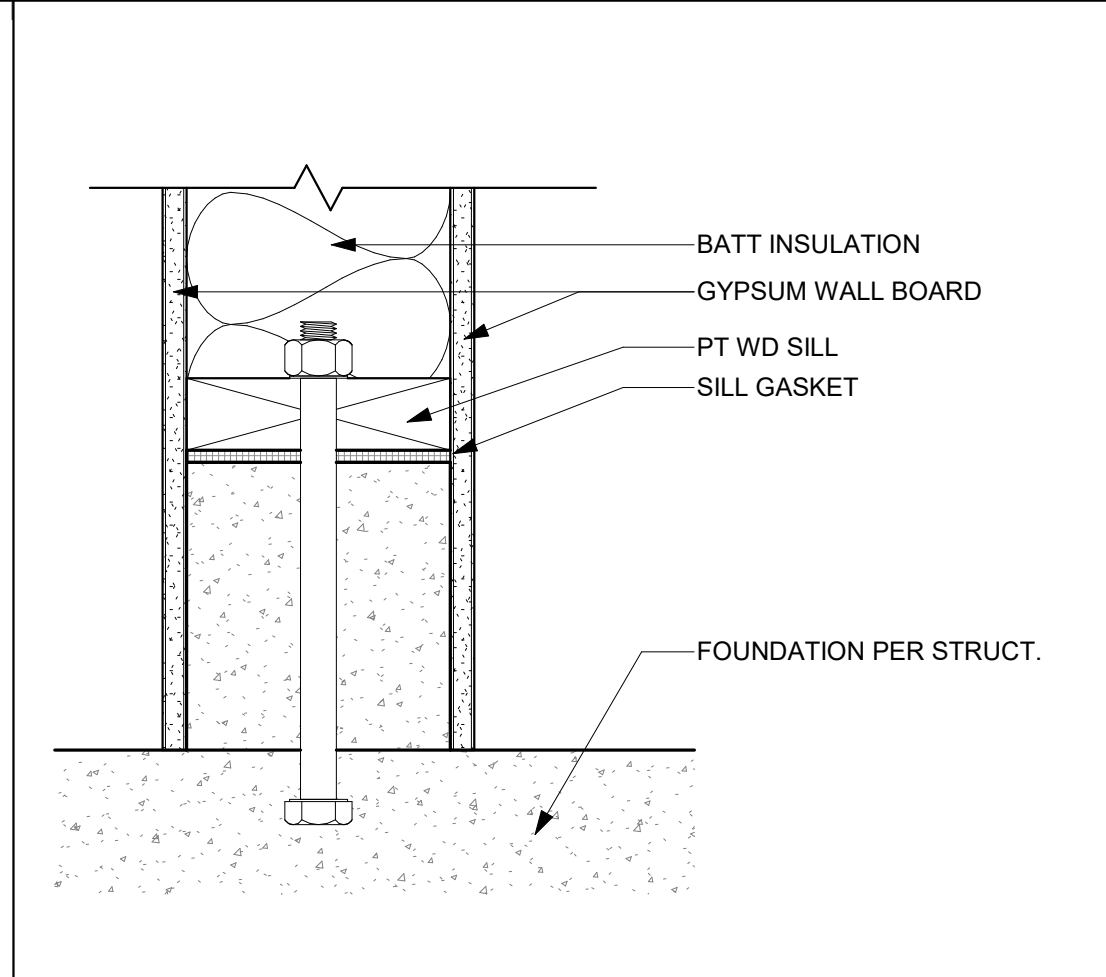

14 WALL CURB - INTERIOR

SCALE: 3" = 1'-0"

CONSULTANT

AGENCY

**FOURTH ST COMMUNITY
CENTER AND PARK**
HENDERSON AVE., PORTERVILLE, CA 93257
**ARCHITECTURAL DETAILS -
EXTERIOR**

NO.	REVISION	DATE
1	PLAN CHECK REVISION 1	05/17/24
2	ADDENDUM 4	11/27/24
3	ADDENDUM	11/08/24
4	ADDENDUM 6	12/13/24
5	ADDENDUM 7	1/2/25
6		

PROJECT MANAGER TSL	
DRAWN BY MC, NA, PM	CHECKED BY DD, KF
DATE 2024.12.20	
PROJECT NUMBER 2883-01-RC22	
SHEET	

A903

PLAN CHECK REVISION 2

COMMUNITY CENTER & PARK PROJECT
PROJECT NO: 89-9411-88
BID NO.: 24/25 - CP1977

TO THE PURCHASING AGENT
City of Porterville
291 N. Main Street
Porterville, CA 93257

We, the undersigned bidder, having carefully examined the location of hereinafter described work and the plans and project manual thereof, thereby propose to furnish, all in strict accordance with said plans and project manual, all the materials, labor and equipment necessary for the completion of this project for the price set forth in the following bid, to wit:

BASE BID					
Item	Description of Work	Qty	Unit	Unit Price (\$)	Amount (\$)
1	Mobilization & Demobilization	LUMP SUM		\$	\$
2	Dust Control & Project Site Maintenance Per Specifications (Strictly Enforced)	LUMP SUM		\$	\$
3	Furnish and implement Traffic Control Plan (Maintaining Traffic)	LUMP SUM		\$	\$
4	Perform Utility Potholing/Locating	LUMP SUM		\$	\$
5	Provide Demolition, Clearing, and Grubbing as necessary including removal of existing asphalt by milling. Asphalt millings delivered to City per Specifications. (On-site and Off-Site as required per plans.)	LUMP SUM		\$	\$
6	SWPPP, Stormwater Pollution Prevention Plan	LUMP SUM		\$	\$
7	Construction Notification Sign	LUMP SUM		\$	\$
8	Fugitive Dust Control Permit/s and/or Clearance				
9	Fill dirt and compaction testing per plans	LUMP SUM			
10	Construction of Community Center Per Plans & Specifications (including, but not limit to, utility connections)	LUMP SUM		\$	\$
11	Construction of Park per Plans & Specifications (including, but not limit to, landscape material, irrigation, park furniture, park equipment, and sport field/s). (Not including prefabricated structures)	LUMP SUM		\$	\$
12	Construction of Parking lot per plans & specifications	LUMP SUM		\$	\$

13	Provide and install all solar components and EV charger per plans and specifications (Specialty Trade)	LUMP SUM	\$	\$
14	Provide and install fire sprinklers and related systems per plans and specifications (Specialty Trade)	LUMP SUM	\$	\$
15	Provide and install splash pad per plans and specifications (Specialty Trade)	LUMP SUM	\$	\$
16	Provide and install pump track per plans and specifications (Specialty Trade)	LUMP SUM	\$	\$
17	Provide and install prefabricated structures for park. (Specialty Trade).	LUMP SUM	\$	\$
Bid Total				\$

Total amount of **BID is (in words):** _____

_____ Dollars and _____ Cents

(Amount to be shown in both words and figures. In case of discrepancy between words and figures, the words shall prevail.)

We, the undersigned, as bidder, declare that we have thoroughly examined all the Contract documents herein contained and that this proposal is made without collusion with any other person, firm or corporation.

And we agree, if this proposal is accepted, that we will contract with the City of Porterville in the form of the Articles of Agreement to provide all labor and materials and all other expenses of whatever nature necessary to comply with the drawings and Contract provisions contained herein or reasonably implied thereby or as necessary to complete the work in the manner and within the time specified and according to the requirements and to the reasonable satisfaction of the Engineer; to pay all charges of freight, taxes, transportation and hauling; to indemnify the City and the Engineer against any loss or damage arising from any act of the undersigned as Contractor; and that we will take in full payment therefore the sums as shown on the Bid Proposal and made a part hereof.

And we further agree, if this Proposal is accepted, to sign the Articles of Agreement and to furnish the required bonds of a surety satisfactory to the City within ten (10) calendar days from the date notified by the City Clerk of award of contract; and if the undersigned shall fail to contract as aforesaid, it shall be understood that he/she has abandoned the Contract, and that, therefore, this Proposal shall be null and void and the certified check or bond accompanying this Proposal becomes the property of the City.

The undersigned certifies that he/she has a valid license as Contractor in the State of California, the classification and number of which are _____. The license expiration date is _____. The representations made herein are made under penalty of perjury. Witness our hands this _____ day of _____, 20_____.

Signature of bidder, with business name, address and telephone number:

(1) _____
BIDDING FIRM

(2) _____
Corp, Individual, Partner, Other

(3) _____
Business Address

Area Code and Telephone Number

City, State and Zip Code

(4) _____
Signature of Authorized Person

Type/Print Authorized Person Name

(PLEASE SEE THE FOLLOWING INSTRUCTIONS REGARDING SIGNATURE)

- (1) If bidder is an individual, enter name here in style used in business; if a joint venture, exact names of entities joining in the venture; if a partnership, the correct trade style of partnership if a corporation, the exact name of the corporation under which it is incorporated.
- (2) If bidder is other than an individual, identify here its character, i.e. joint venture, partnership, corporation (including state of incorporation) etc. If bidder is an individual operating under a trade name, state "an individual dba" (trade name in full).
- (3) State on this line the address to which all communications and notices regarding the Bid proposal and any contract awarded hereunder are to be addressed.
- (4) If bidder is a joint venture, signature must be by one of the joint ventures and if one or both of the joint venture's is a partnership or a corporation each participating partnership must sign by a general partner, and each corporation by an authorized officer or employee; if a partnership, by a general partner; if a corporation, by an authorized officer or employee. The title of the person signing must appear after his signature. Where bidder is a partnership or a corporation, the names of all other general partners, or the names of the president and secretary of the corporation and their business addresses must be shown below:

_____	_____
_____	_____
_____	_____

NOTE: All signatures must be typewritten under written signature.

NOTE: All addresses must be complete with Street number, City and State.

Bidder's List of Subcontractor

As of March 1, 2015 Contractors (and sub-contractors) wishing to bid on public works contracts shall be registered with the State Division of Industrial Relations and certified to bid on Public Works contracts. Please register at: <https://www.dir.ca.gov/Public-Works/Contractor-Registration.html>

In accordance with Title 49, Section 26.11 of the Code of Federal Regulations, and Section 4104 of the Public Contract Code of the State of California, as amended, the following information is required for each sub-contractor who will perform work amounting to more than one half of one percent (0.5%) of the Total Base Bid or \$10,000 (whichever is greater). **Photocopy this form for additional firms.**

Subcontractor Name and Location	Line Item & Description	Subcontract Amount	Percentage of Bid Item Sub-contracted	Contractor License Number	DBE (Y/N)	DBE Cert Number	Annual Gross Receipts
				DIR Reg Number			
Name:							☐ <\$1 million
City, State:							☐ <\$5 million
							☐ <\$10 million
							☐ <\$15 million
							Age of Firm: ____ yrs.
Name:							☐ <\$1 million
City, State:							☐ <\$5 million
							☐ <\$10 million
							☐ <\$15 million
							Age of Firm: ____ yrs.
Name:							☐ <\$1 million
City, State:							☐ <\$5 million
							☐ <\$10 million
							☐ <\$15 million
							Age of Firm: ____ yrs.
Name:							☐ <\$1 million
City, State:							☐ <\$5 million
							☐ <\$10 million
							☐ <\$15 million
							Age of Firm: ____ yrs.
Name:							☐ <\$1 million
City, State:							☐ <\$5 million
							☐ <\$10 million
							☐ <\$15 million
							Age of Firm: ____ yrs.
Name:							☐ <\$1 million
City, State:							☐ <\$5 million
							☐ <\$10 million
							☐ <\$15 million
							Age of Firm: ____ yrs.
Name:							☐ <\$1 million
City, State:							☐ <\$5 million
							☐ <\$10 million
							☐ <\$15 million
							Age of Firm: ____ yrs.