

ADDENDUM NO. 2

**MAMMOTH YOSEMITE AIRPORT
MAMMOTH LAKES, MONO COUNTY, CALIFORNIA**

**MULTIPURPOSE BUILDING –PHASE 2
AIP NO. 3-06-0146-____-2026**

DESIGN ENGINEER: Brandley Engineering, Inc.
6125 King Road, Suite 201
Loomis, California 95650
Telephone - (916) 652-4725
FAX - (916) 652-9029

BID OPENING: Tuesday, July 14, 2026, at 3:00 p.m.

This Addendum No. 1 includes the following:

- Replace Plan Sheets P04-001A, A20-01, A42-01, A50-01, A50-03, E10-01

PLANS

Item 1-1 *Sheet No. P04-001A*

Delete Sheet No. P04-001A.

Replace with attached Sheet No. P04-001A, Addendum No. 2

Item 1-2 *Sheet No. A20-01*

Delete Sheet No. A20-01.

Replace with attached Sheet No. A20-01, Addendum No. 2

Item 1-3 *Sheet No. A42-01*

Delete Sheet No. A42-01.

Replace with attached Sheet No. A42-01, Addendum No. 2

Item 1-4 *Sheet No. A50-01*

Delete Sheet No. A50-01.

Replace with attached Sheet No. A50-01, Addendum No. 2

Item 1-5 *Sheet No. A50-03*

Delete Sheet No. A50-03.

Replace with attached Sheet No. A50-03, Addendum No. 2

Item 1-6 *Sheet No. E10-01*

Delete Sheet No. E10-01.

Replace with attached Sheet No. E10-01, Addendum No. 2

*** END OF ADDENDUM NO. 2 ***

PLUMBING FIXTURE SCHEDULE		
TAG	MANUFACTURER	REMARKS AND SPECIFICATIONS
EW-1	GUARDIAN EQUIPMENT	MODEL HG1540 SELF-CONTAINED PORTABLE EYEWASH STATION, 16 GALLON CAPACITY WITH WALL MOUNT BRACKET.
FD-1	J.R. SMITH	FLOOR DRAIN MODEL: 2005Y-A, DUCO CAST IRON BODY WITH FLASHING COLLAR, ADJUSTABLE STRAINER AND ROUND TOP.
WDO-1	J.R. SMITH	WALL DRAIN OUT, MODEL 4420, 1/2" PER THREADED LUG WITH ROUND COVER.

3

PLUMBING FIXTURE CONNECTION SIZE SCHEDULE						
TAG	FIXTURE TYPE	LINE SIZES				
		WASTE	TRAP	VENT	COLD	HOT
S-1	LAUNDRY SINK	2"	1/2"	1/2"	1/2"	1/2"
EW-1	EYE WASH	1-1/2"	1-1/2"	1-1/2"	1/2"	1/2"
FD-1	FLOOR DRAIN	2"	1/2"	1/2"	-	-

DRAINAGE FIXTURE UNIT			
NO. FIXTURES	FIXTURE TYPE	FU/FIX	TOTAL F.U.
1	TRENCH DRAIN	2	2
1	FLOOR DRAIN	6	6
TOTAL			8

PIPING MATERIALS	
SANITARY SEWER PIPING, ABOVE GRADE	CAST IRON OR SCHEDULE 40 ABS/PVC
SANITARY SEWER AND VENT PIPING, BELOW GRADE	SCHEDULE 40 PVC
VENT PIPING, ABOVE GRADE	CAST IRON OR SCHEDULE 40 ABS/PVC
DOMESTIC HOT AND COLD WATER PIPING, ABOVE GRADE	RIGID COPPER TYPE L
DOMESTIC HOT AND COLD WATER PIPING BELOW GRADE	SCHEDULE 40 PVC
INDIRECT WASTE PIPING	RIGID COPPER TYPE M

DATE	ISSUED FOR	REV
2026/05/28	PERMIT	1
2026/06/26	BID ADDENDUM 2	3

4

This drawing has been prepared solely for the use of MAMMOTH YOSEMITE AIRPORT and there are no representations of any kind made by

This drawing shall not be used for construction purposes until the seal appearing hereon is signed and dated by the Architect or Engineer

Project Component
Key Plan

Consultants
Survey:
Civil:
Architecture:
Structural: NORR
Electrical:
Interiors:
Landscape:

Seal(s)

NORR

NORR OFFICE ADDRESS
norr.com


Project Manager M. NOVAK	Drawn JL
Project Leader J. PRICE	Checked BMS

Client
MAMMOTH YOSEMITE AIRPORT


Project
MAMMOTH SRE BUILDING

MAMMOTH, CA
Drawing Title
PLUMBING SCHEDULES

Scale
Project No.
IN2024-0022
Drawing No.
P04-001A

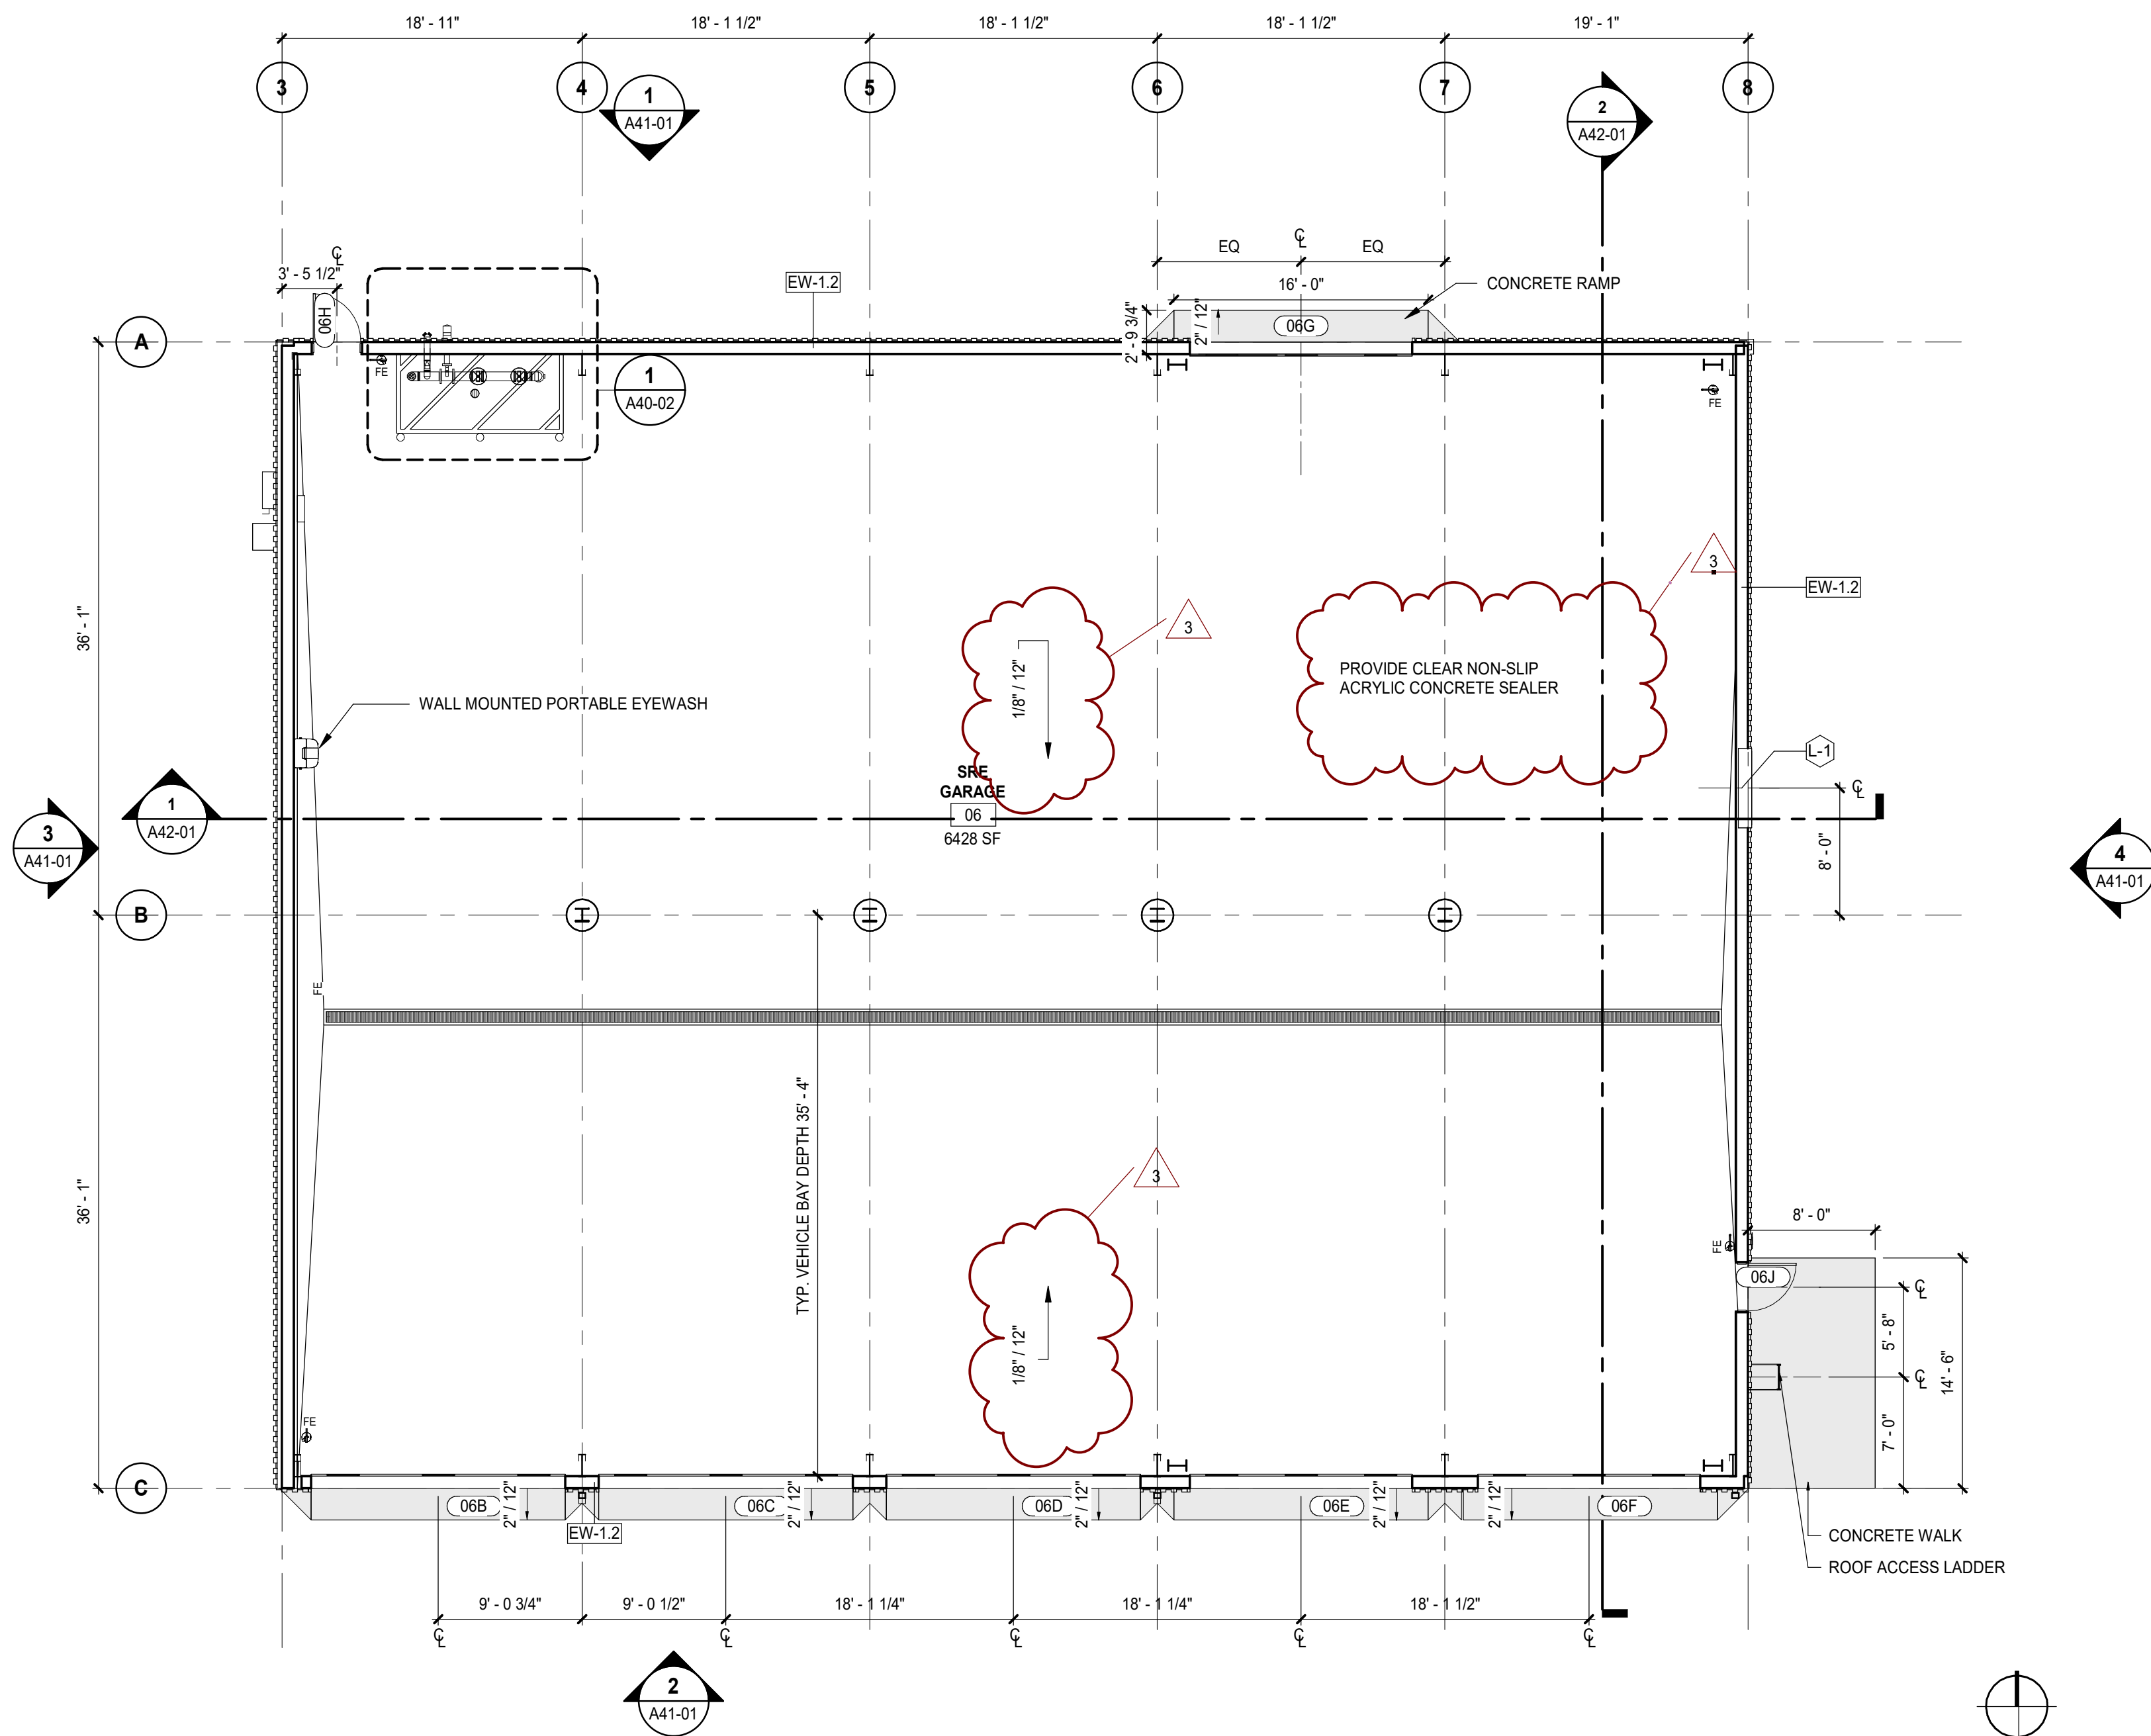

1 LEVEL 1 OVERALL FLOOR PLAN
SCALE: 1/8" = 1'-0"

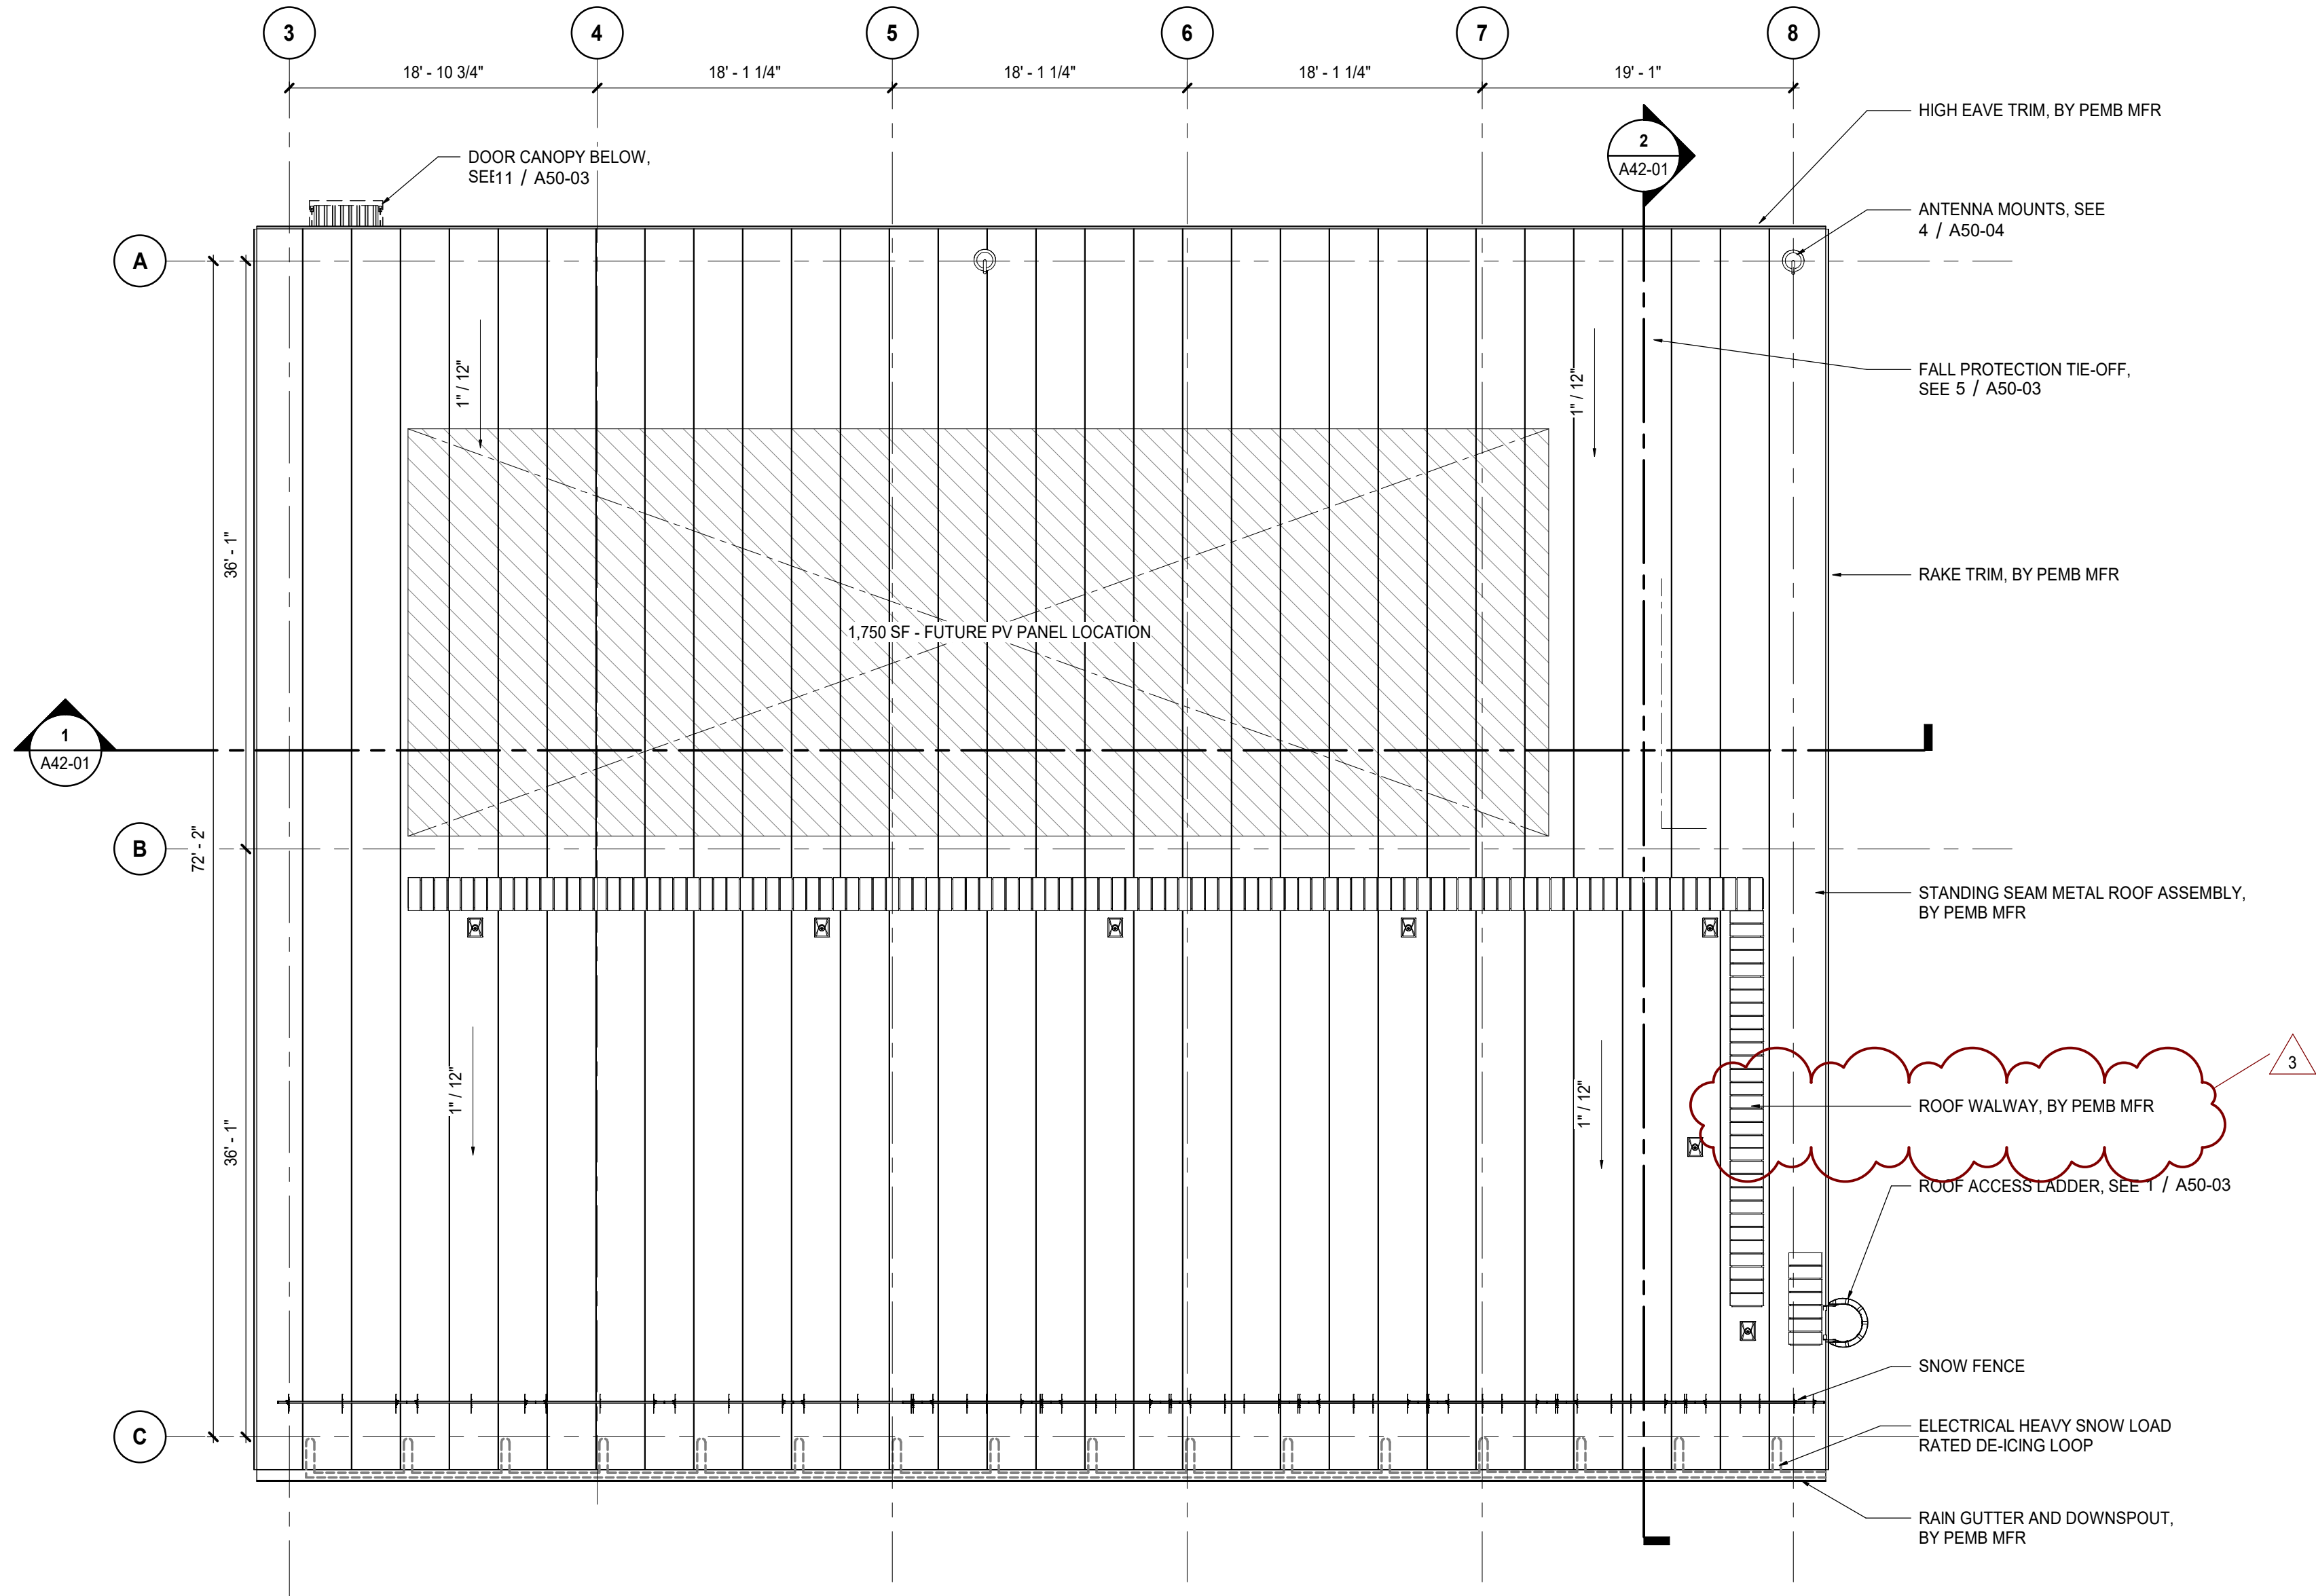

2 ROOF PLAN
SCALE: 1/8" = 1'-0"

DATE	ISSUED FOR	REV
06/26/2026	BID ADDENDUM 2	3

This drawing has been prepared solely for the use of MAMMOTH YOSEMITE AIRPORT and there are no representations of any kind made by NORR to any party with whom NORR has not entered into a contract.

This drawing shall not be used for construction purposes until the seal appearing hereon is signed and dated by the Architect or Engineer

Project Component

Key Plan

Consultants
Survey: Brandley Engineering
Civil: Kimley-Horn
Architecture: NORR
Structural: Bevier Structural Eng
Mechanical: NORR
Electrical: NORR
Interiors: NORR
Fire Sprinkler: Sacramento Engineering Consultants

Seal(s)



NORR

2020 I Street, Suite 220
Sacramento, CA, US 95811
norr.com

Project Manager	Drawn
Project Leader	Author
	Checked
	Checker

Client:
MAMMOTH YOSEMITE AIRPORT



Project:
MAMMOTH SRE BLUIDING

Drawing Title:
FLOOR PLANS

Scale:
1/8" = 1'-0"

Project No.
IN2024-0022

Drawing No.
A20-01

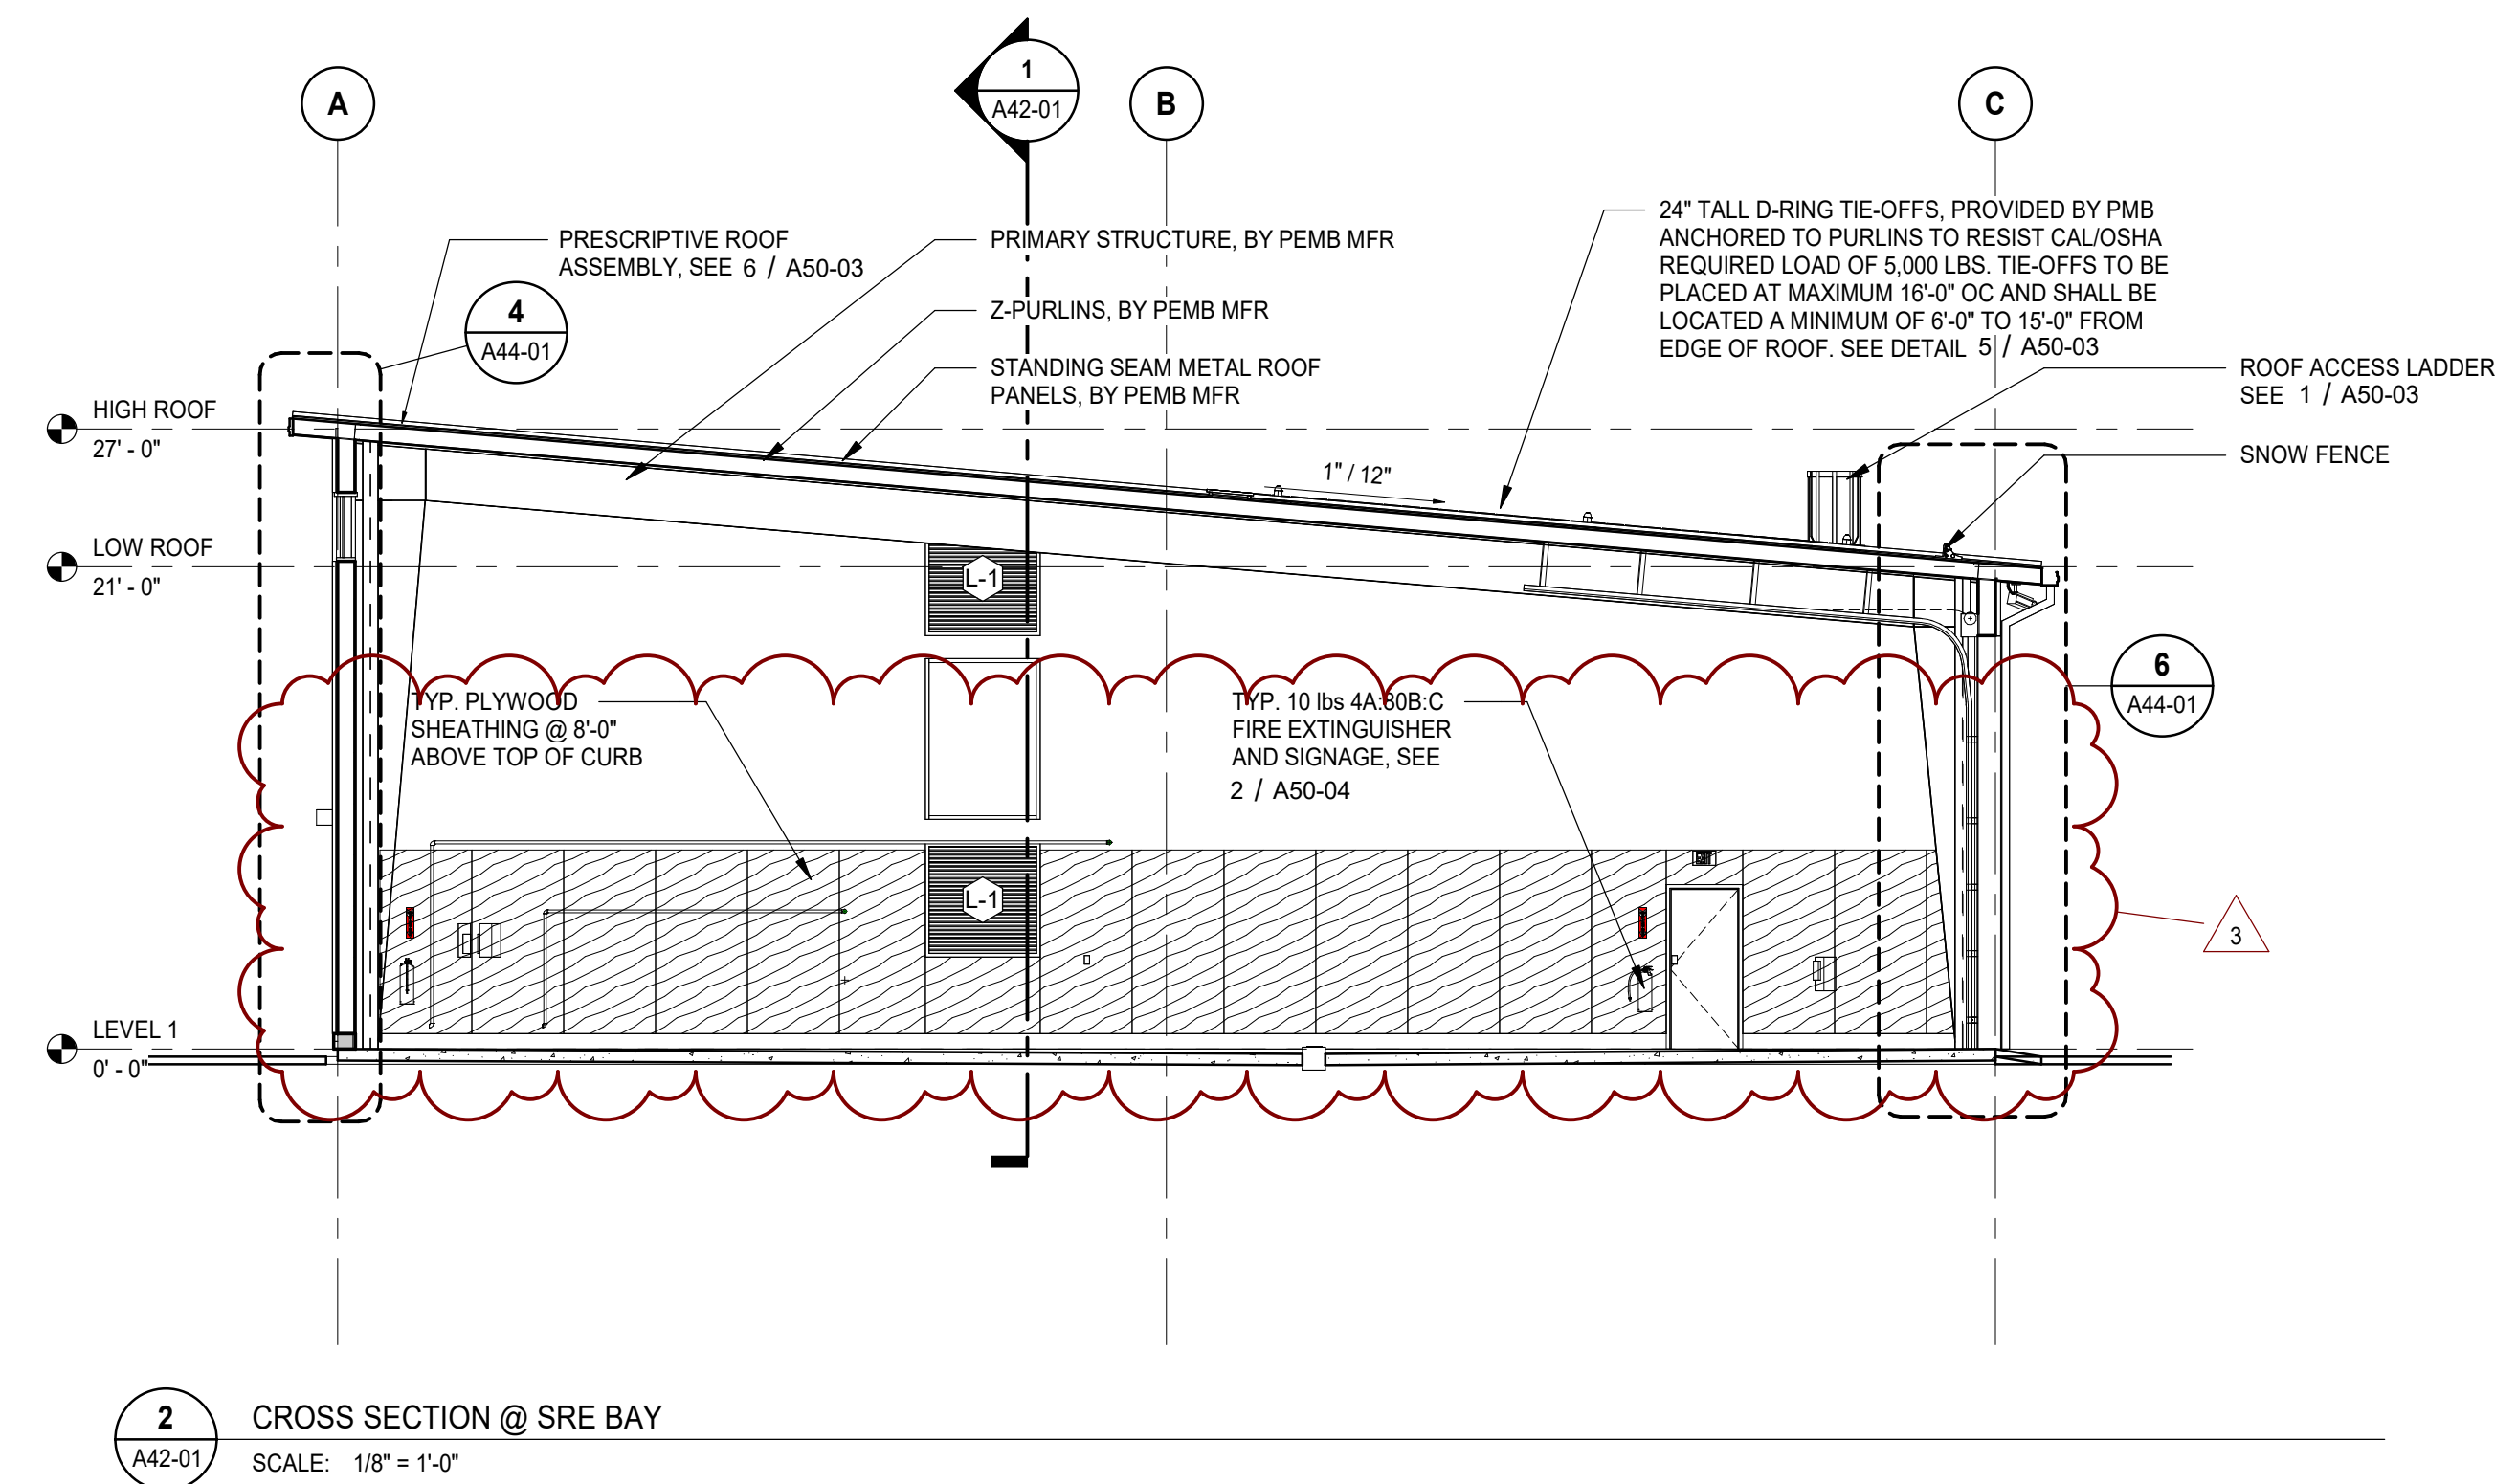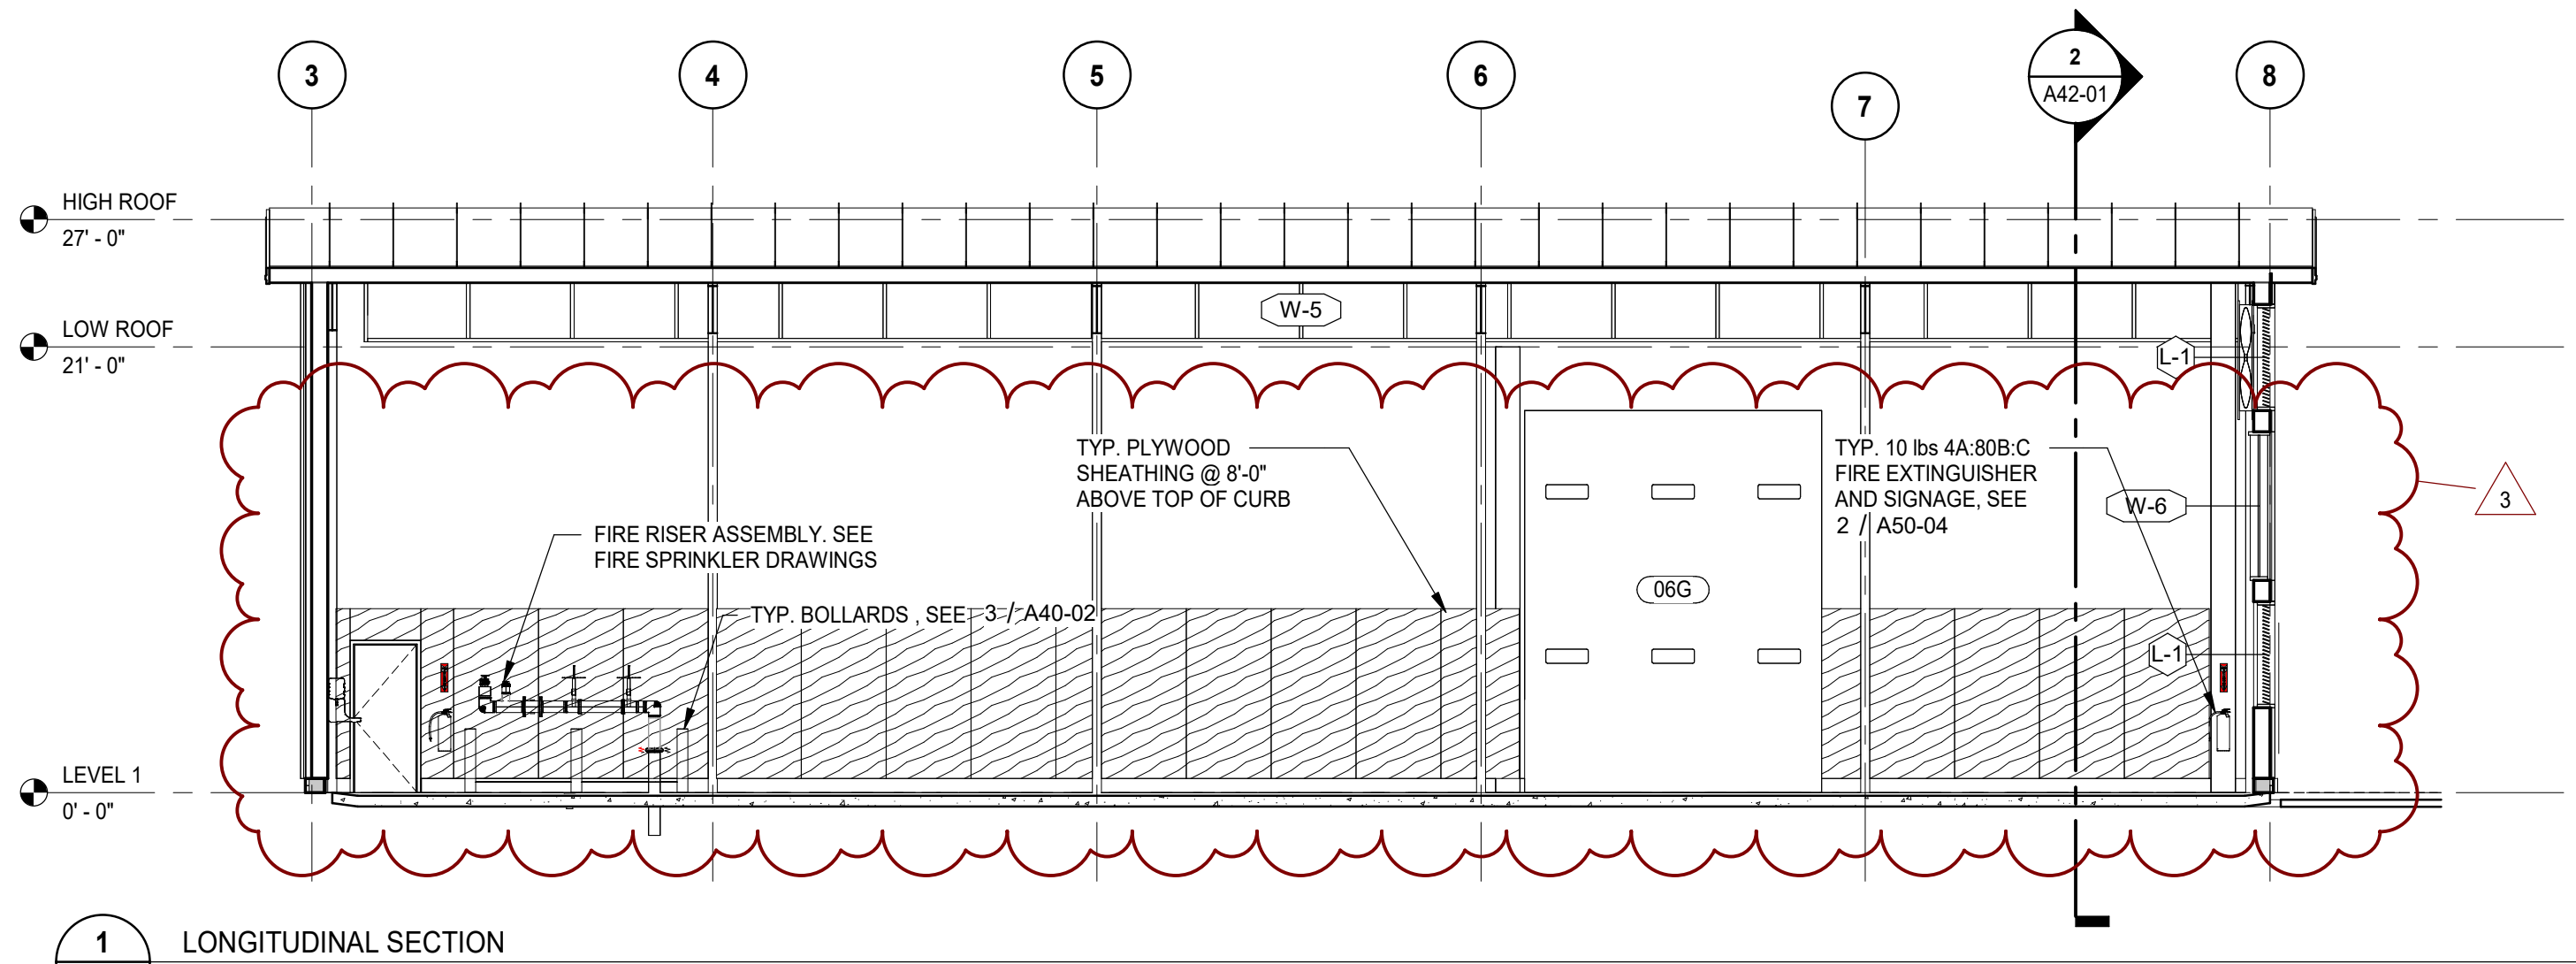

DATE	ISSUED FOR	REV
06/26/2024	BID ADDENDUM 2	3

This drawing has been prepared solely for the use of MAMMOTH YOSEMITE AIRPORT and there are no representations of any kind made by NORR to any party with whom NORR has not entered into a contract.

This drawing shall not be used for construction purposes until the seal appearing hereon is signed and dated by the Architect or Engineer

Project Component

Key Plan

Consultants
Survey: Brandley Engineering
Civil: Kimley-Horn
Architecture: NORR
Structural: Bevier Structural Eng
Mechanical: NORR
Electrical: NORR
Interiors: NORR
Fire Sprinkler: Sacramento Engineering Consultants

Seal(s)



NORR
2020 I Street, Suite 220
Sacramento, CA, US 95811
norr.com

Project Manager	Drawn
Project Leader	JON PRICE
	Checked
	MIKE NOVAK

Client
MAMMOTH YOSEMITE AIRPORT


Project
MAMMOTH SRE BLUIDING

MAMMOTH, CALIFORNIA
Drawing Title
OVERALL BUILDING SECTIONS


Scale
1/8" = 1'-0"

Project No.
IN2024-0022


Drawing No.
A42-01

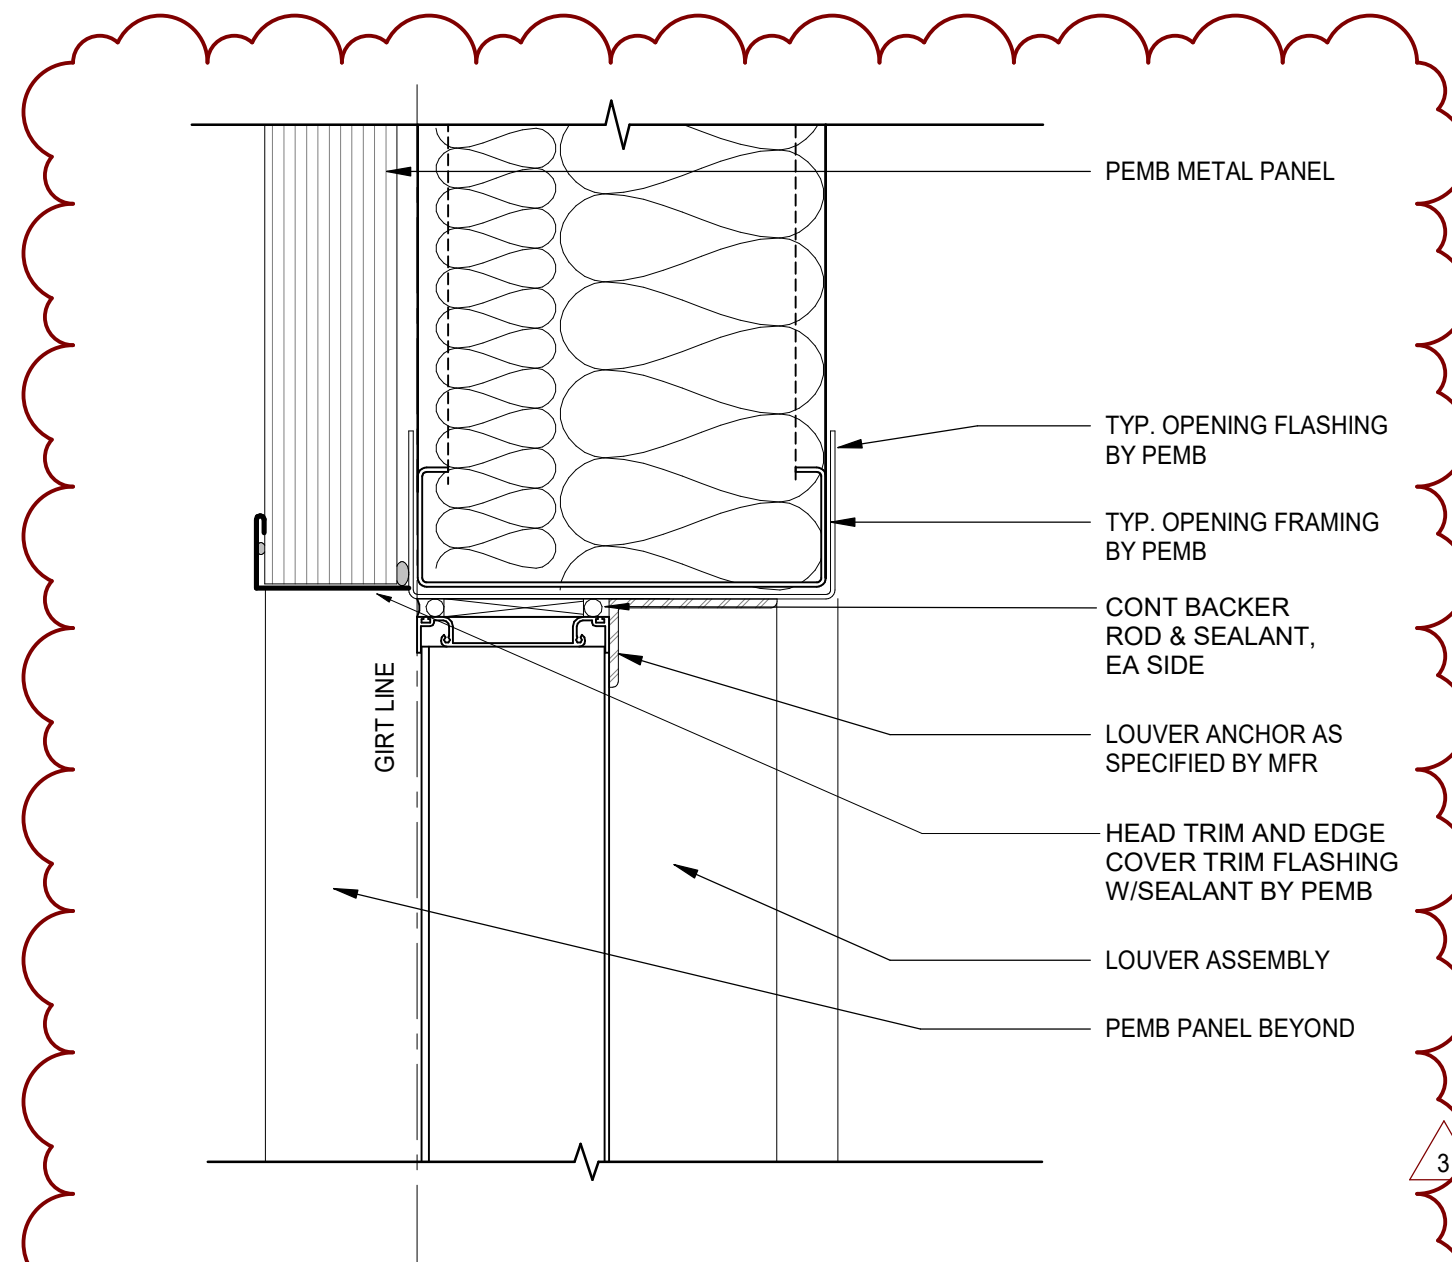


10 LOUVER JAMB
SCALE: 3" = 1'-0"

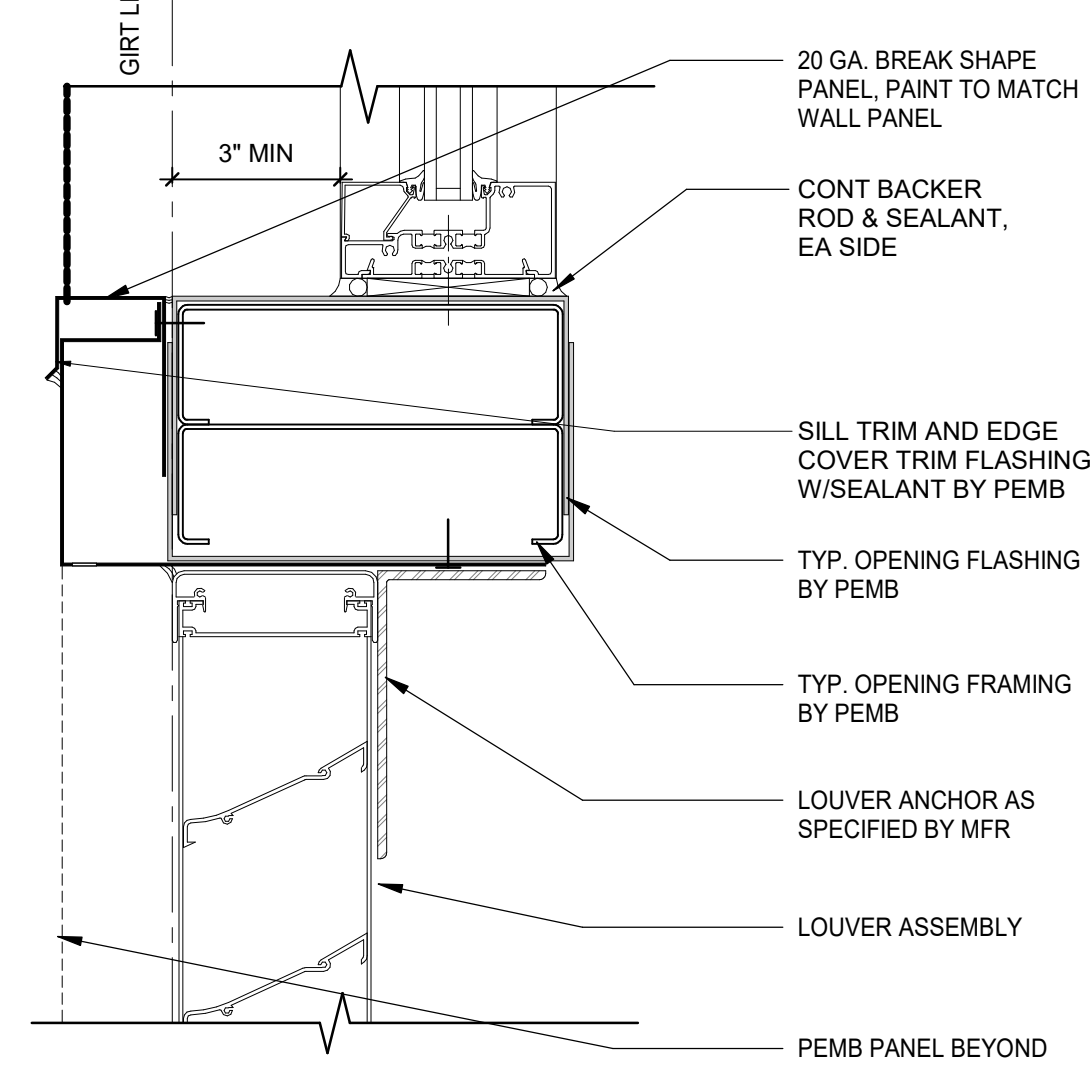


11 LOUVER HEAD -WINDOW SILL
SCALE: 3" = 1'-0"

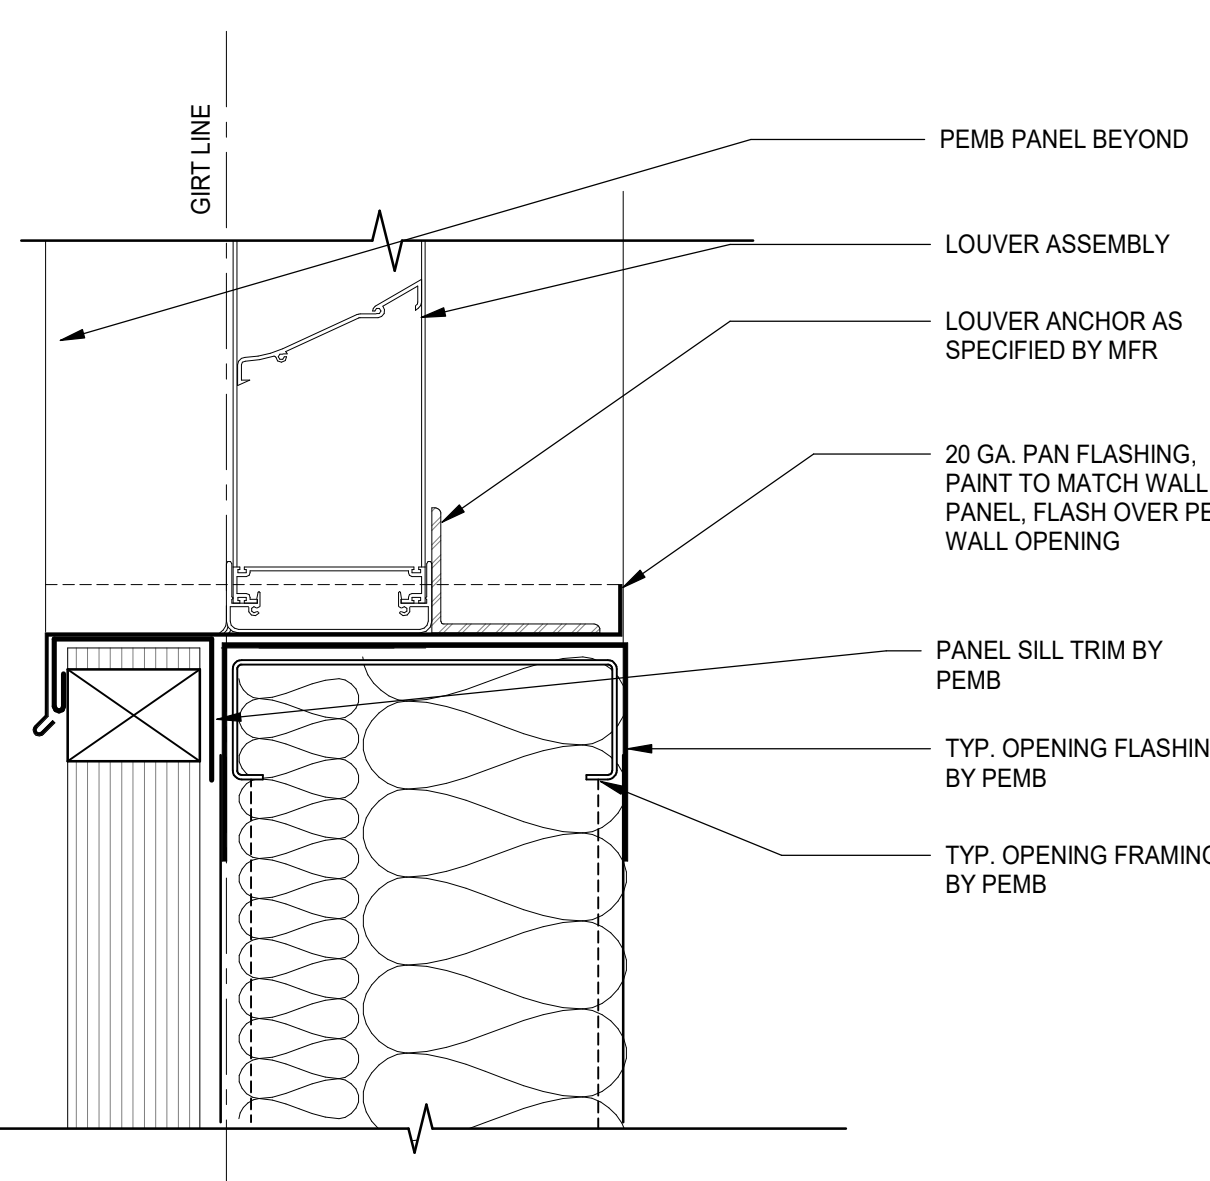


12 LOUVER SILL
SCALE: 3" = 1'-0"

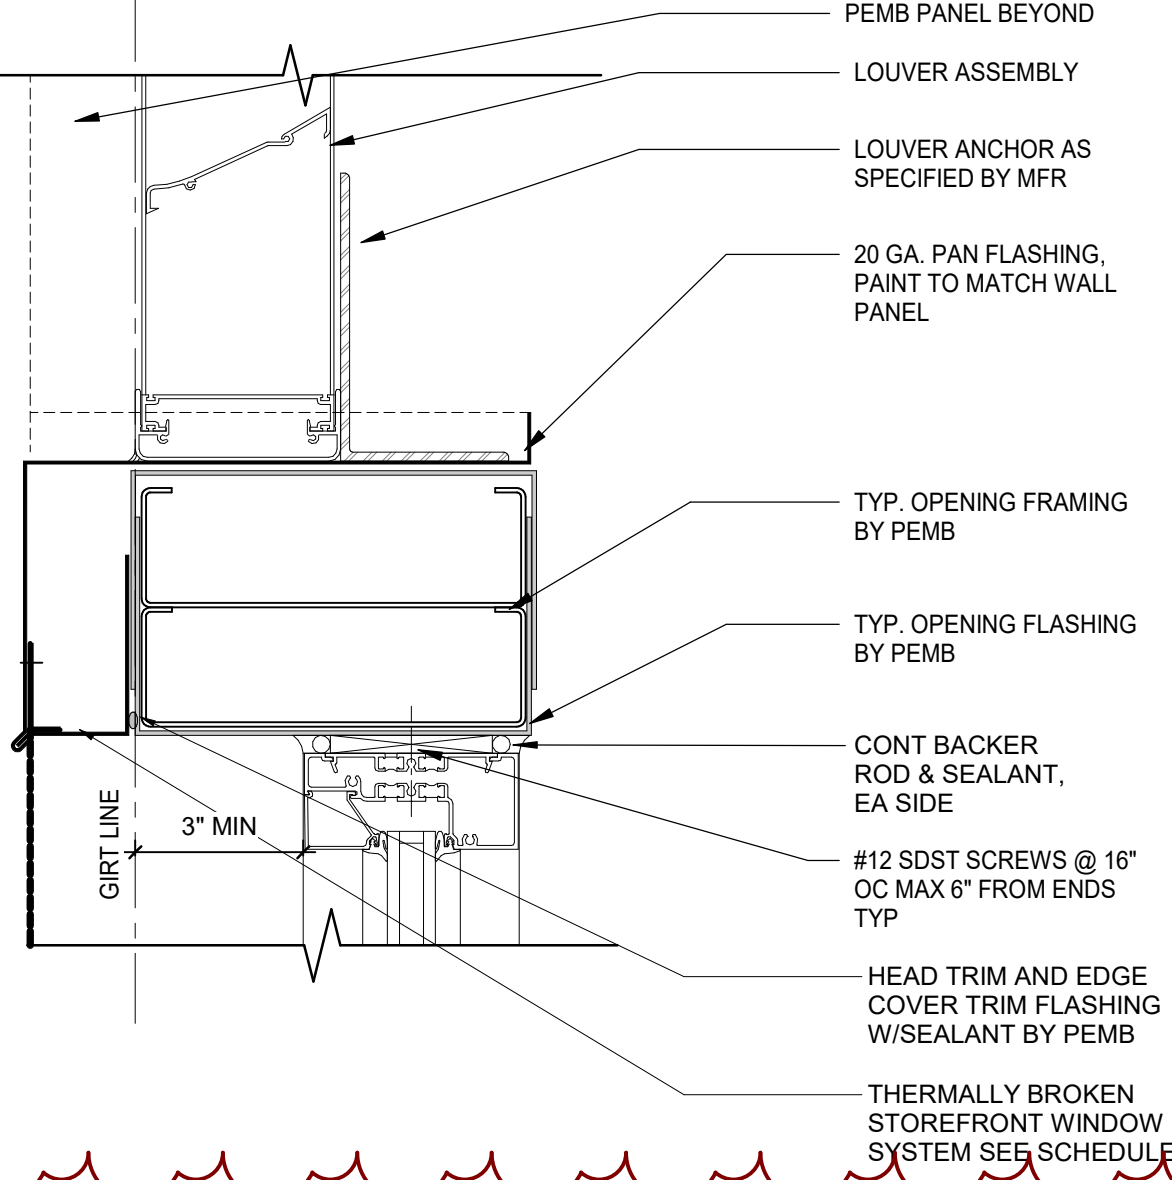


13 LOUVER SILL -WINDOW HEAD
SCALE: 3" = 1'-0"

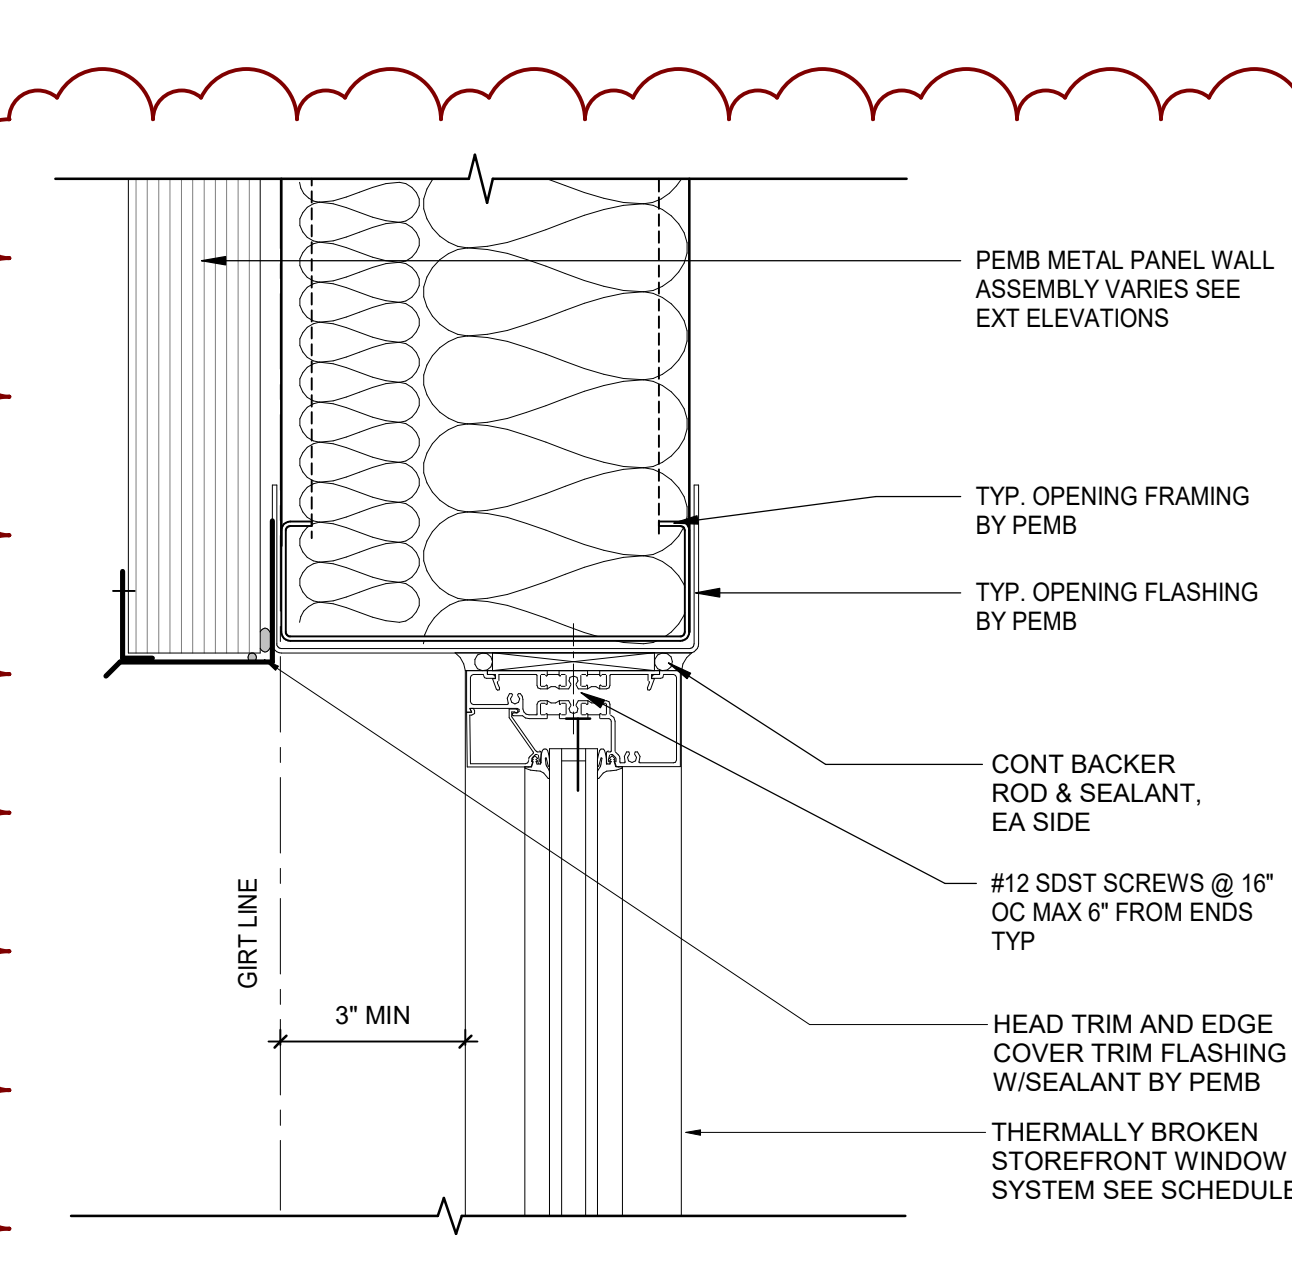


6 WINDOW HEAD
SCALE: 1 1/2" = 1'-0"

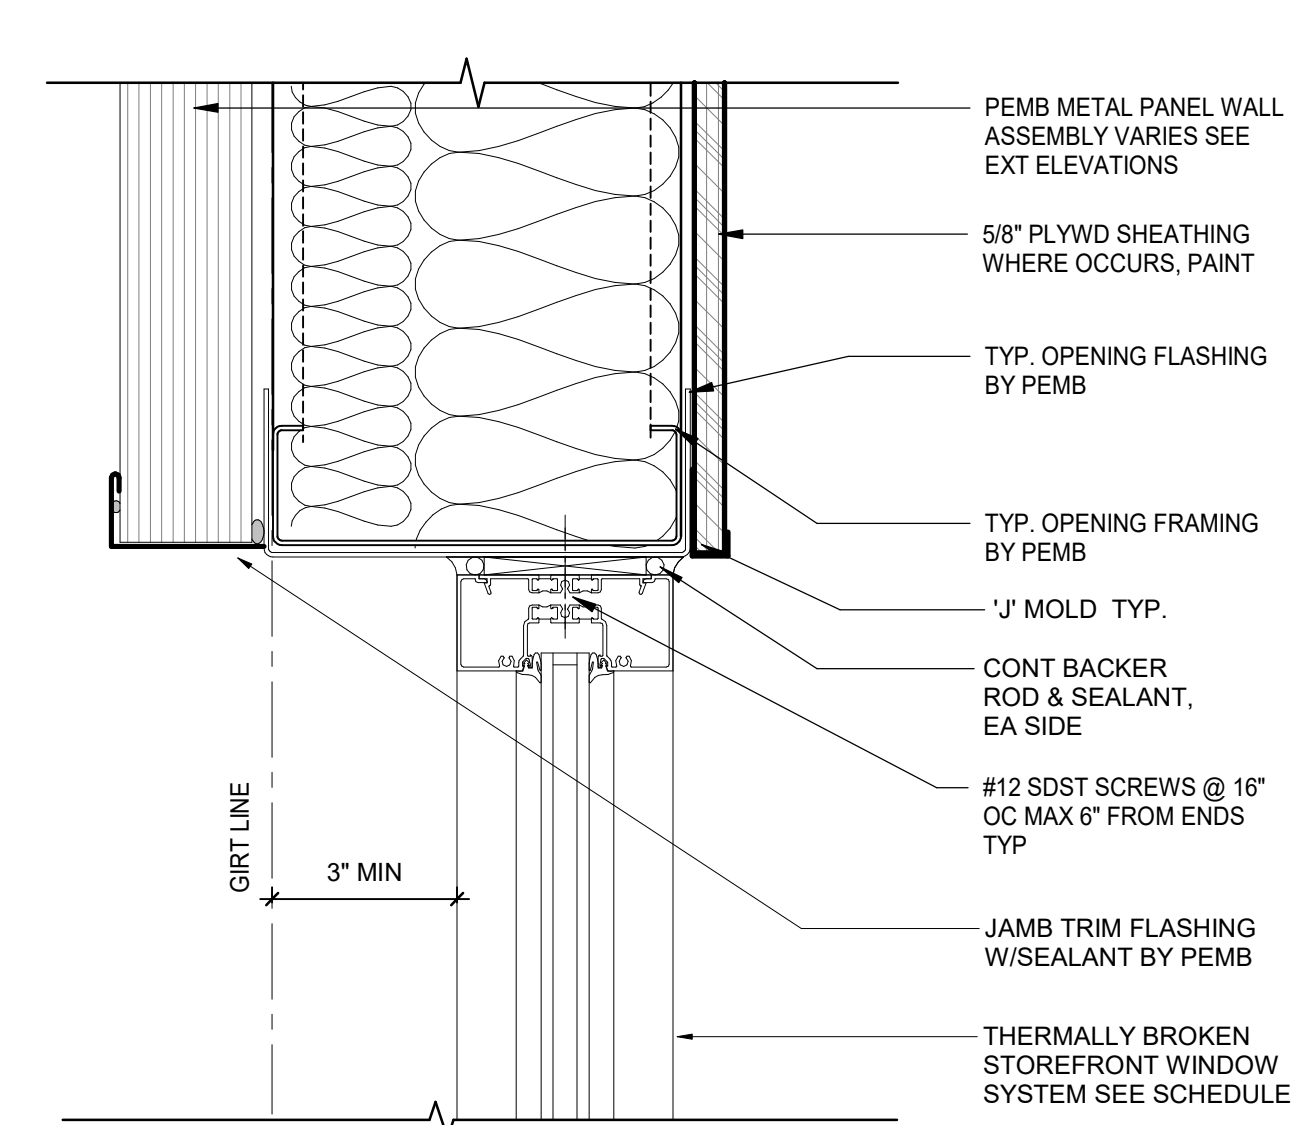


7 WINDOW JAMB
SCALE: 3" = 1'-0"

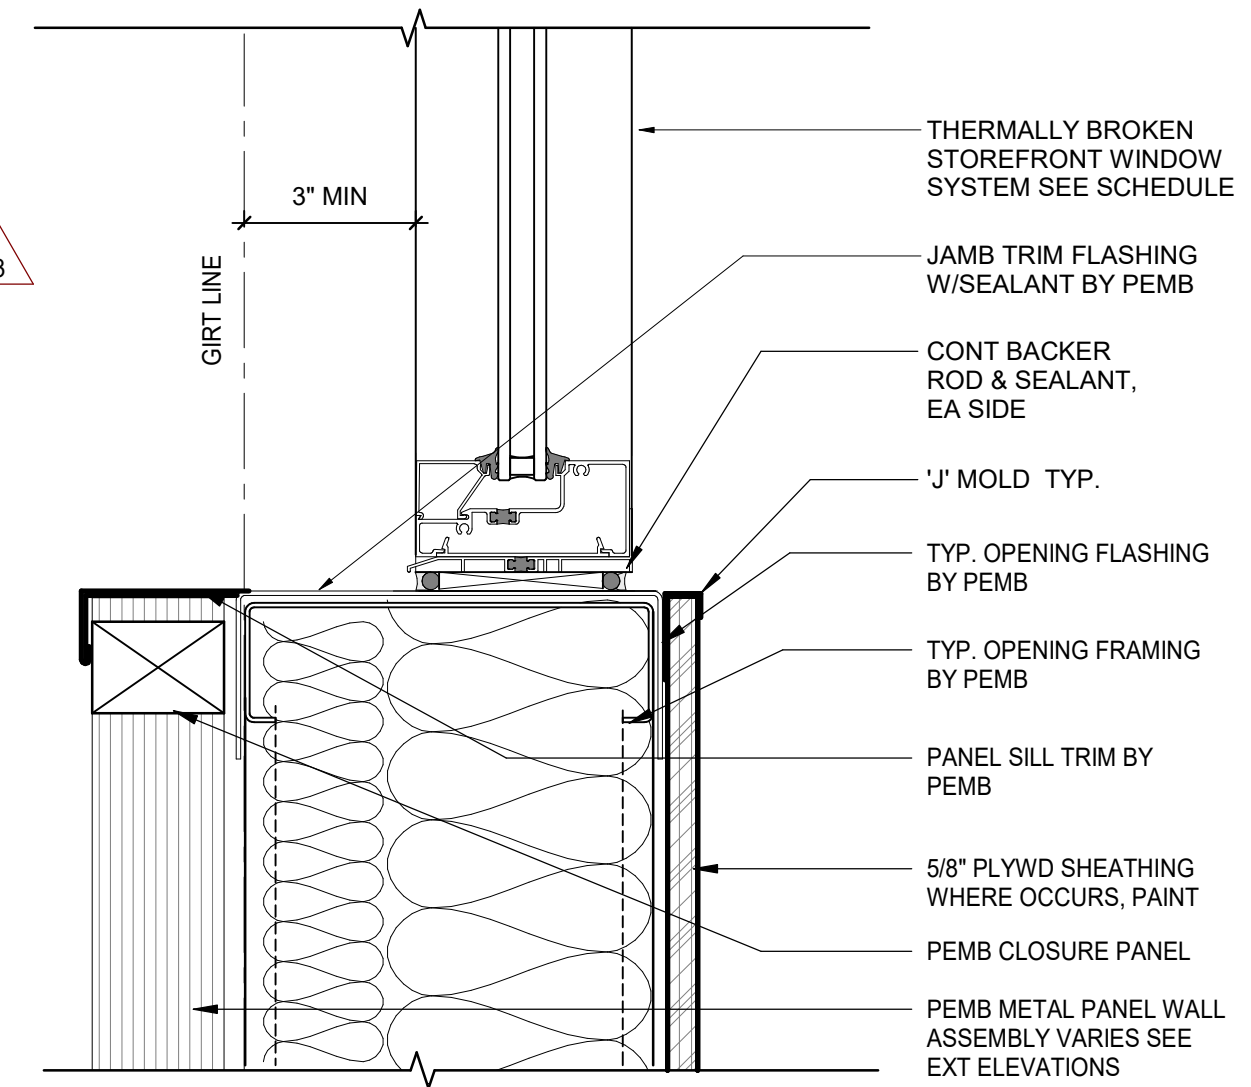


8 WINDOW SILL @ PEMB
SCALE: 3" = 1'-0"

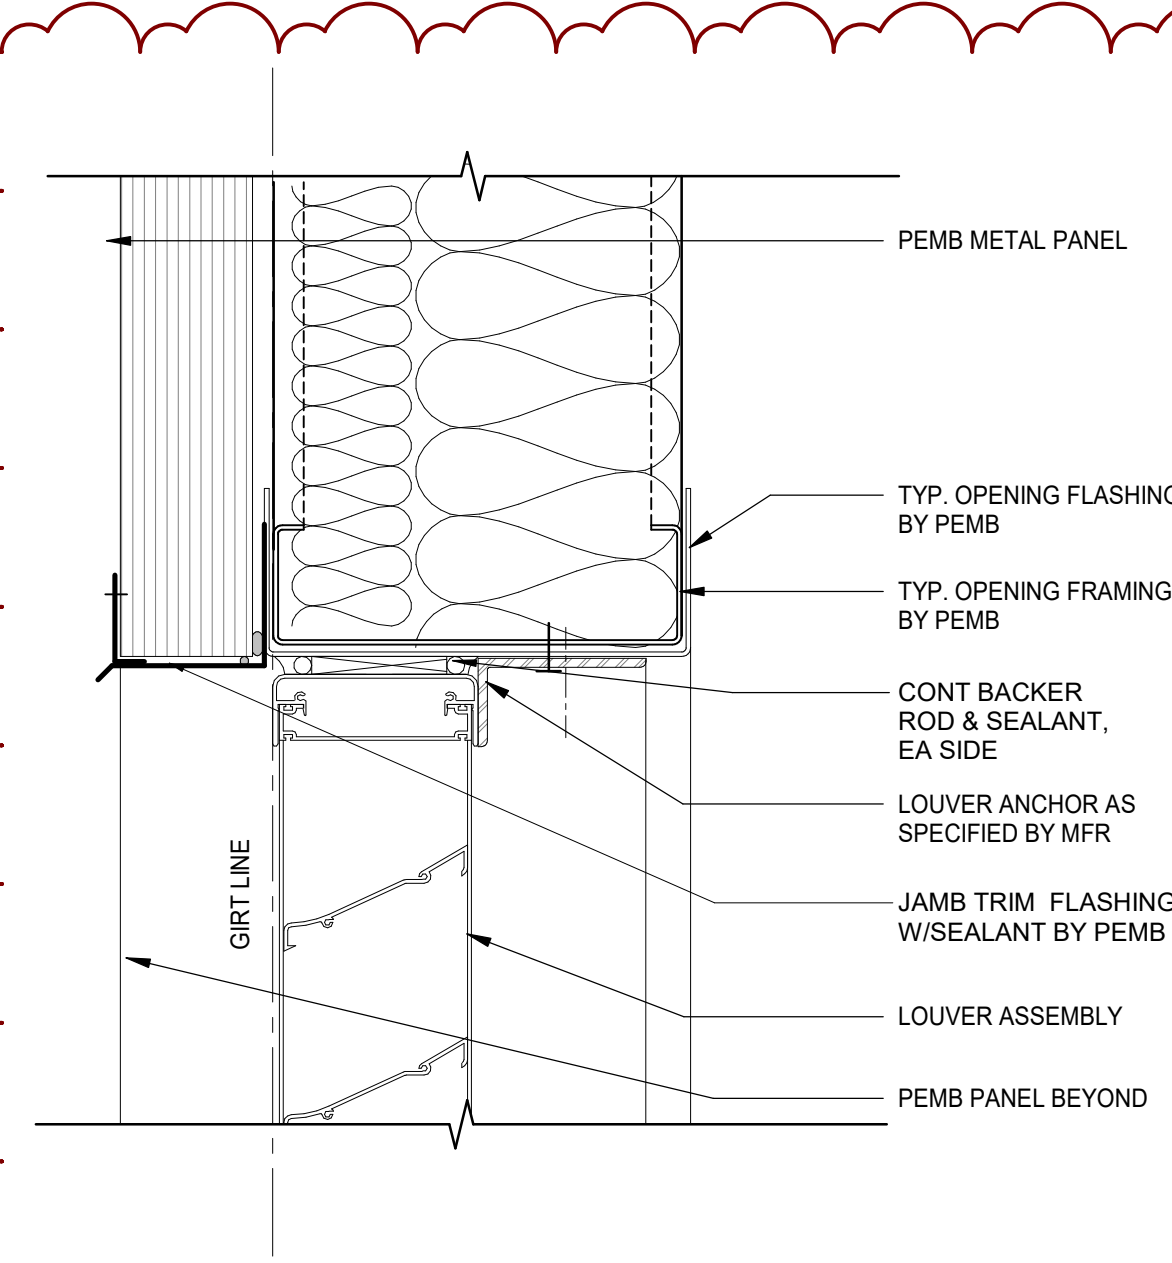


9 LOUVER HEAD
SCALE: 3" = 1'-0"

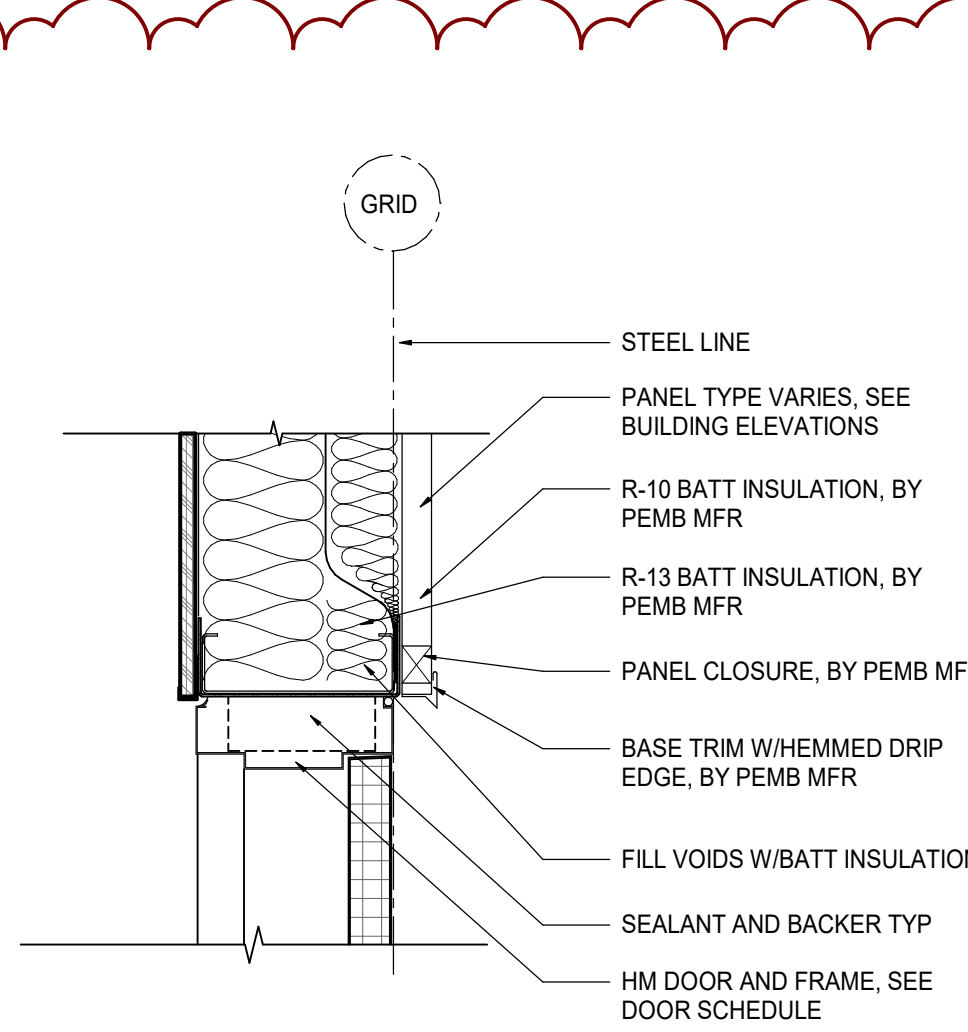


1 EXTERIOR DOOR HEAD
SCALE: 1 1/2" = 1'-0"

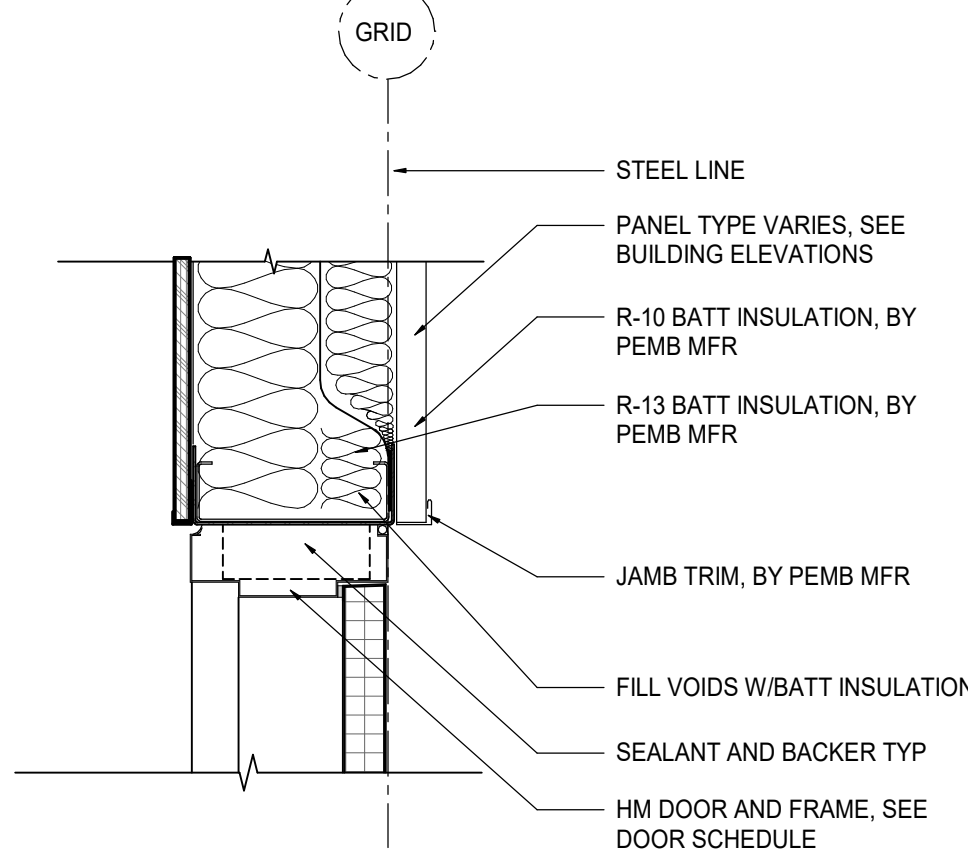

2 EXTERIOR DOOR JAMB
SCALE: 1 1/2" = 1'-0"

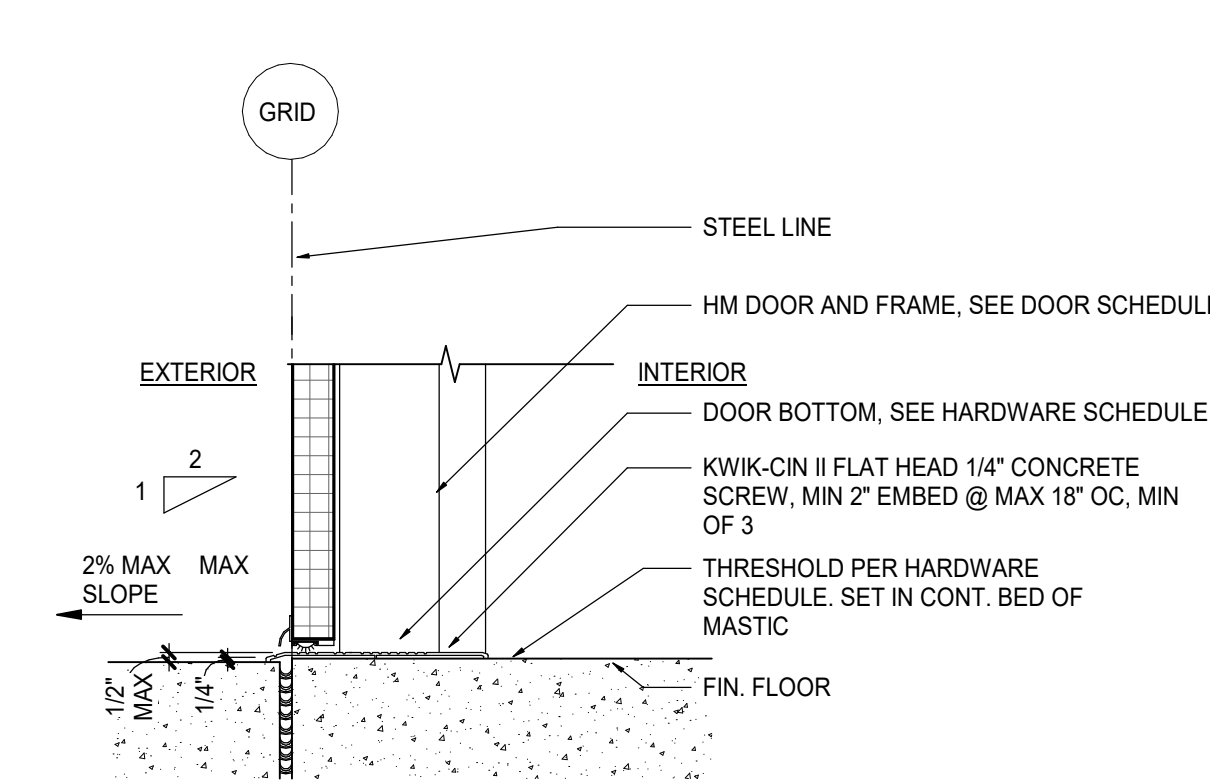

3 EXTERIOR DOOR THRESHOLD
SCALE: 1 1/2" = 1'-0"

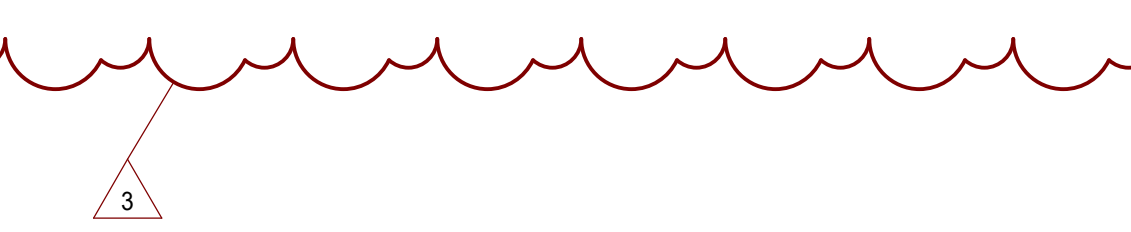

5 SILL PAN
SCALE: 6" = 1'-0"

DATE	ISSUED FOR	REV
06/26/2026	BID ADDENDUM 2	3

This drawing has been prepared solely for the use of MAMMOTH YOSEMITE AIRPORT and there are no representations of any kind made by NORR to any party with whom NORR has not entered into a contract.

This drawing shall not be used for construction purposes until the seal appearing hereon is signed and dated by the Architect or Engineer

Project Component

Key Plan

Consultants
Survey: Brandley Engineering
Civil: Kimley-Horn
Architecture: NORR
Structural: Bevier Structural Eng
Mechanical: NORR
Electrical: NORR
Interiors: NORR
Fire Sprinkler: Sacramento Engineering Consultants

Seal(s)



NORR

2020 I Street, Suite 220
Sacramento, CA, US 95811
norr.com

Project Manager: Drawn: JON PRICE
Project Leader: Checked: MIKE NOVAK

Client: **MAMMOTH YOSEMITE AIRPORT**


Project: **MAMMOTH SRE BLUIDING**

MAMMOTH, CALIFORNIA
Drawing Title: **DOOR AND WINDOW DETAILS**


Scale: As indicated

Project No.: IN2024-0022


Drawing No.: **A50-01**

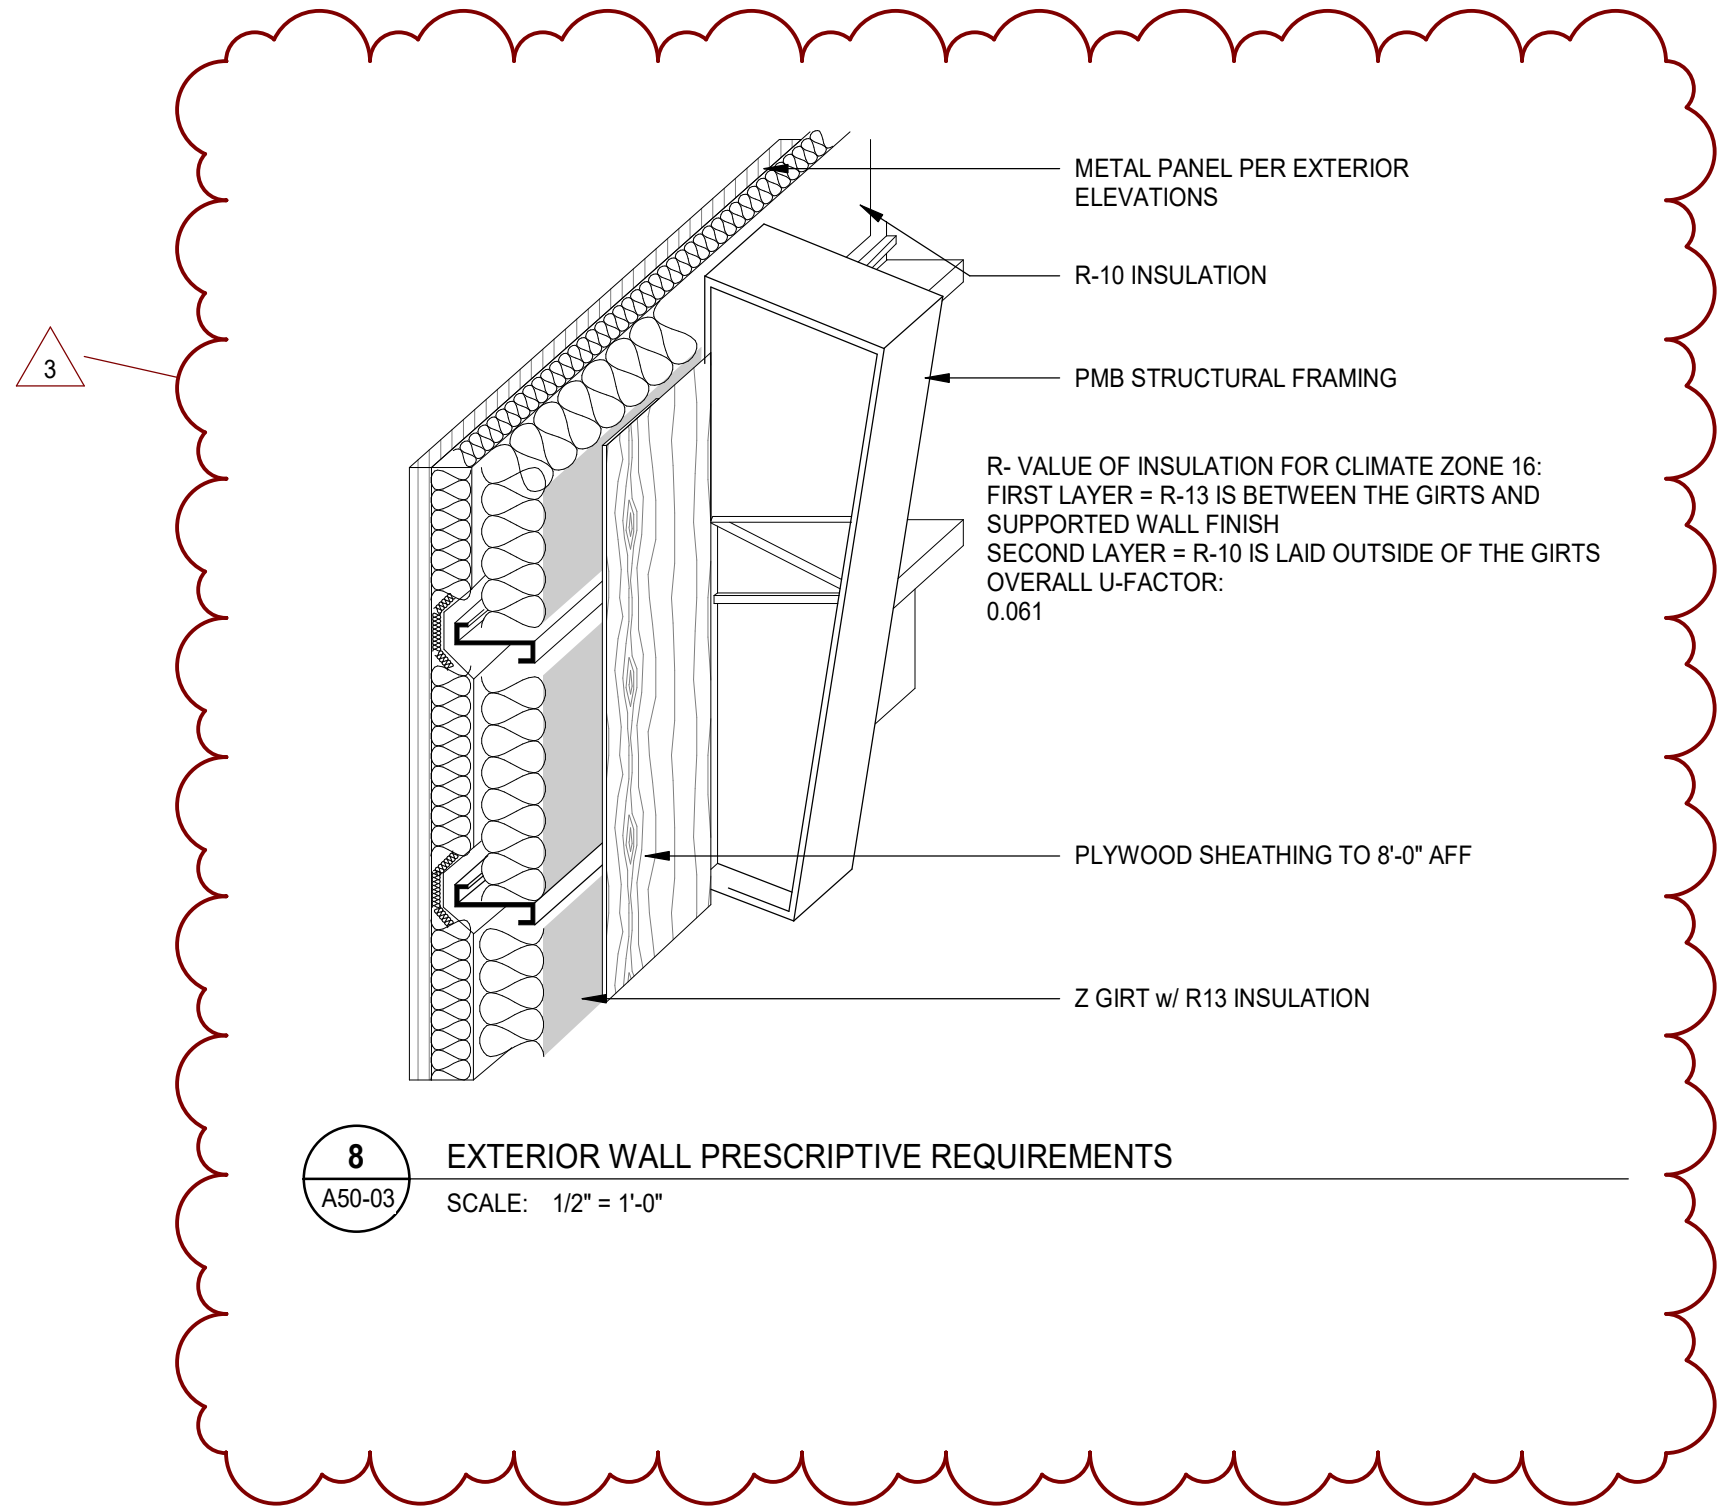


8
A50-03
EXTERIOR WALL PRESCRIPTIVE REQUIREMENTS
SCALE: 1/2" = 1'-0"

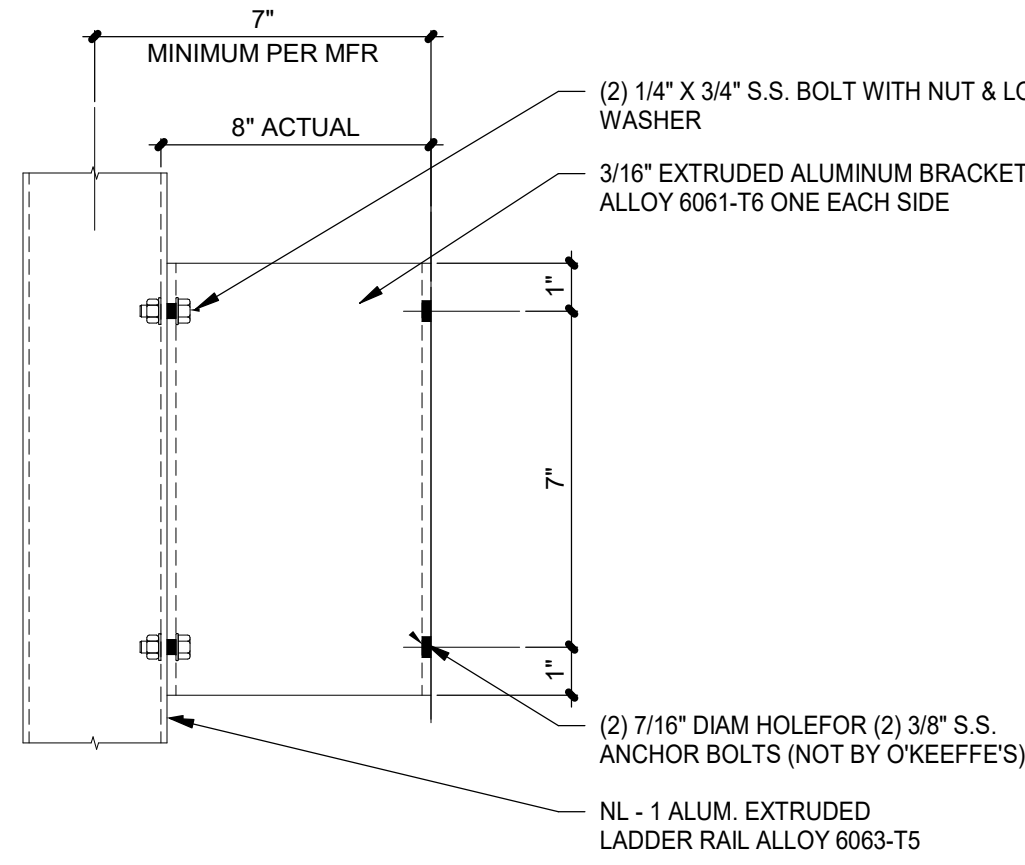


4
A50-03
LADDER BRACKET SIDE VIEW
SCALE: 3" = 1'-0"

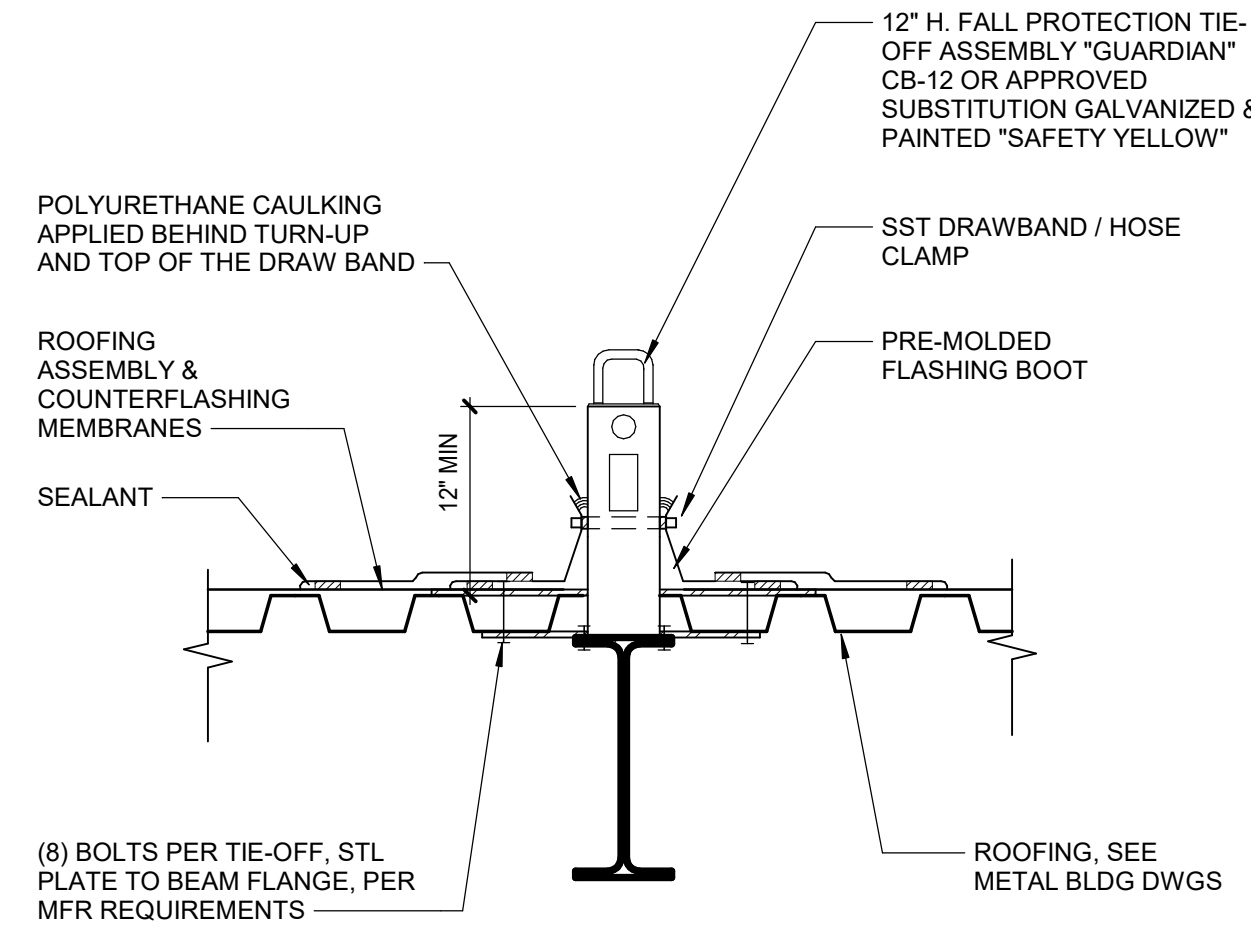


5
A50-03
FALL PROTECTION TIE OFF ASSEMBLY
SCALE: 1 1/2" = 1'-0"

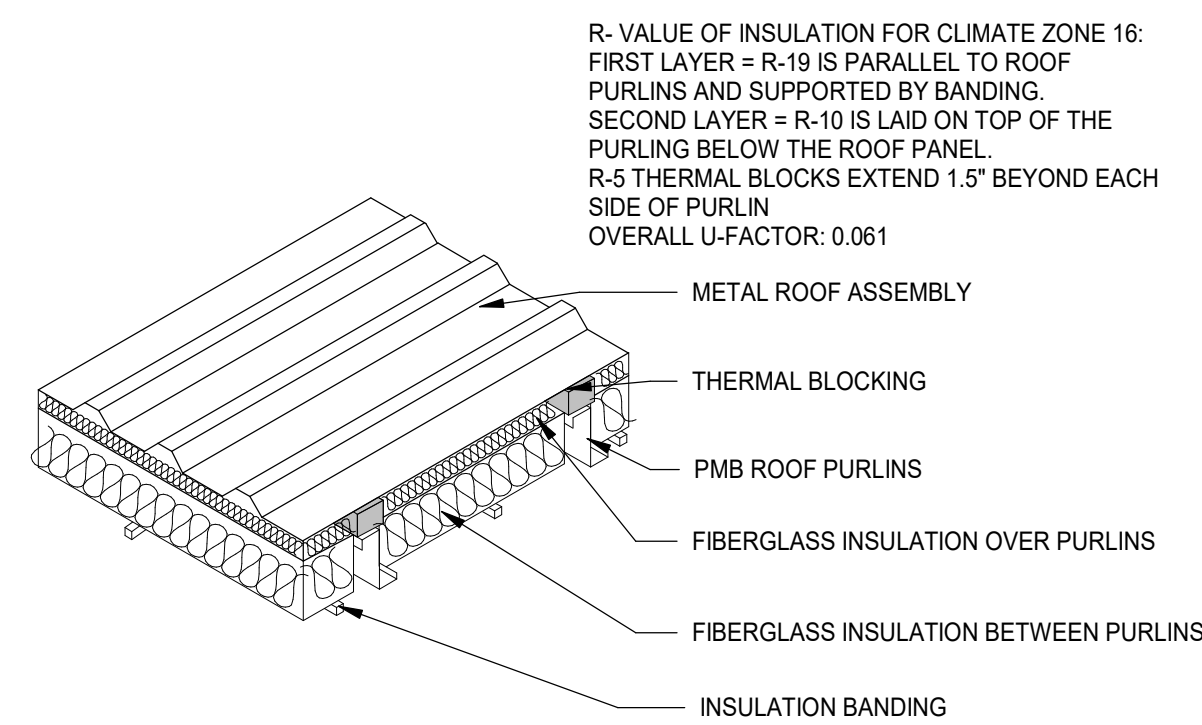


6
A50-03
ROOF PRESCRIPTIVE ENVELOP REQUIREMENTS
SCALE: 1/2" = 1'-0"

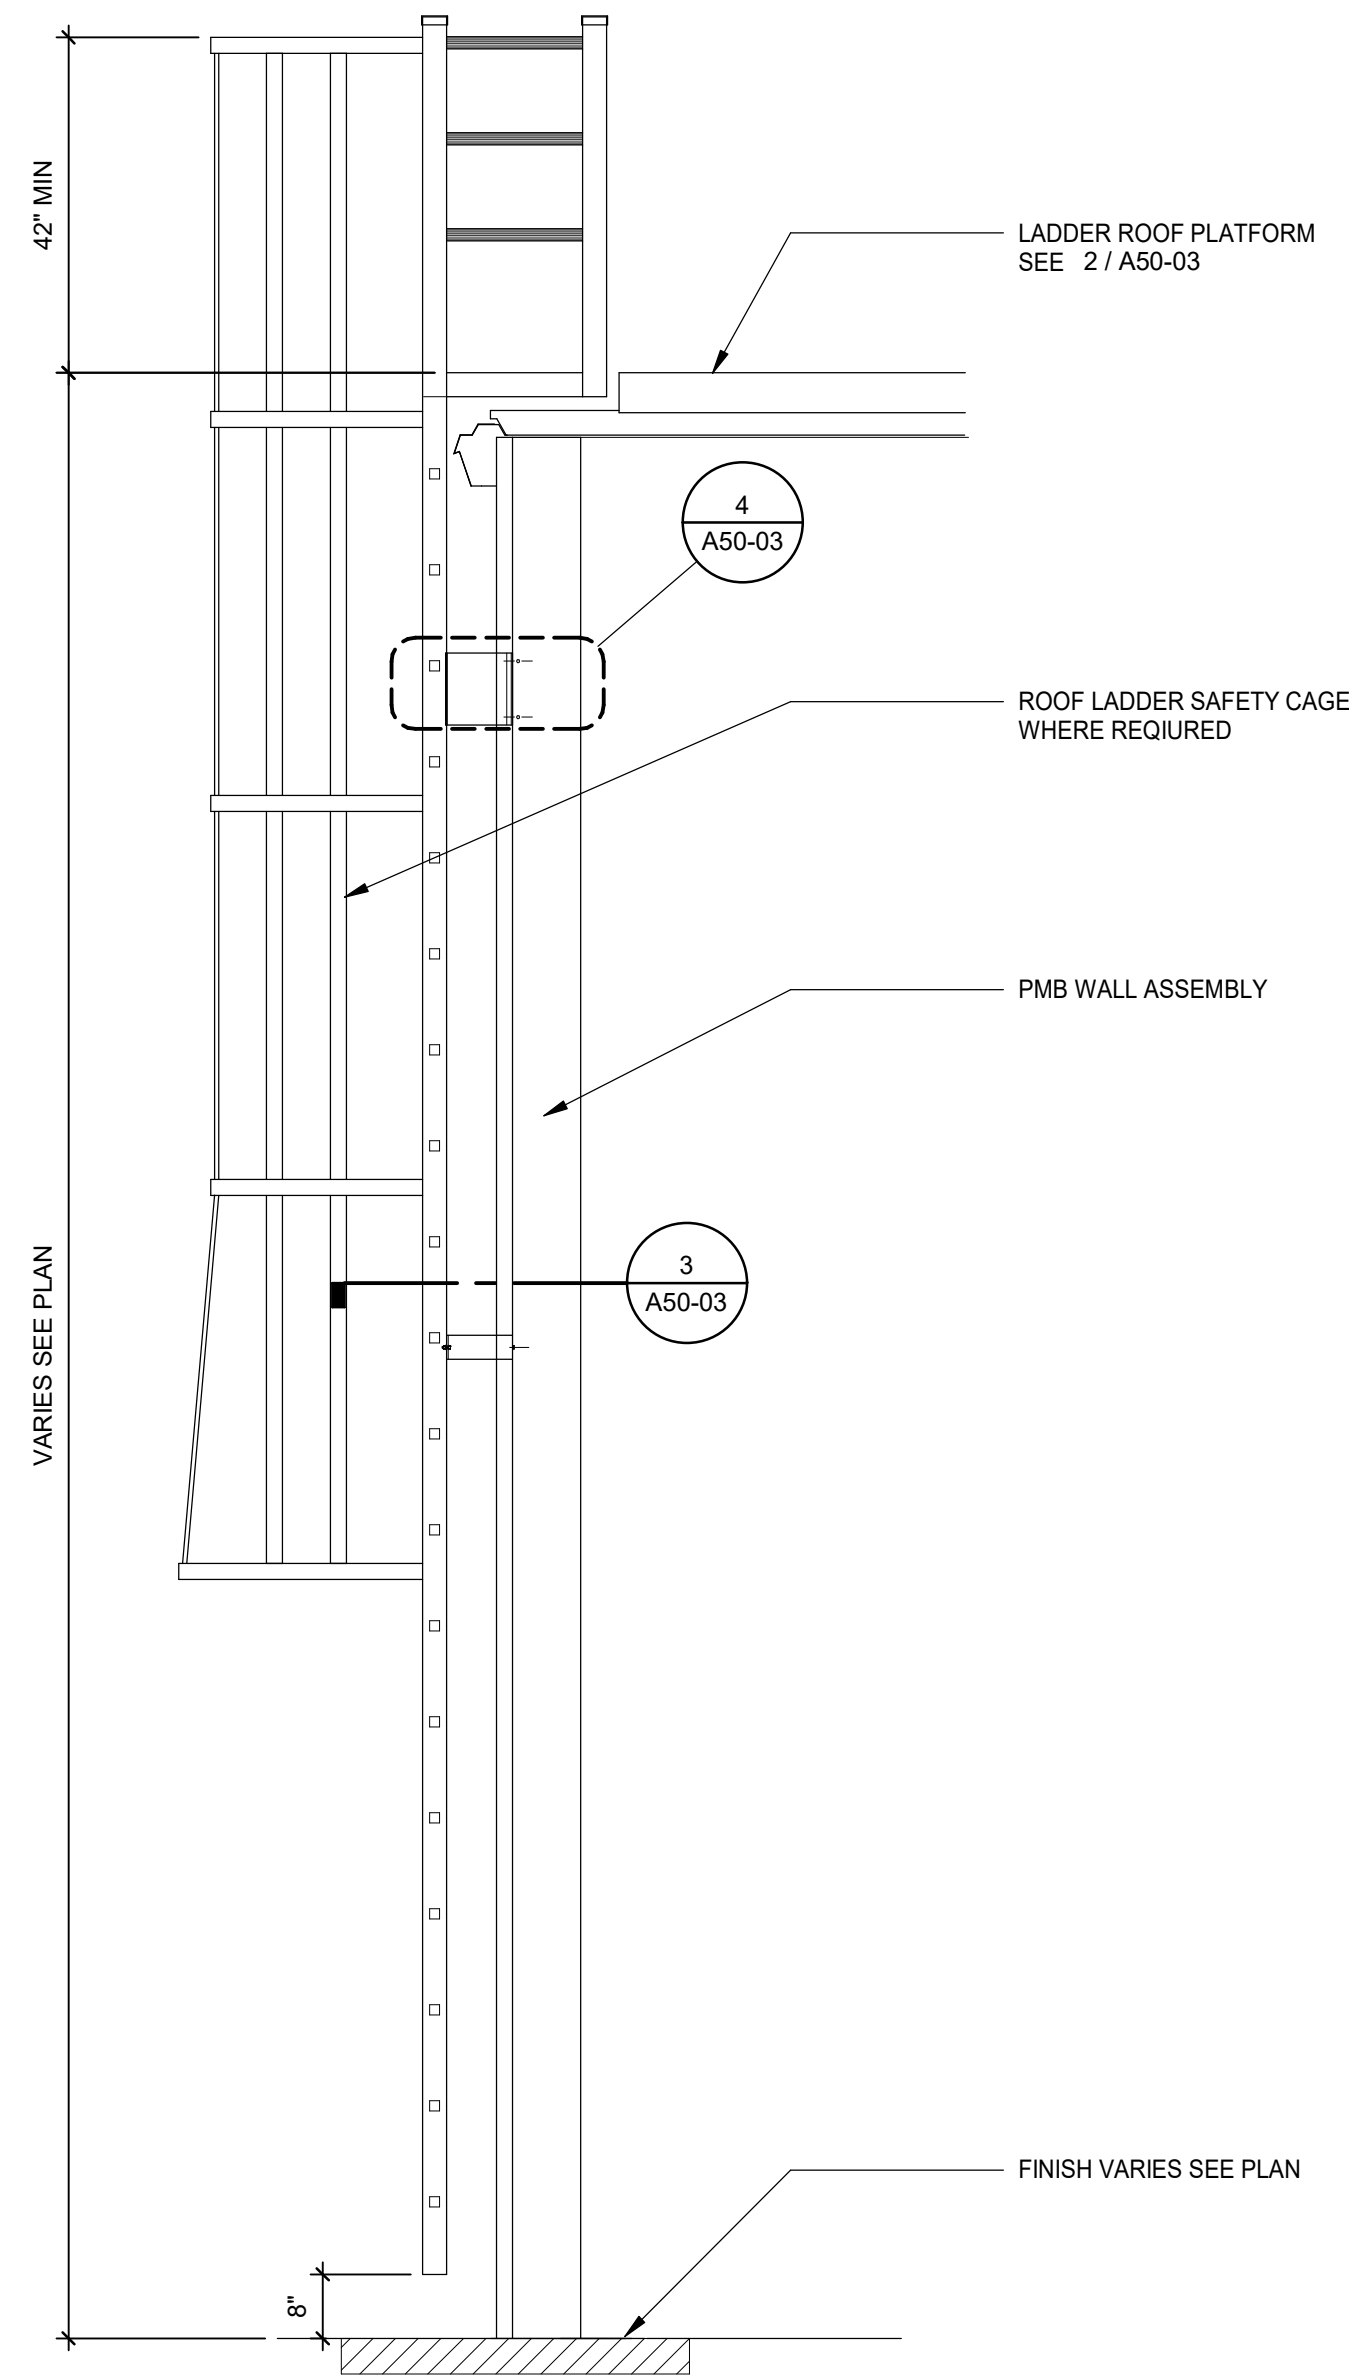


1
A50-03
LADDER SIDE ELEVATION
SCALE: 1/2" = 1'-0"

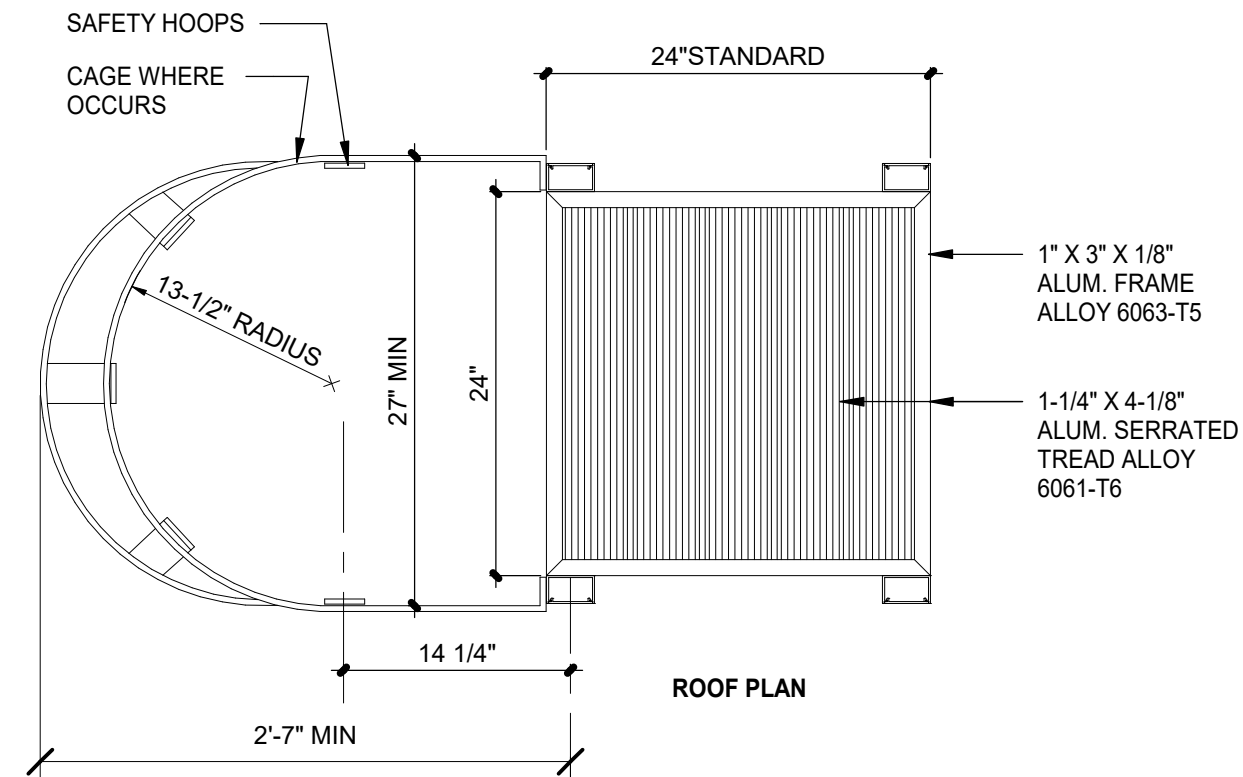

2
A50-03
LADDER ROOF PLATFORM
SCALE: 1" = 1'-0"

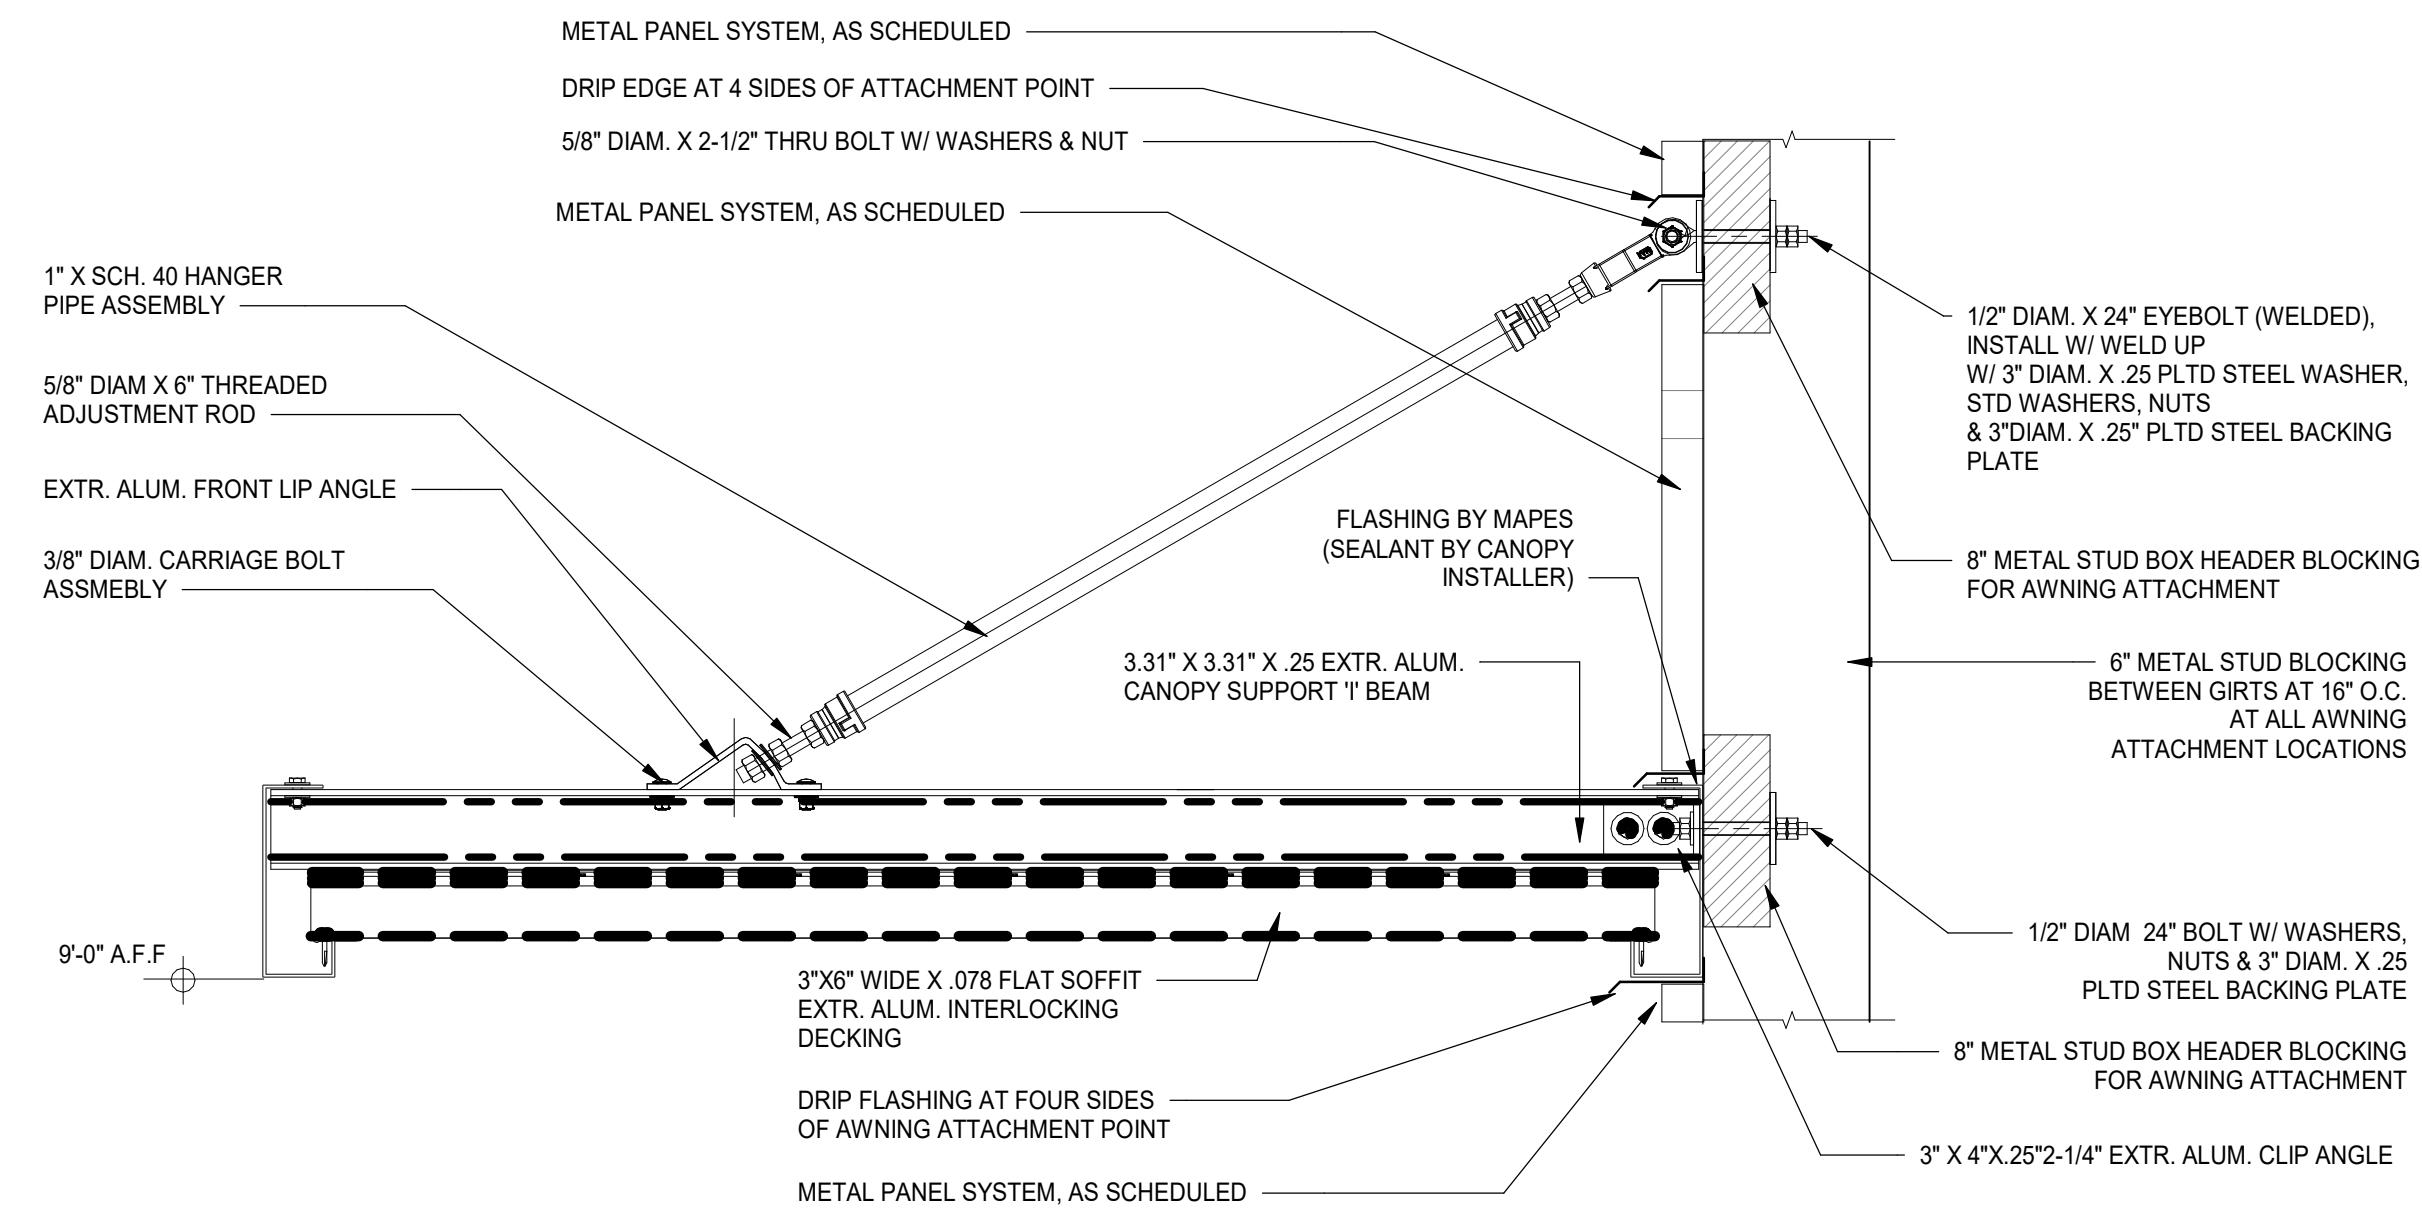

11
A50-03
METAL CANOPY
SCALE: 1 1/2" = 1'-0"

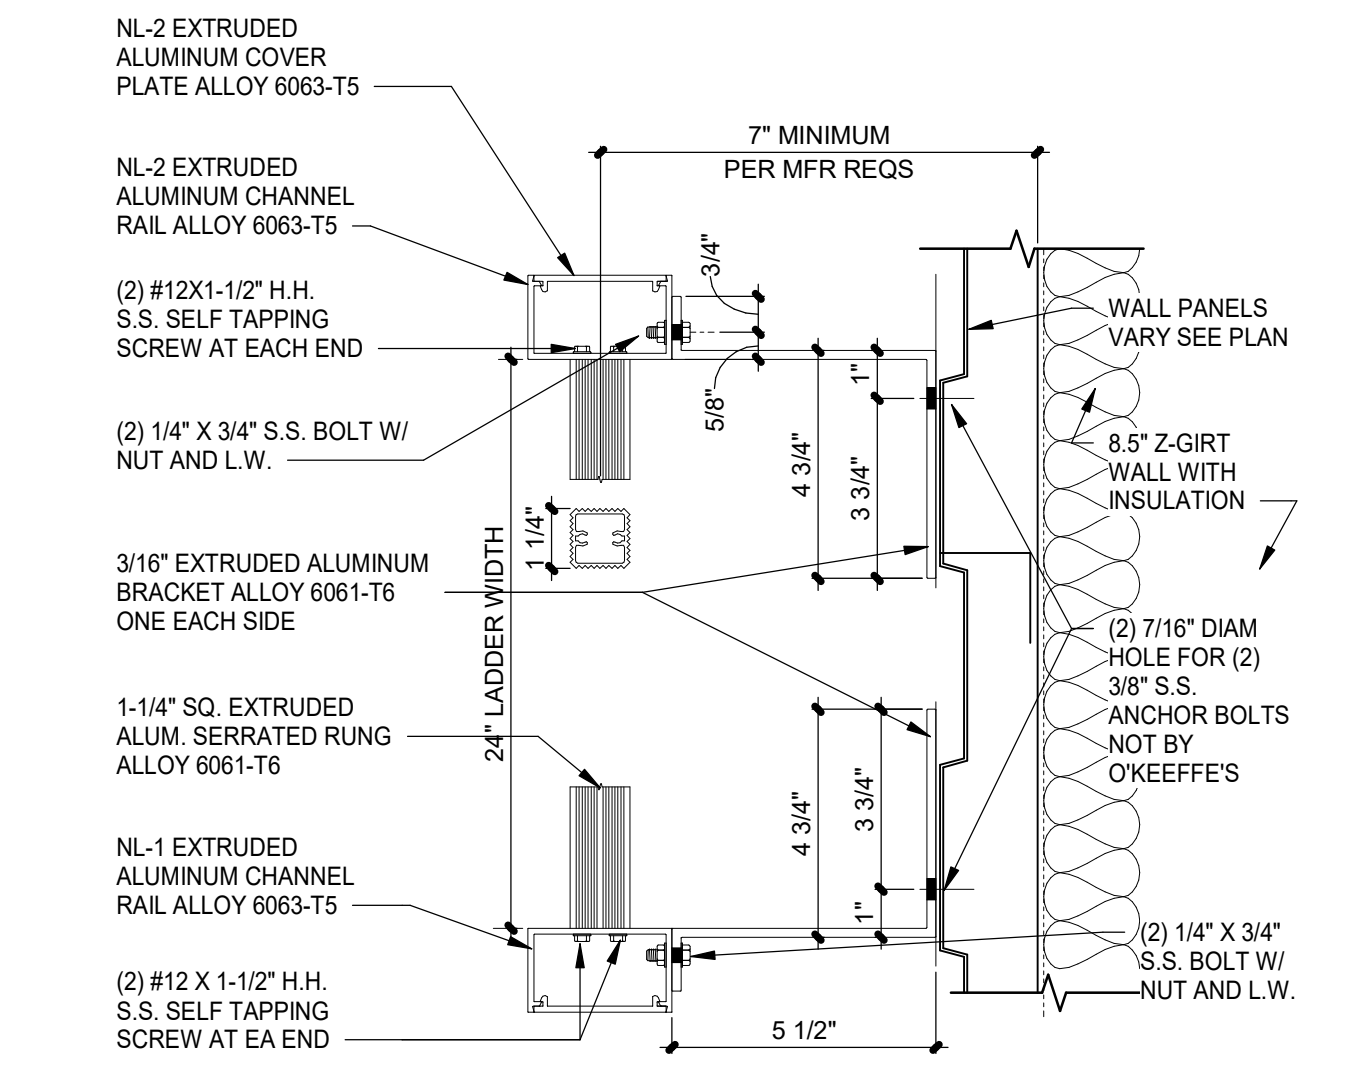

3
A50-03
LADDER BRACKET PLAN VIEW
SCALE: 3" = 1'-0"

DATE	ISSUED FOR	REV
06/26/2026	BID ADDENDUM 2	3

This drawing has been prepared solely for the use of MAMMOTH YOSEMITE AIRPORT and there are no representations of any kind made by NORR to any party with whom NORR has not entered into a contract.

This drawing shall not be used for construction purposes until the seal appearing hereon is signed and dated by the Architect or Engineer

Project Component

Key Plan

Consultants
Survey: Brandley Engineering
Civil: Kimley-Horn
Architecture: NORR
Structural: Bevier Structural Eng
Mechanical: NORR
Electrical: NORR
Interiors: NORR
Fire Sprinkler: Sacramento Engineering Consultants

Seal(s)



NORR

2020 I Street, Suite 220
Sacramento, CA, US 95811
norr.com

Project Manager	Drawn
Project Leader	Checked
	MIKE NOVAK

Client
MAMMOTH YOSEMITE AIRPORT

Project
MAMMOTH SRE BLUIDING

MAMMOTH, CALIFORNIA
Drawing Title
EXTERIOR DETAILS


Scale
As indicated

Project No.
IN2024-0022

Drawing No.
A50-03

5/15/2025 2:36:40 PM

Autodesk Docs\Mammoth Phase 3\11/02/24-0022_EU_Mammoth Phase 3_1023.rvt

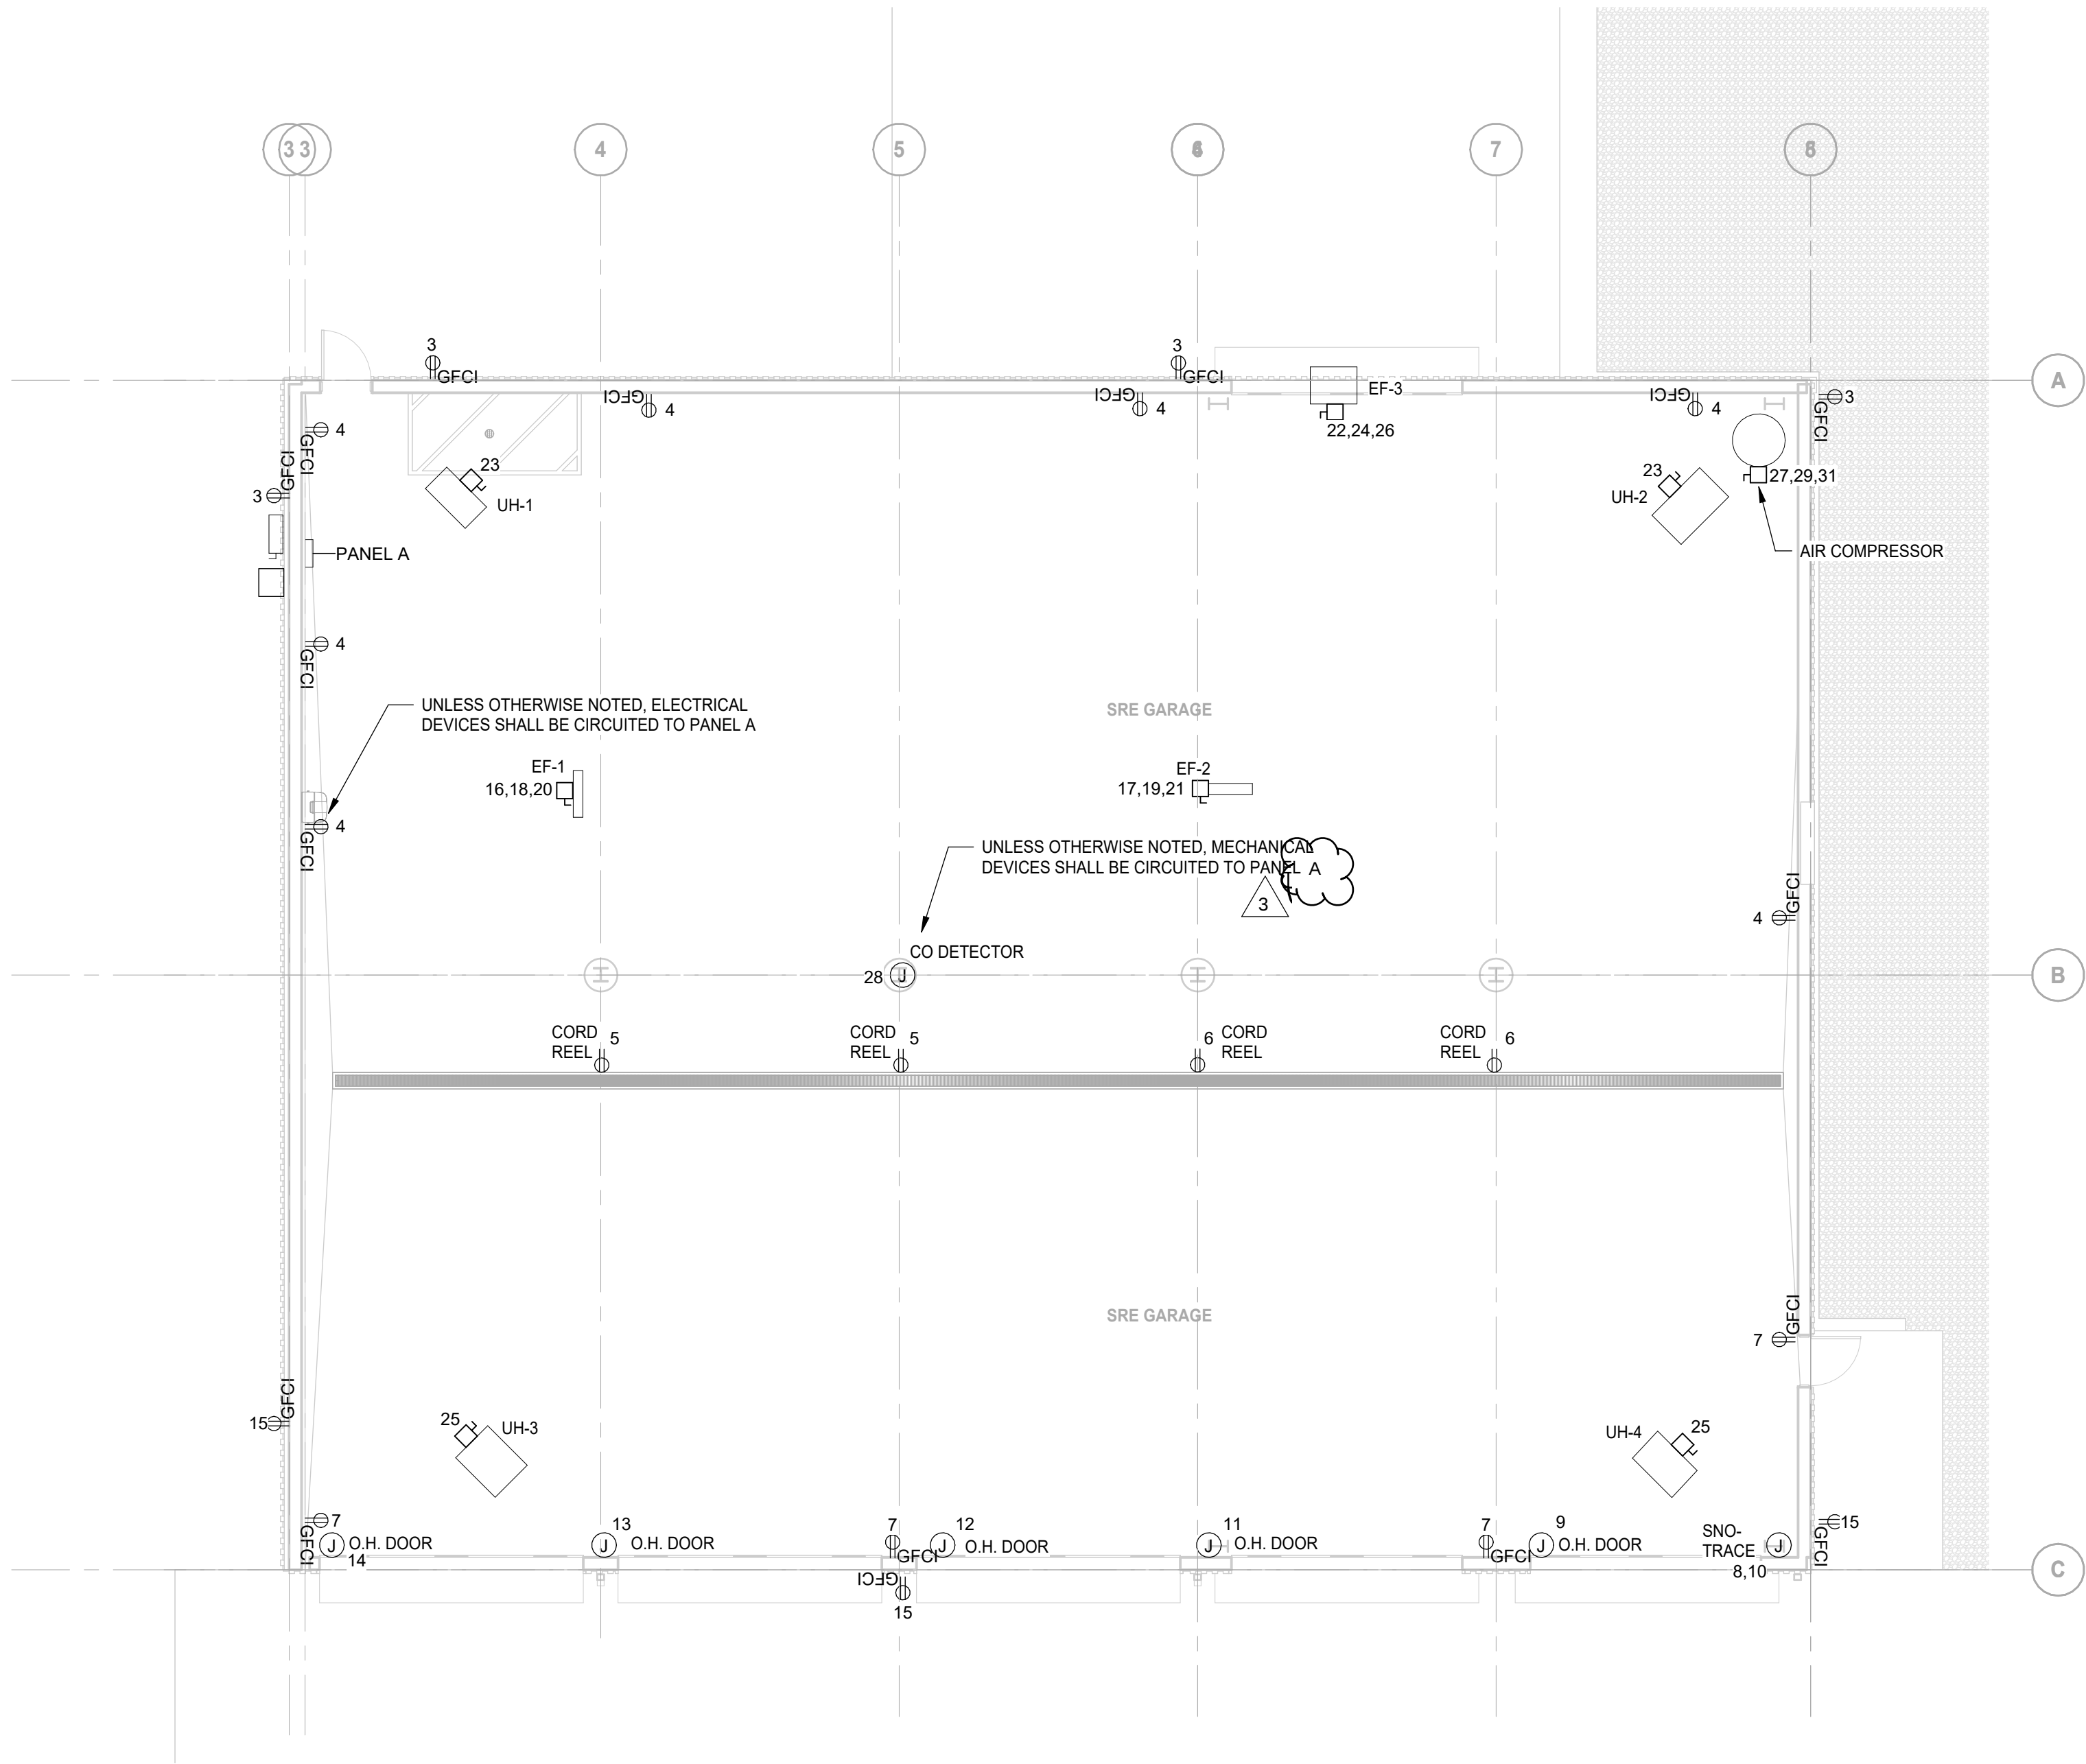

1
E10-01
OVERALL POWER PLAN - LEVEL 1
SCALE: 1/8" = 1'-0"

DATE	ISSUED FOR	REV
2026/06/26	BID ADDENDUM 2	3

This drawing has been prepared solely for the use of MAMMOTH YOSEMITE AIRPORT and there are no representations of any kind made by NORR to any party with whom NORR has not entered into a contract.

This drawing shall not be used for construction purposes until the seal appearing hereon is signed and dated by the Architect or Engineer

Project Component

Key Plan

Consultants
Survey:
Civil:
Architecture: NORR
Structural:
Mechanical: NORR
Electrical:
Interiors:
Landscape:

Seal(s)

NORR
The Cannery
1631 Alhambra Blvd., Suite 100
Sacramento, CA, US 95816
norr.com

Project Manager	Drawn Author
Project Leader	Checked Checker

Client
**MAMMOTH YOSEMITE
AIRPORT**

Project
MAMMOTH ARFF/SRF

MAMMOTH, CALIFORNIA

Drawing Title
**LEVEL 1 OVERALL POWER
PLAN**

Scale
1/8" = 1'-0"

Project No.
XXXX00-0000

Drawing No.
E10-01

ARCH D Title Block - v.2023 - Rev (July/23) - Copyright © 2023