

0 1/4" 1/2" 1" 2"

IF THIS SHEET IS NOT 22"x34", IT IS A REDUCED PRINT - SCALE ACCORDINGLY

B

Autodesk Docs://City of Dixon - Fire Station 82/220308_Dixon_Fire Station_MP24.rvt

7/13/2026 8:43:34 AM

1

2

3

4

1

2

3

4

5

5.1

6

7

8

A

B

C

D

D.1



E

F

G

H

I

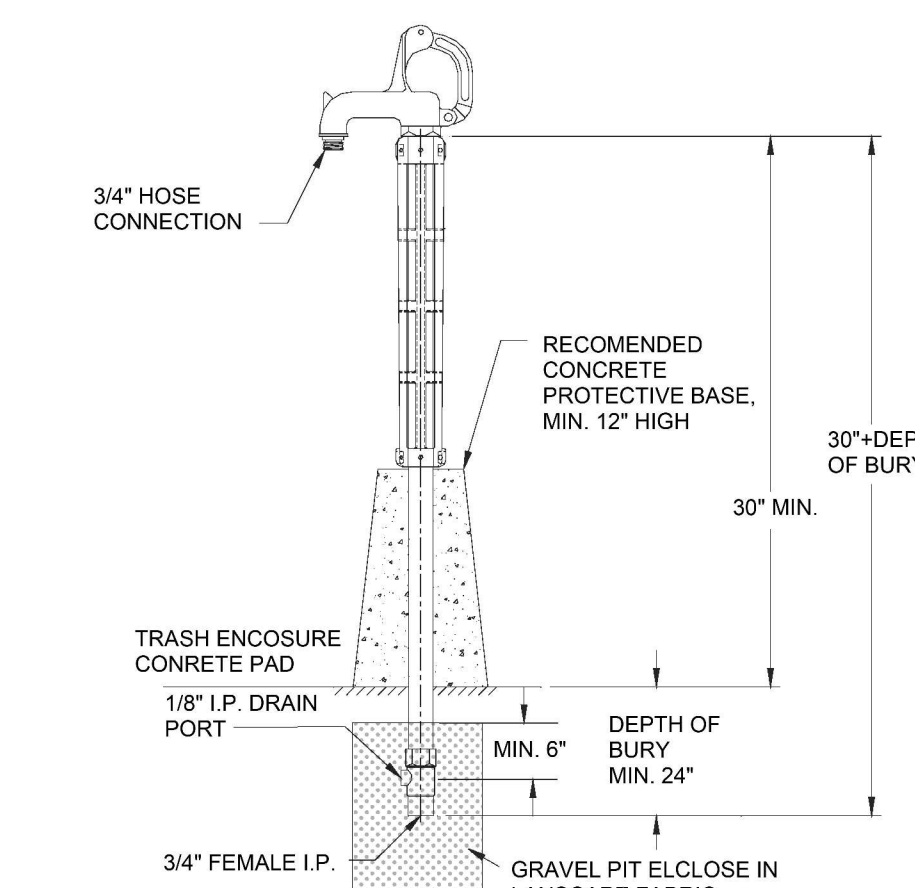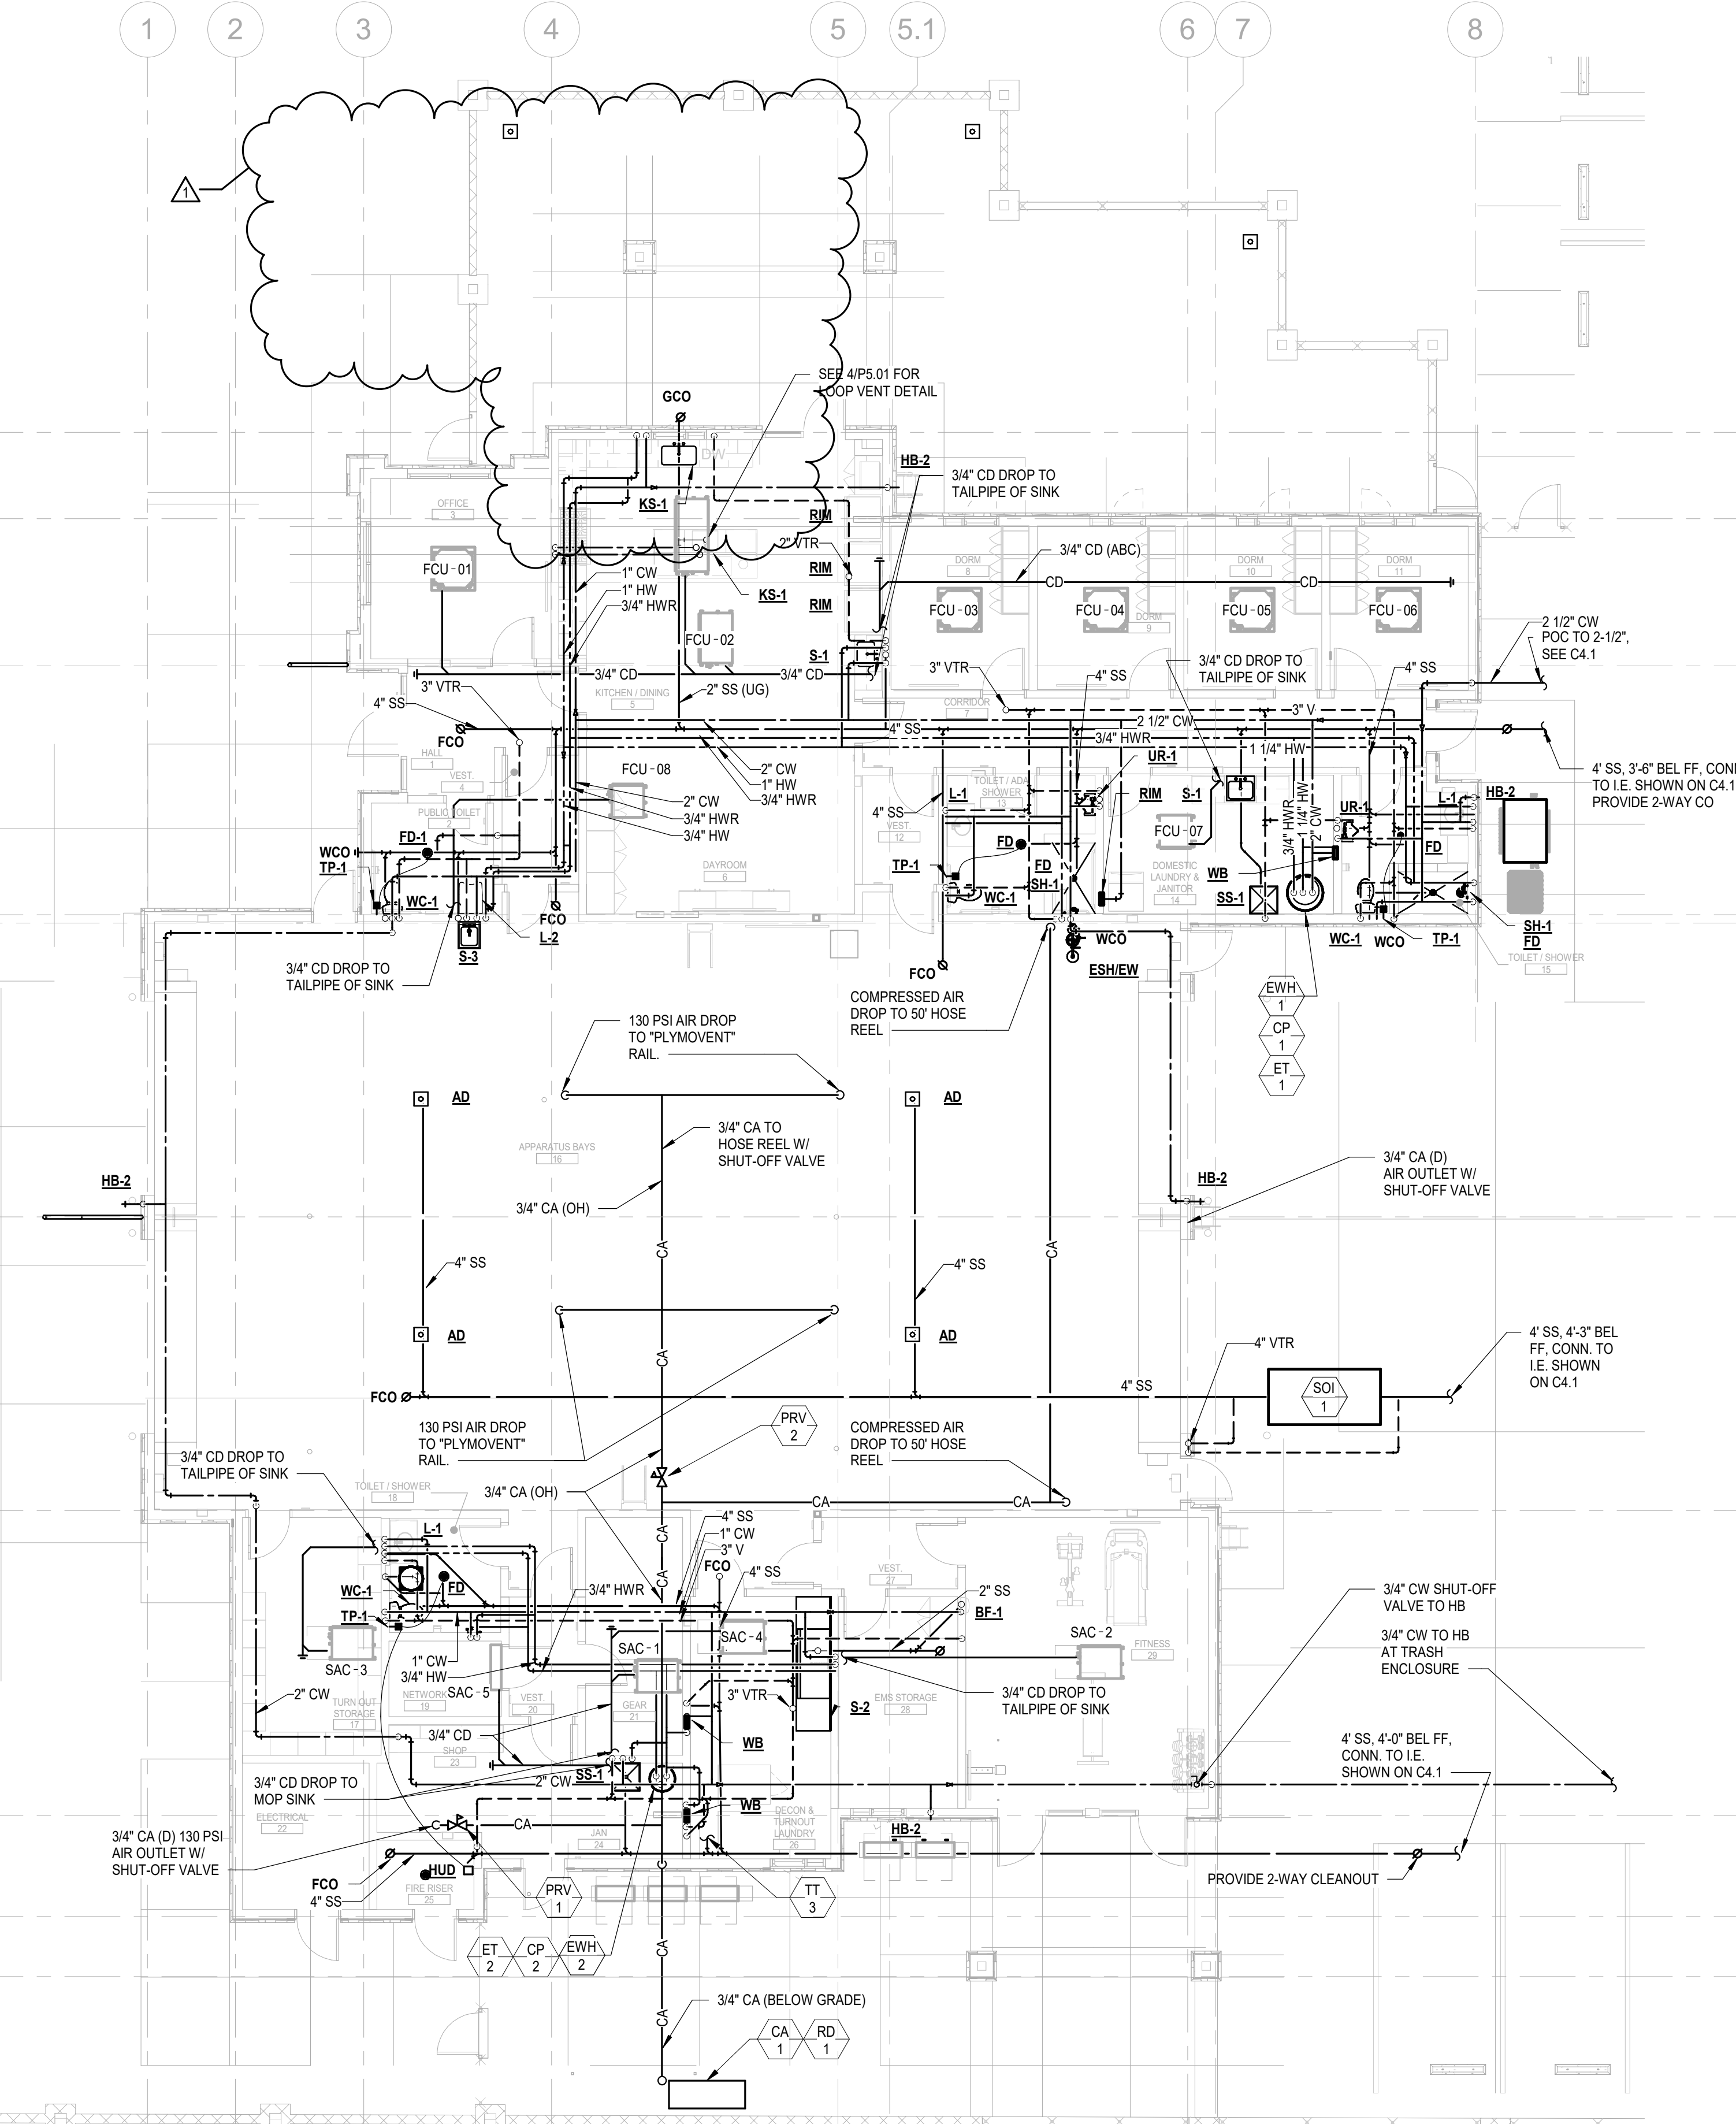

2 HYDRANT DETAIL
P2.00 SCALE: NONE

NOTE:
PROVIDE FROST FREE YARD HYDRANT, ZURN ELKAY
MODEL NO. Z1396XL-3/4 INSIDE TRASH ENCLOSURE. DEPTH
OF BURY SHALL BE 24" MIN. WITH BED OF GRAVEL 6" ABOVE
DRAIN PORT. PROVIDE CONCRETE PROTECTIVE BASE PER
MANUFACTURER'S RECOMMENDATION. LOCATE HYDRANT IN
PROTECTED AREA.

1 PLUMBING FLOOR PLAN
P2.00 SCALE: 1/8" = 1'-0"

LIONAKIS
2025 Nineteenth Street
Sacramento, CA 95818
P 916.550.1900
www.lionakis.com

CONSULTANT

capital
engineering
RANCHO CORDOVA, CALIFORNIA
ADB-AL/GKD 220508.00
PM - DESIGN TEAM PROJECT NO.

SEAL

DATE SIGNED: 4/10/26

PROJECT
Dixon Fire Station 82

Dixon, CA 95620

CLIENT
City of Dixon

ISSUED

MARK	DATE	DESCRIPTION
	7/13/2026	Addendum #2

MANAGEMENT

LIONAKIS PROJECT NO: 22204
CLIENT PROJECT NO:

AGENCY

TITLE
PLUMBING
FLOOR PLAN

SHEET
P2.00