


IF THIS SHEET IS NOT 30"x42" IT IS A REDUCED PRINT. SCALE ACCORDINGLY.

Autodesk Docs (025112.01) Palmdale ELOP025112.01_ARCHNSTR_024_CENTRAL.rvt

1/17/2025 4:41:21 PM

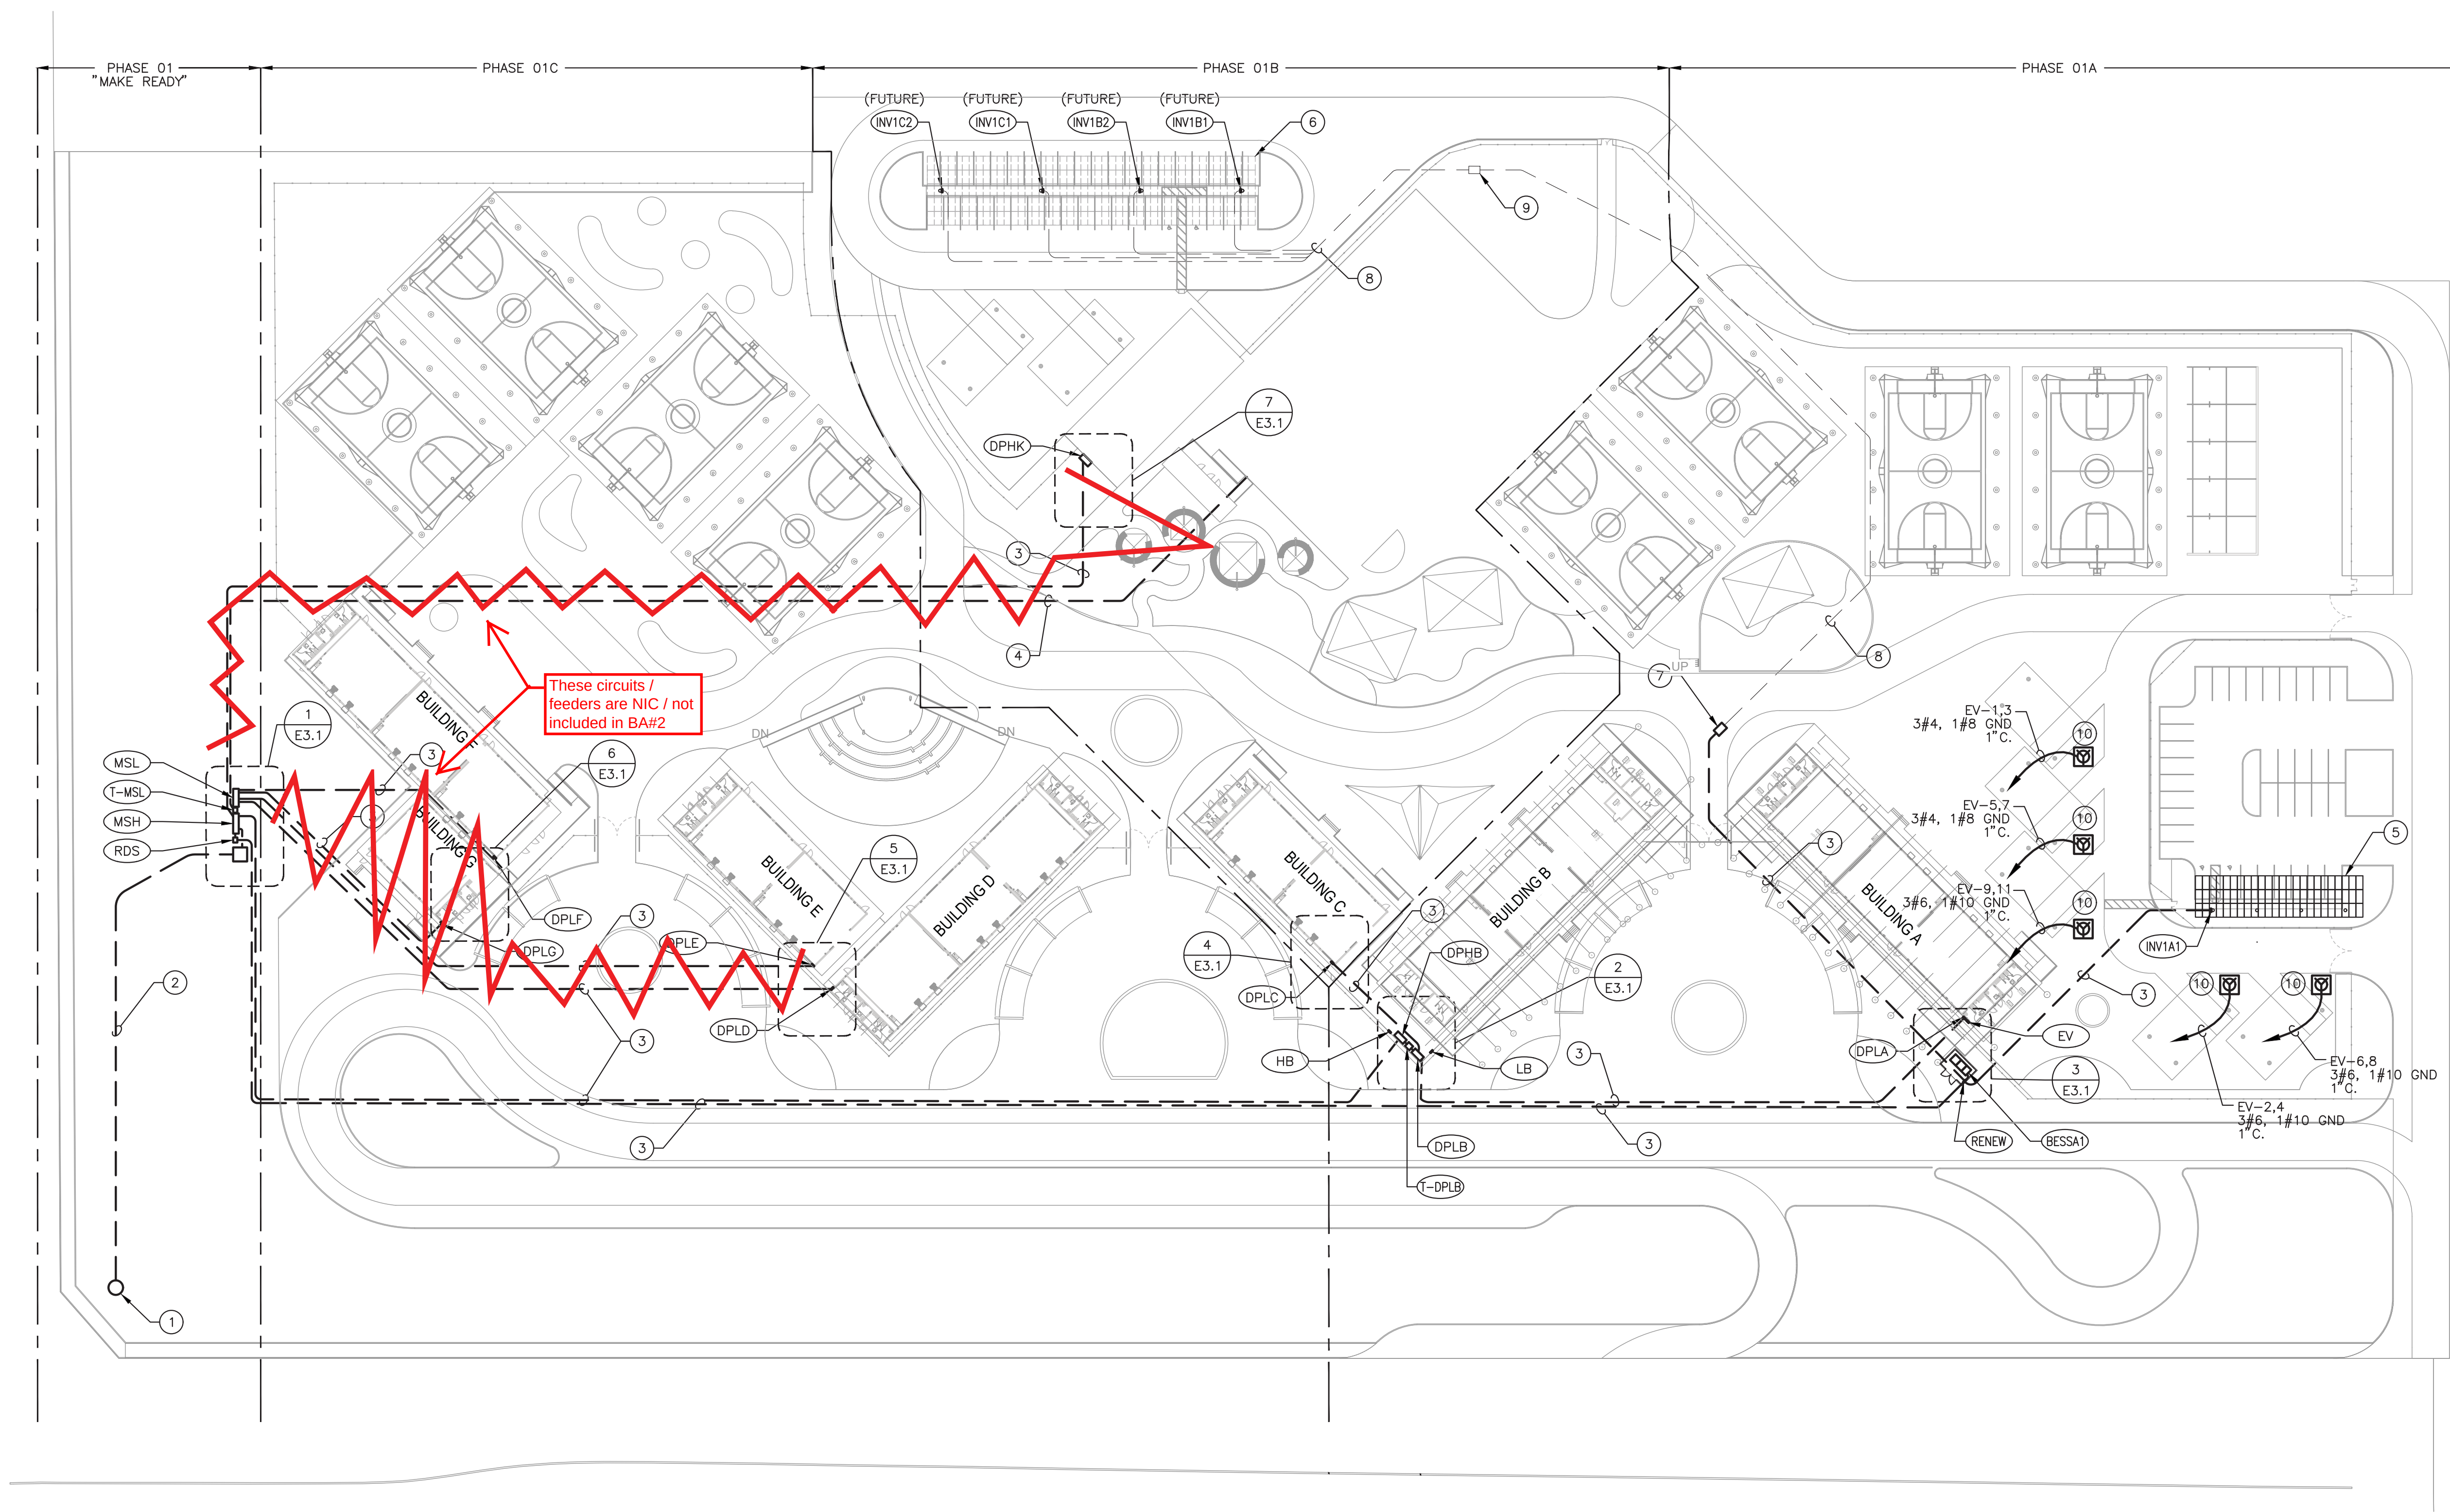

GENERAL NOTES

- CONTRACTOR MUST FIELD VERIFY EXISTING CONDITIONS AND COORDINATE WITH ALL OTHER TRADES. IN CASE OF DISCREPANCIES OR ANY POTENTIAL CONFLICTS, INFORM THE ARCHITECT AND ENGINEER IN WRITING PRIOR TO START OF WORK.
- CONTRACTOR MUST VERIFY EXACT QUANTITIES, LOCATIONS AND HEIGHTS OF ALL FIXTURES WITH TENANT AND ARCHITECT PRIOR TO START OF WORK.

KEY NOTES

- NEW SCE POLE.
- NEW UNDERGROUND PRIMARY CONDUIT.
- NEW UNDERGROUND DISTRIBUTION CONDUIT. REFER TO SINGLE LINE DIAGRAM.
- PROVIDE (1)4" CONDUIT ONLY FOR FUTURE BUILDING M.
- PHOTOVOLTAIC ARRAY ON CARPORT CANOPY.
- FUTURE PHOTOVOLTAIC ARRAYS ON CARPORT CANOPY.
- NEW 36" X 60" MINIMUM PULL BOX.
- FUTURE UNDERGROUND DISTRIBUTION CONDUIT. REFER TO SINGLE LINE DIAGRAM.
- FUTURE 36" X 60" MINIMUM PULL BOX.
- PROVIDE WEATHER PROOF CONCRETE PULLBOX AND PEDESTAL MOUNT 14-50R RECEPTACLE WITH WEATHER RESISTANT COVER FOR ELECTRIC BUS CHARGING STATION.

SCOPE NOTES:

- PHASE 01 MAKE READY:**
SCE PRIMARY AND SECONDARY POINTS OF CONNECTION AND UNDERGROUND CONDUIT, PAD FOR UTILITY TRANSFORMER.
MAIN ELECTRICAL SERVICE SWITCHGEAR AND DISTRIBUTION.
UNDERGROUND CONDUIT TO PHASES 01A, 01B AND 01C DISTRIBUTION BOARDS AND PANELS.
- PHASE 01A:**
DISTRIBUTION AND PANELS IN THE PHASE 01A BOUNDARY ARE TO BE INSTALLED.
FEEDERS TO BE PULLED AND CONNECTED TO THE DISTRIBUTION BOARDS AND PANELS.
CONNECTIONS TO MODULAR BUILDING(S) IN THE PHASE 01A BOUNDARY.
SITE LIGHTING IN THE PHASE 01A BOUNDARY.
EV CHARGERS.
PHOTOVOLTAIC AND BATTERY SYSTEM.
- PHASE 01B:**
DISTRIBUTION AND PANELS IN THE PHASE 01B BOUNDARY ARE TO BE INSTALLED.
FEEDERS TO BE PULLED AND CONNECTED TO THE DISTRIBUTION BOARDS AND PANELS.
CONNECTIONS TO MODULAR BUILDING(S) IN THE PHASE 01B BOUNDARY.
SITE LIGHTING IN THE PHASE 01B BOUNDARY.
PHOTOVOLTAIC AND BATTERY SYSTEM.
- PHASE 01C:**
DISTRIBUTION AND PANELS IN THE PHASE 01C BOUNDARY ARE TO BE INSTALLED.
FEEDERS TO BE PULLED AND CONNECTED TO THE DISTRIBUTION BOARDS AND PANELS.
CONNECTIONS TO MODULAR BUILDING(S) IN THE PHASE 01C BOUNDARY.
SITE LIGHTING IN THE PHASE 01C BOUNDARY.


LIONAKIS

2059 Main Street, Suite 400
Irvine, CA 92614
P 949.955.1319 F 949.955.9175
www.lionakis.com

CONSULTANT

Salas O'Brien
3220 Executive Ridge, Suite 210
Visalia, CA 93201
760.560.0100
02-23-26 #2590-00313
www.salasobrien.com E-Mail

SEAL

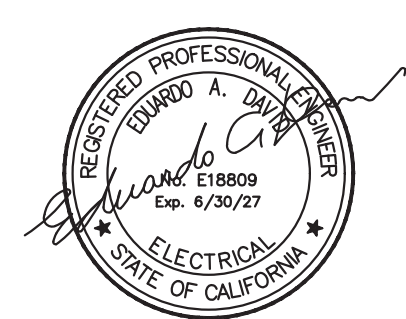

PROJECT
PALMDALE ELOP CENTER

NE CORNER OF 40th and Q
PALMDALE, CA

CLIENT
PALMDALE SCHOOL DISTRICT
39139 10TH ST E, PALMDALE, CA 93550

ISSUED		
MARK	DATE	DESCRIPTION

MANAGEMENT
LIONAKIS PROJECT NO. 025112.01
CLIENT PROJECT NO.
COPYRIGHT: LIONAKIS 2017

TITLE
ELECTRICAL
SITE PLAN - PHASE 1

SHEET

E1.1

1 ELECTRICAL SITE PLAN - PHASE 1
SCALE 1" = 50'-0"

IF THIS SHEET IS NOT 30"x42" IT IS A REDUCED PRINT. SCALE ACCORDINGLY.

Autodesk Docs: 025112.01 Palmdale ELOP025112.01_ARCHNSTR_024_CENTRAL.rvt

1/17/2025 4:44:21 PM


0 1/4" 1/2" 1"

C

B

1 TELECOMMUNICATIONS SITE PLAN - PHASE 1
SCALE 1" = 50'-0"

40TH STREET

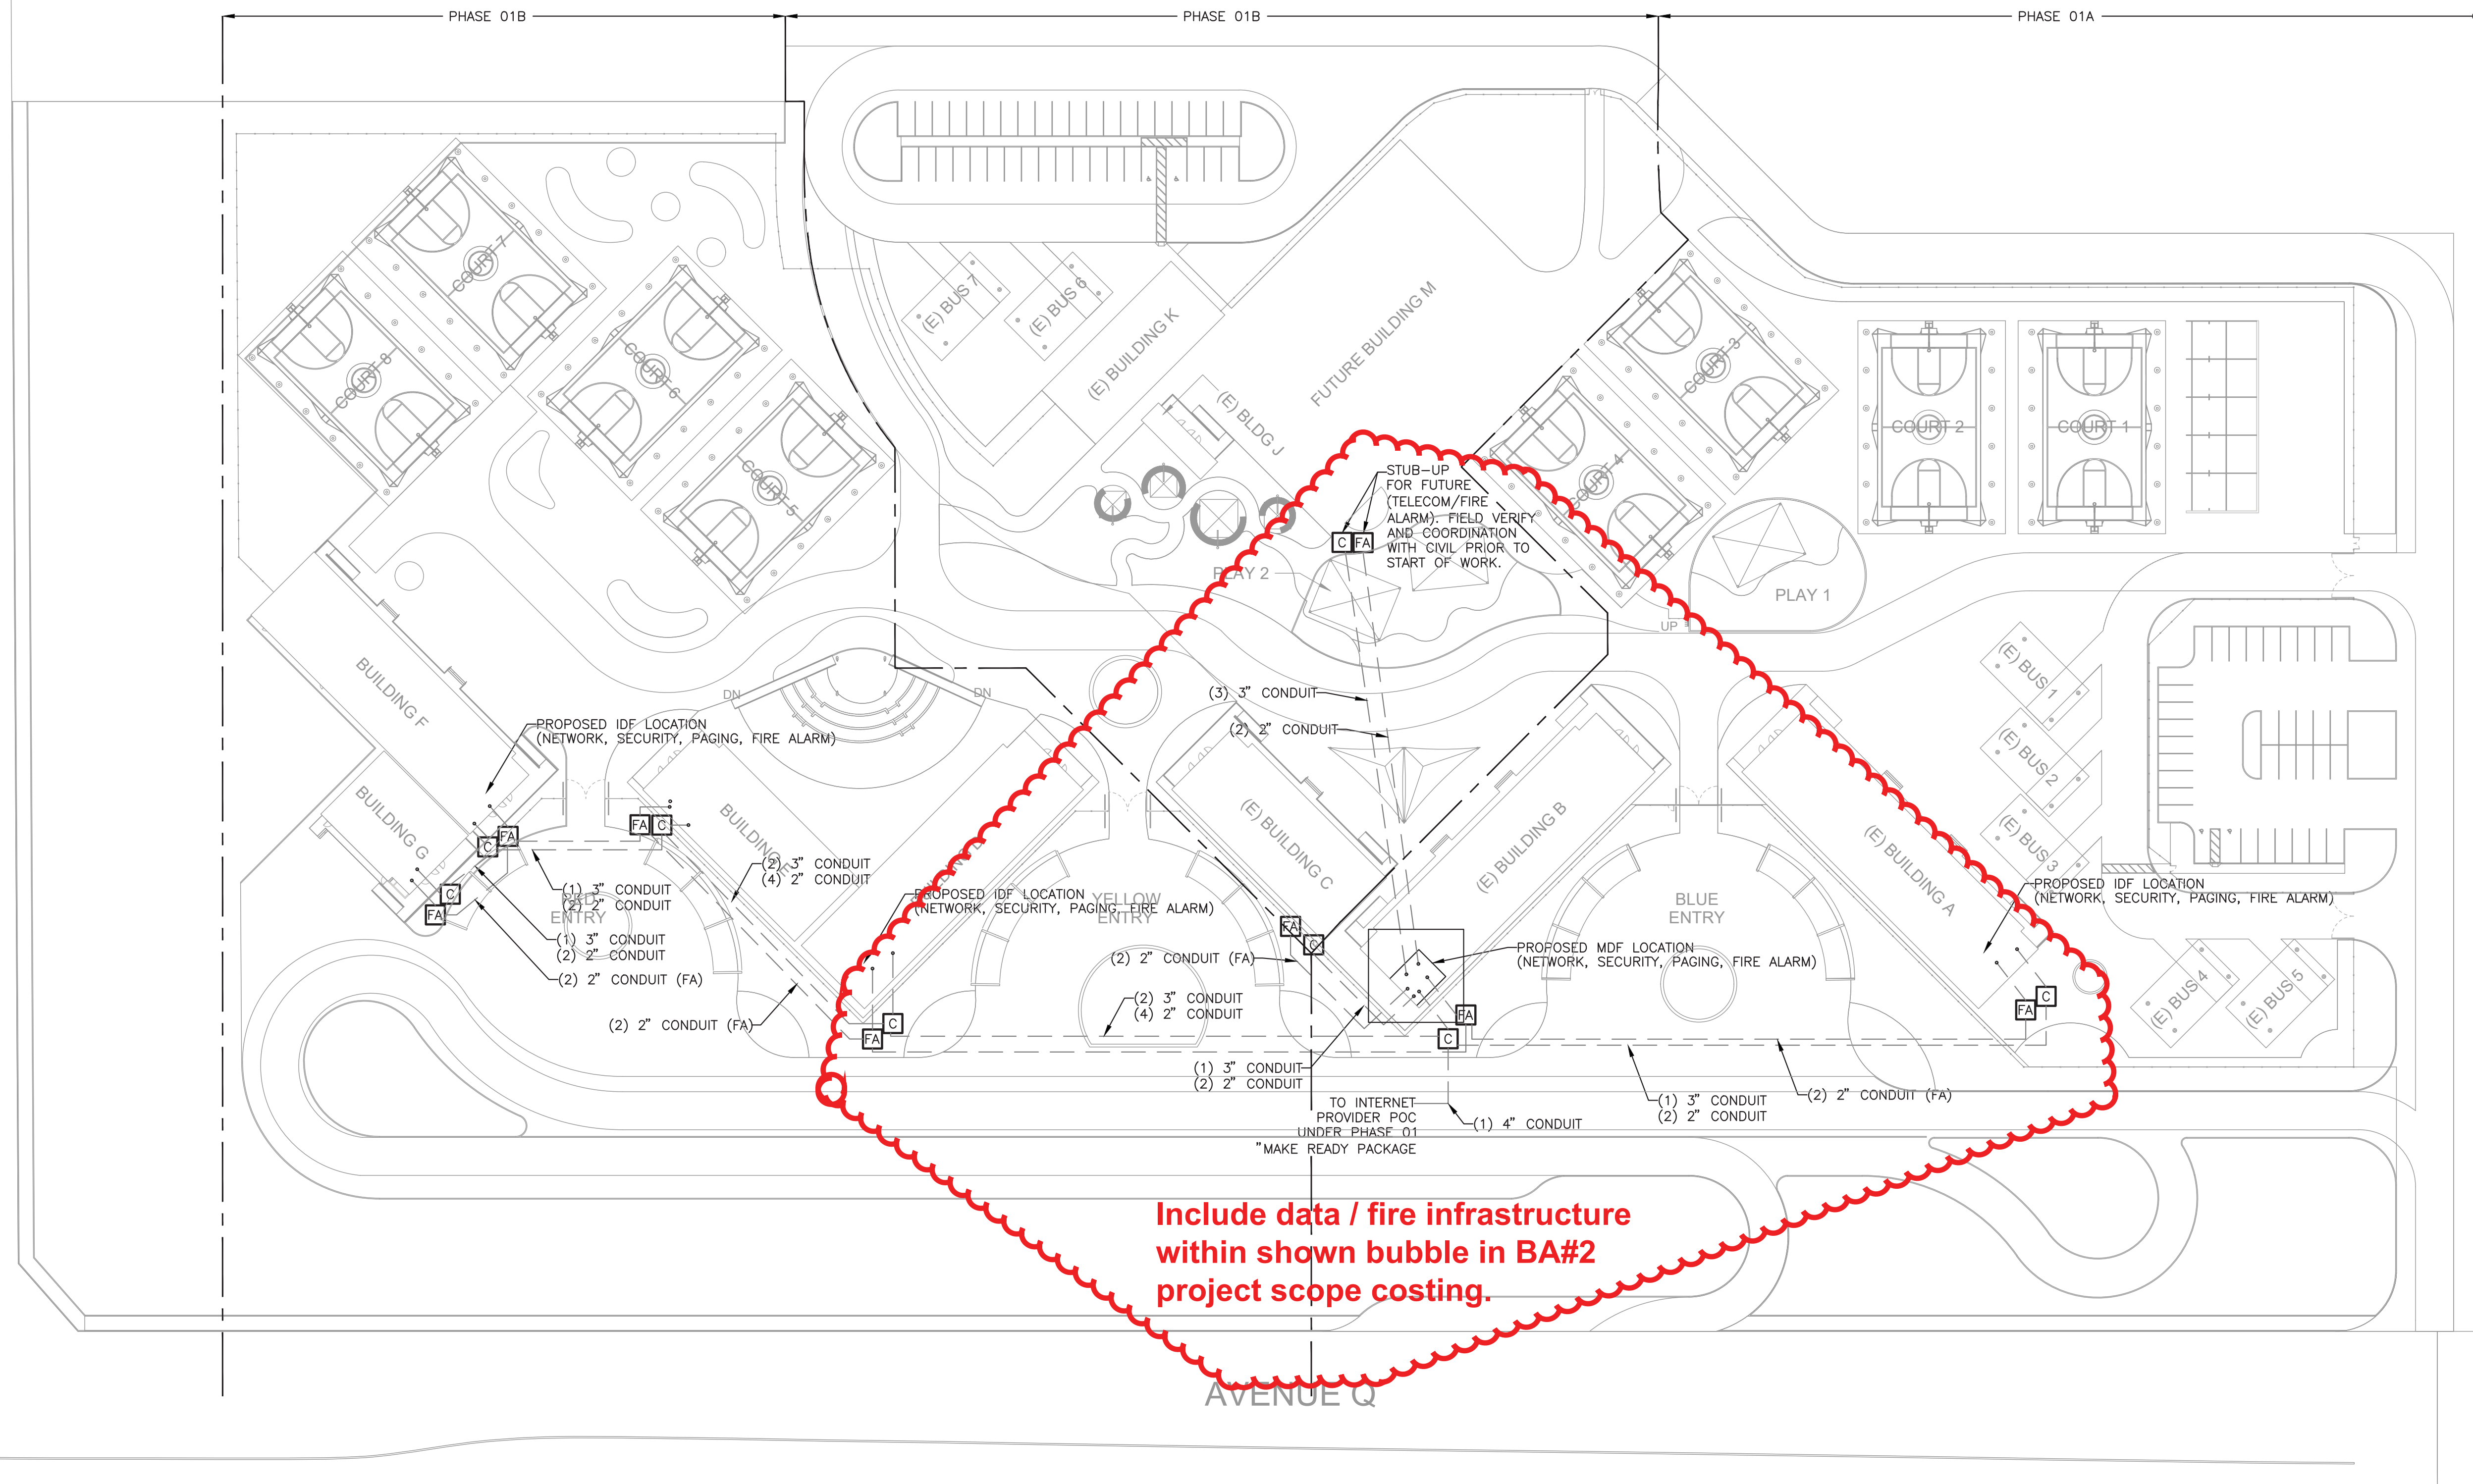

GENERAL NOTES

- A. CONTRACTOR MUST FIELD VERIFY EXISTING CONDITIONS AND COORDINATE WITH ALL OTHER TRADES. IN CASE OF DISCREPANCIES OR ANY POTENTIAL CONFLICTS, INFORM THE ARCHITECT AND ENGINEER IN WRITING PRIOR TO START OF WORK.
- B. CONTRACTOR MUST VERIFY EXACT QUANTITIES, LOCATIONS AND HEIGHTS OF ALL FIXTURES WITH TENANT AND ARCHITECT PRIOR TO START OF WORK.

LEGEND

- FA FIRE ALARM HAND-HOLE.
- C TELECOMMUNICATIONS HAND-HOLE.

SCOPE NOTES:

PHASE 01 MAKE READY:
UNDERGROUND CONDUIT FROM TELECOMMUNICATIONS PROVIDER TO MDF ROOM AT BUILDING B.

CONDUIT ONLY ROUTED TO ALL MODULAR BUILDING LOCATIONS FROM BUILDING B MDF.

PHASE 01A:
CABLING ROUTED FROM MDF TO MODULAR BUILDINGS WITHIN THE PHASE 01A BOUNDARY.

PHASE 01B:
CABLING ROUTED FROM MDF TO MODULAR BUILDINGS WITHIN THE PHASE 01B BOUNDARY.

PHASE 01C:
CABLING ROUTED FROM MDF TO MODULAR BUILDINGS WITHIN THE PHASE 01C BOUNDARY.

LIONAKIS

2059 Main Street, Suite 400
Irvine, CA 92614
P 949.955.1319 F 949.955.9175
www.lionakis.com

CONSULTANT

Salas O'Brien
3220 Executive Ridge, Suite 210
Visita, CA 92081
760.560.0100
02-23-26 #2590-00313
www.salasobrien.com E-Mail

SEAL



PROJECT
PALMDALE ELOP CENTER

NE CORNER OF 40th and Q
PALMDALE, CA

CLIENT
PALMDALE SCHOOL DISTRICT
39139 10TH ST E, PALMDALE, CA 93550

ISSUED		
MARK	DATE	DESCRIPTION

MANAGEMENT
LIONAKIS PROJECT NO. 025112.01
CLIENT PROJECT NO.
COPYRIGHT: LIONAKIS 2017

TITLE
TELECOMMUNICATIONS
SITE PLAN - PHASE 1

SHEET

E1.2




IF THIS SHEET IS NOT 30"x42" IT IS A REDUCED PRINT. SCALE ACCORDINGLY.

Autodesk Docs (025112.01) Palmdale ELOP025112.01_ARCHNSTR_024_CENTRAL.M

1/17/2025 4:44:21 PM

GENERAL NOTES

- A. CONTRACTOR MUST FIELD VERIFY EXISTING CONDITIONS AND COORDINATE WITH ALL OTHER TRADES. IN CASE OF DISCREPANCIES OR ANY POTENTIAL CONFLICTS, INFORM THE ARCHITECT AND ENGINEER IN WRITING PRIOR TO START OF WORK.
- B. ALL WORK SHOWN IS NEW UNLESS NOTED OTHERWISE.

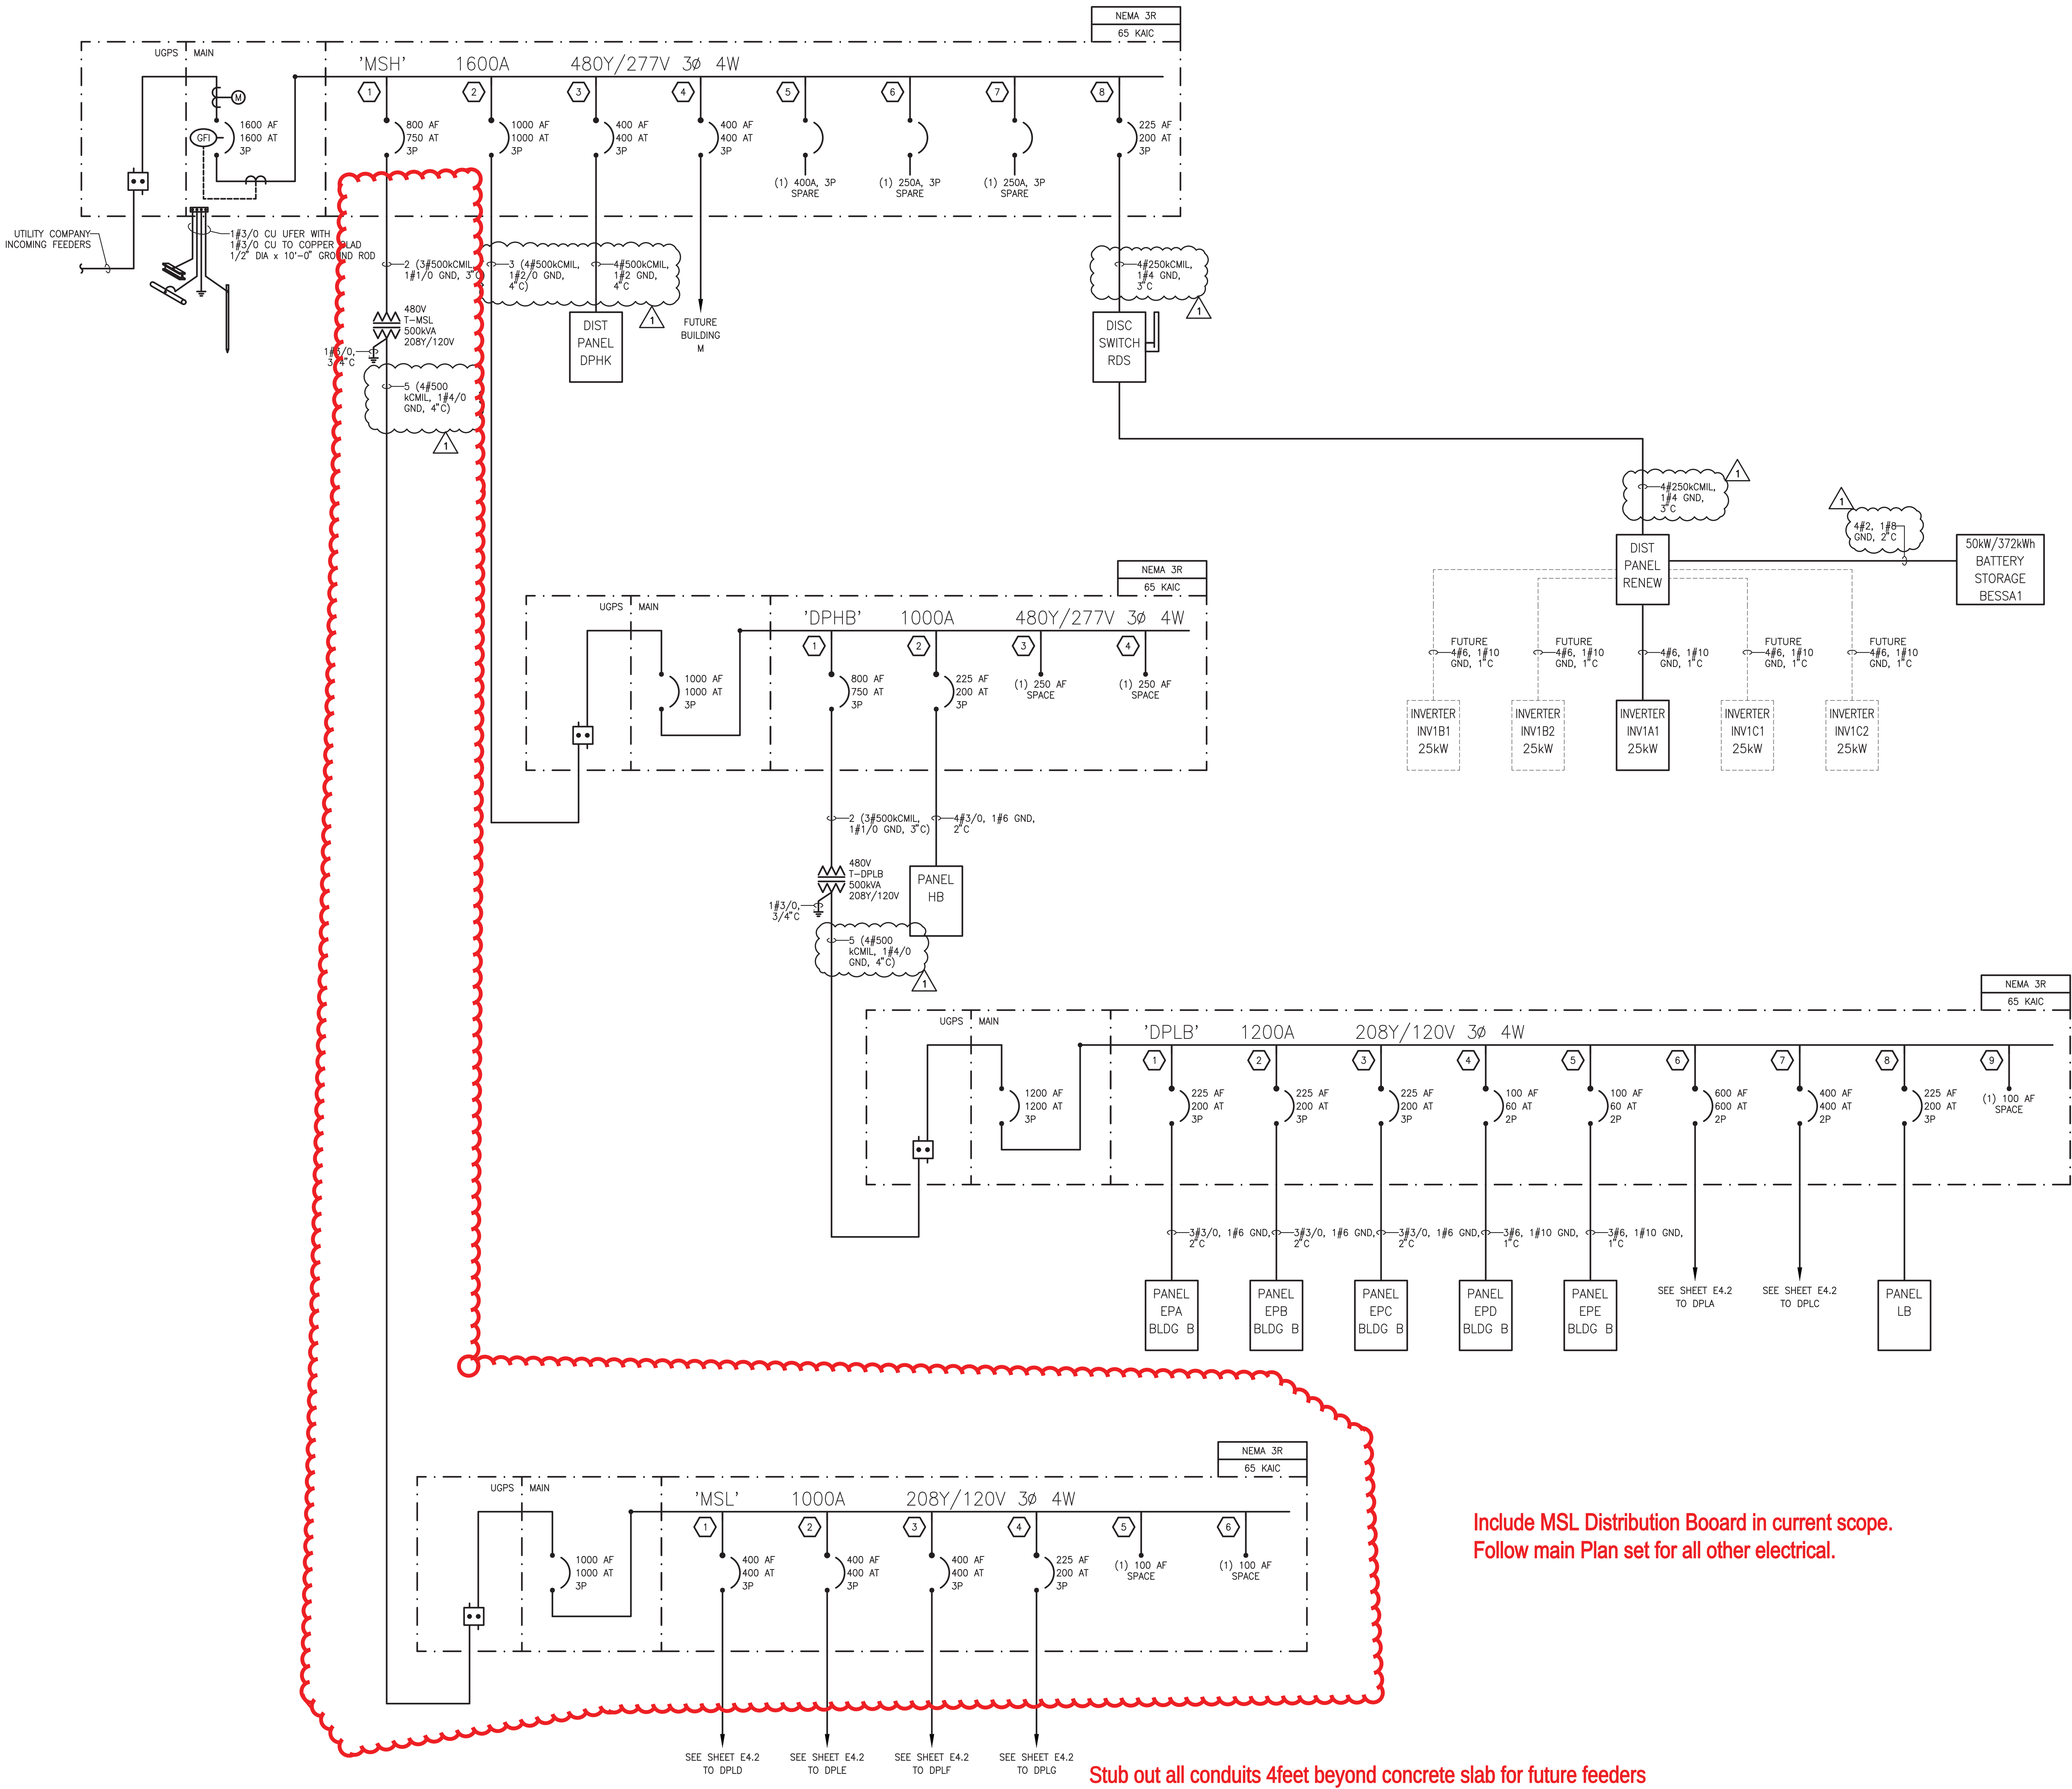

Include MSL Distribution Board in current scope.
Follow main Plan set for all other electrical.

Stub out all conduits 4feet beyond concrete slab for future feeders

1 SINGLE LINE DIAGRAM - PHASE 1

SCALE NONE

LIONAKIS

2050 Main Street, Suite 400
Irvine, CA 92614
P 949.955.1319 F 949.955.9175
www.lionakis.com

CONSULTANT

Salas
O'Brien

3220 Executive Ridge, Suite 210
Visalia, CA 93201
760.560.0100
02-23-26 #2590-00313
www.salasobrien.com E-Mail

SEAL



PROJECT
PALMDALE ELOP CENTER

NE CORNER OF 40th AND Q
PALMDALE, CA

CLIENT
PALMDALE SCHOOL DISTRICT
39139 10TH ST E, PALMDALE, CA 93550







ISSUED
MARK DATE DESCRIPTION

MANAGEMENT
LIONAKIS PROJECT NO. 025112.01
CLIENT PROJECT NO.
COPYRIGHT: LIONAKIS 2017

TITLE
SINGLE LINE DIAGRAM
AND LOAD SUMMARY
PHASE 1

SHEET

E4.1

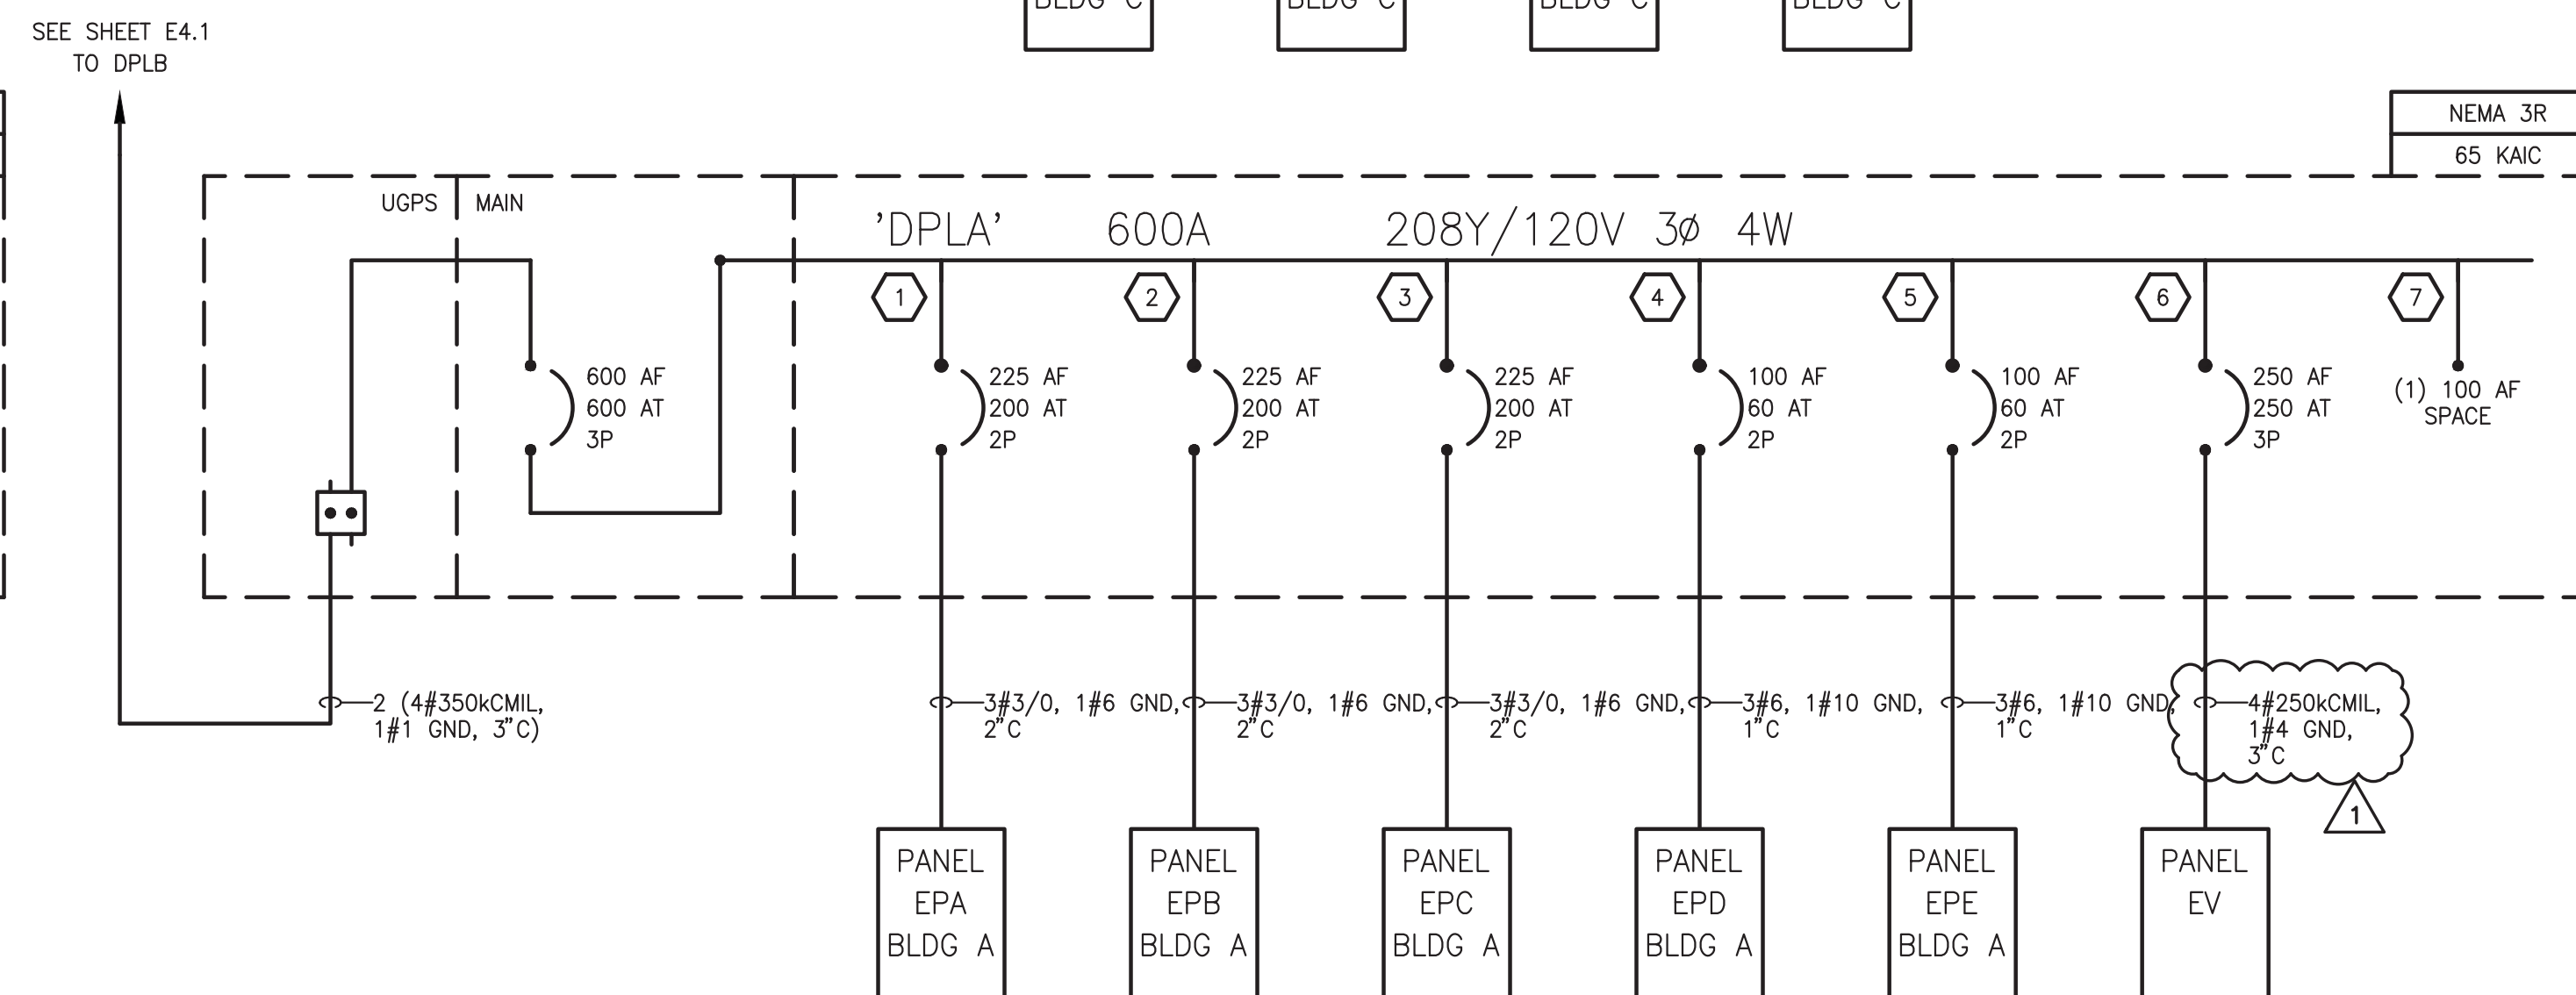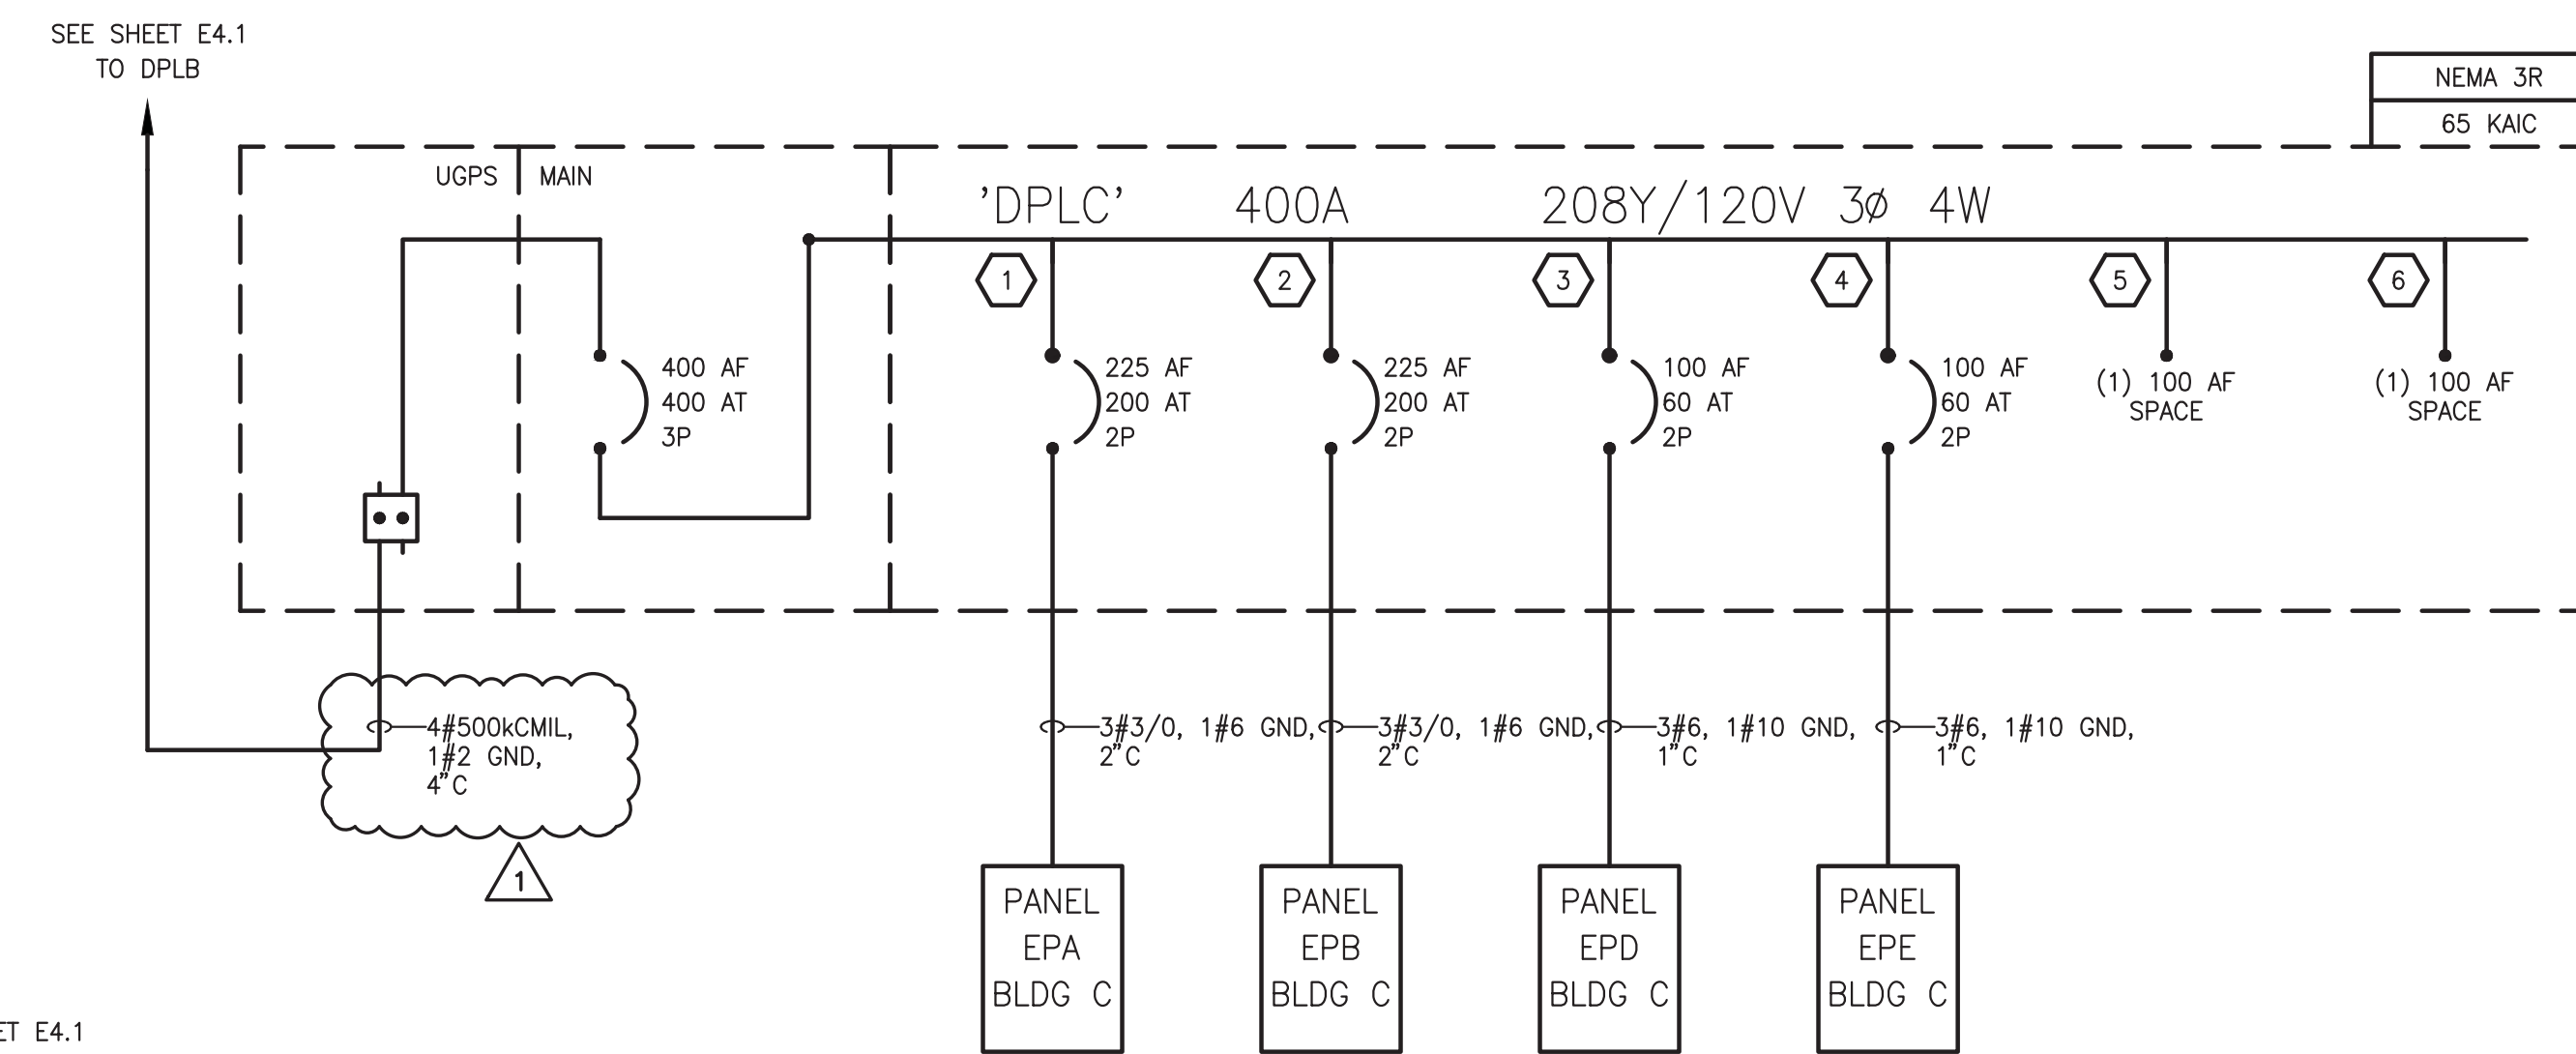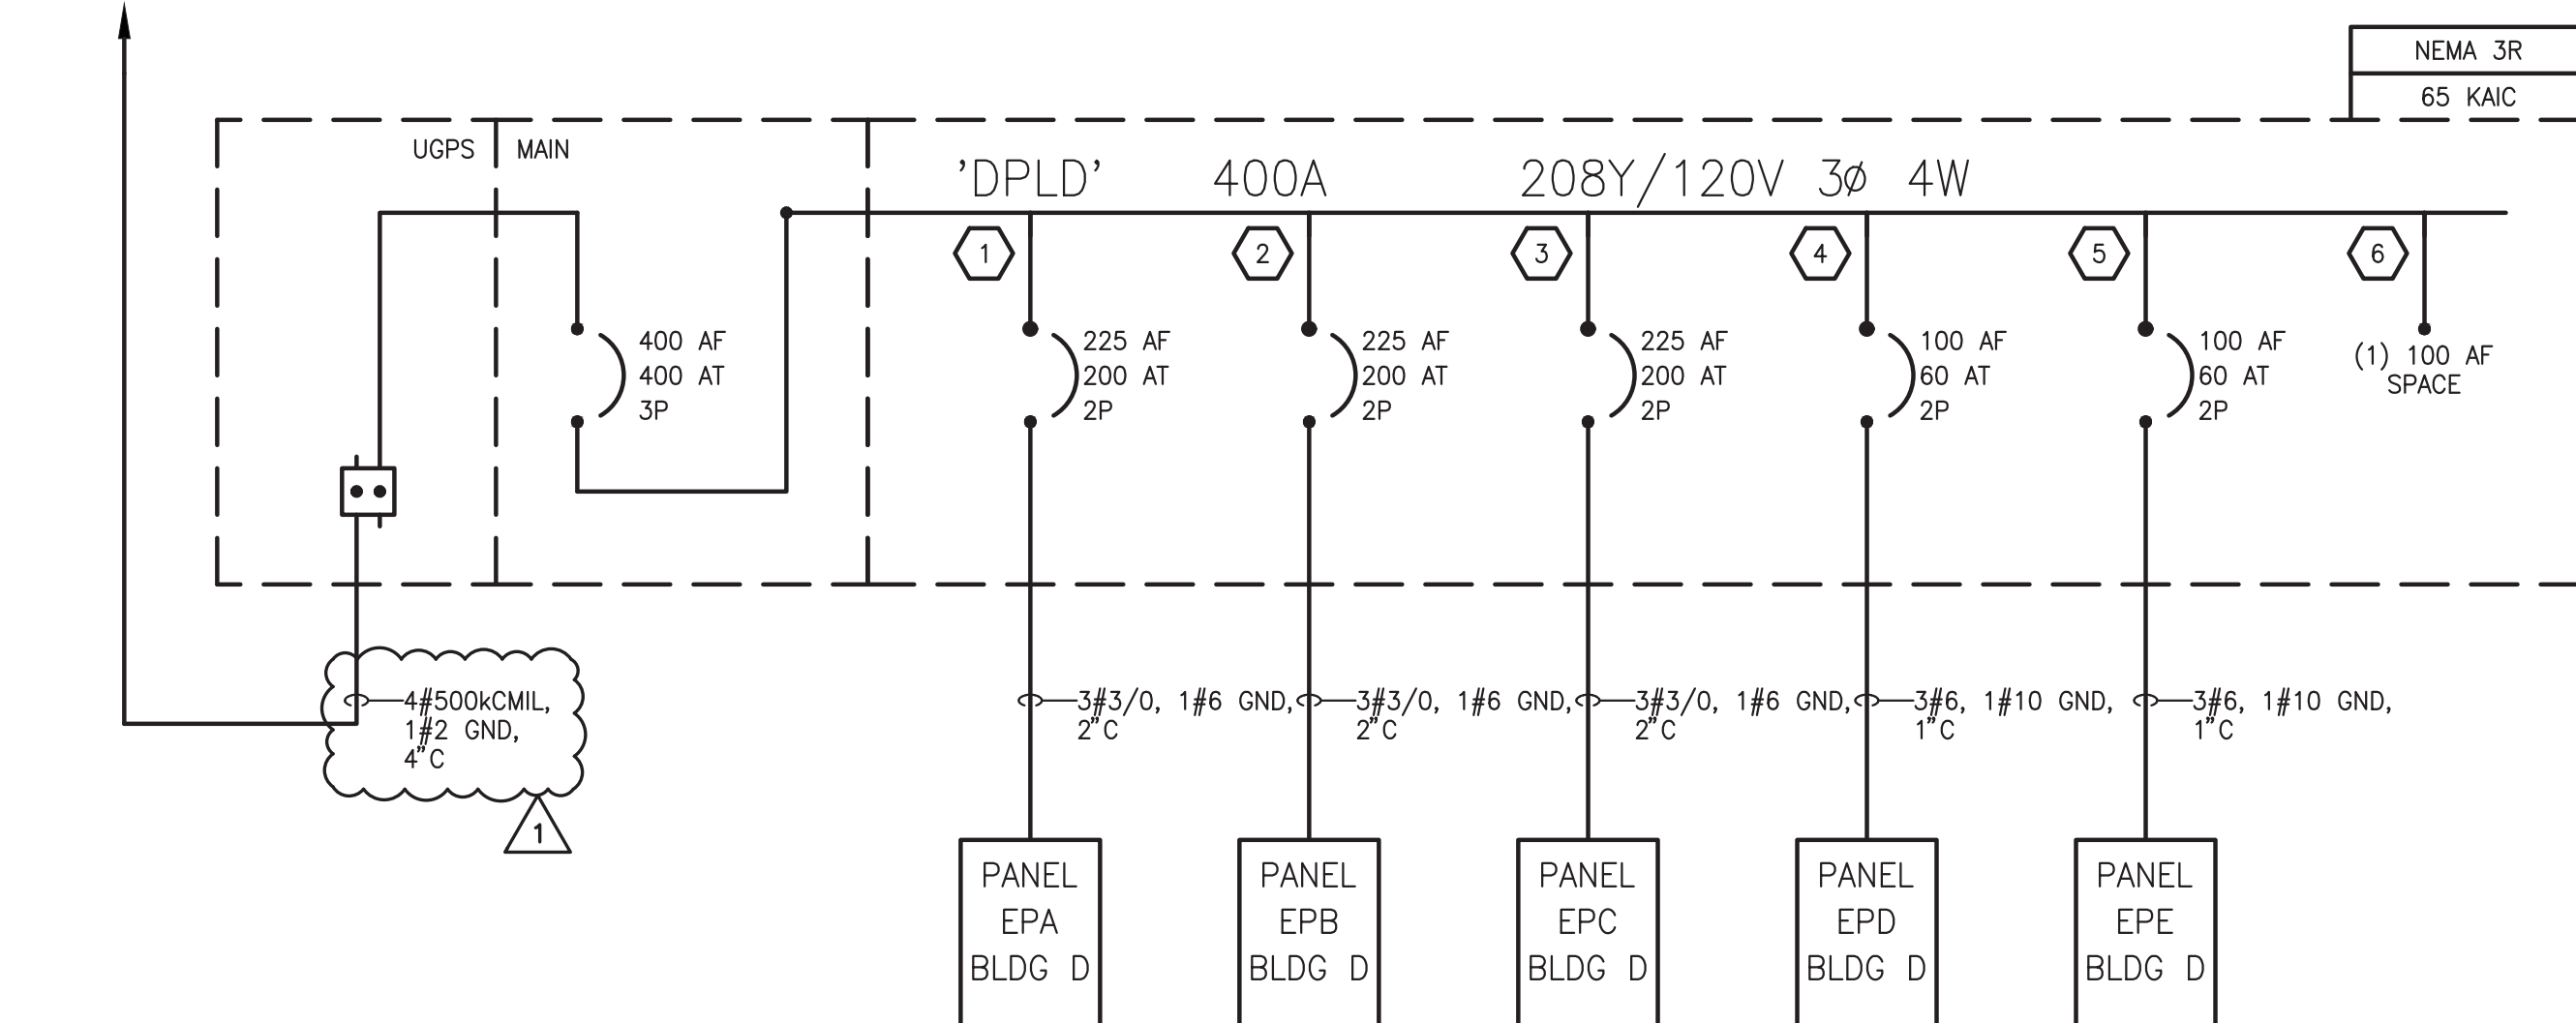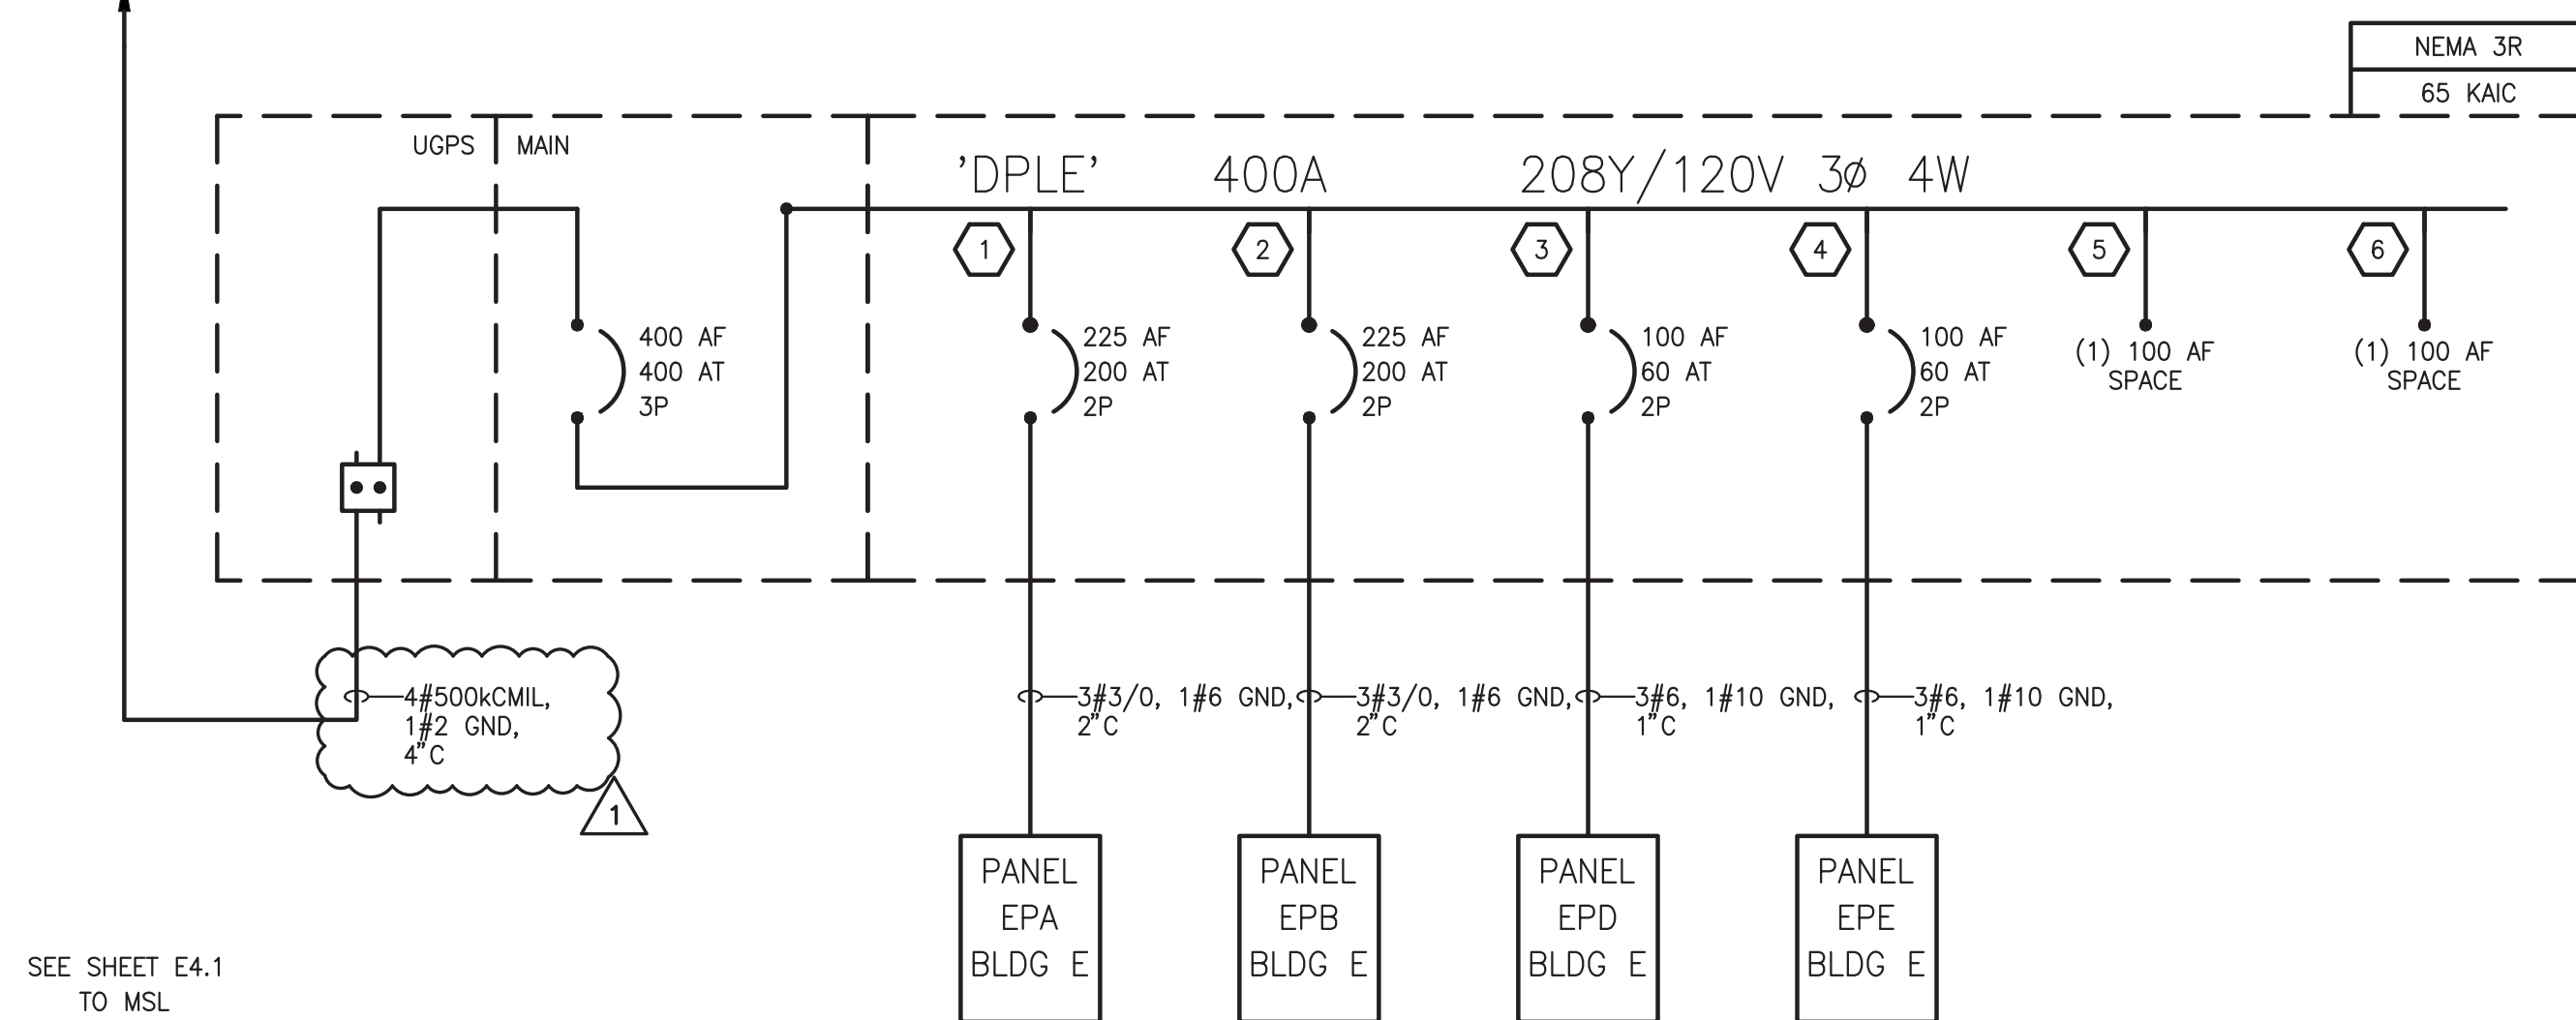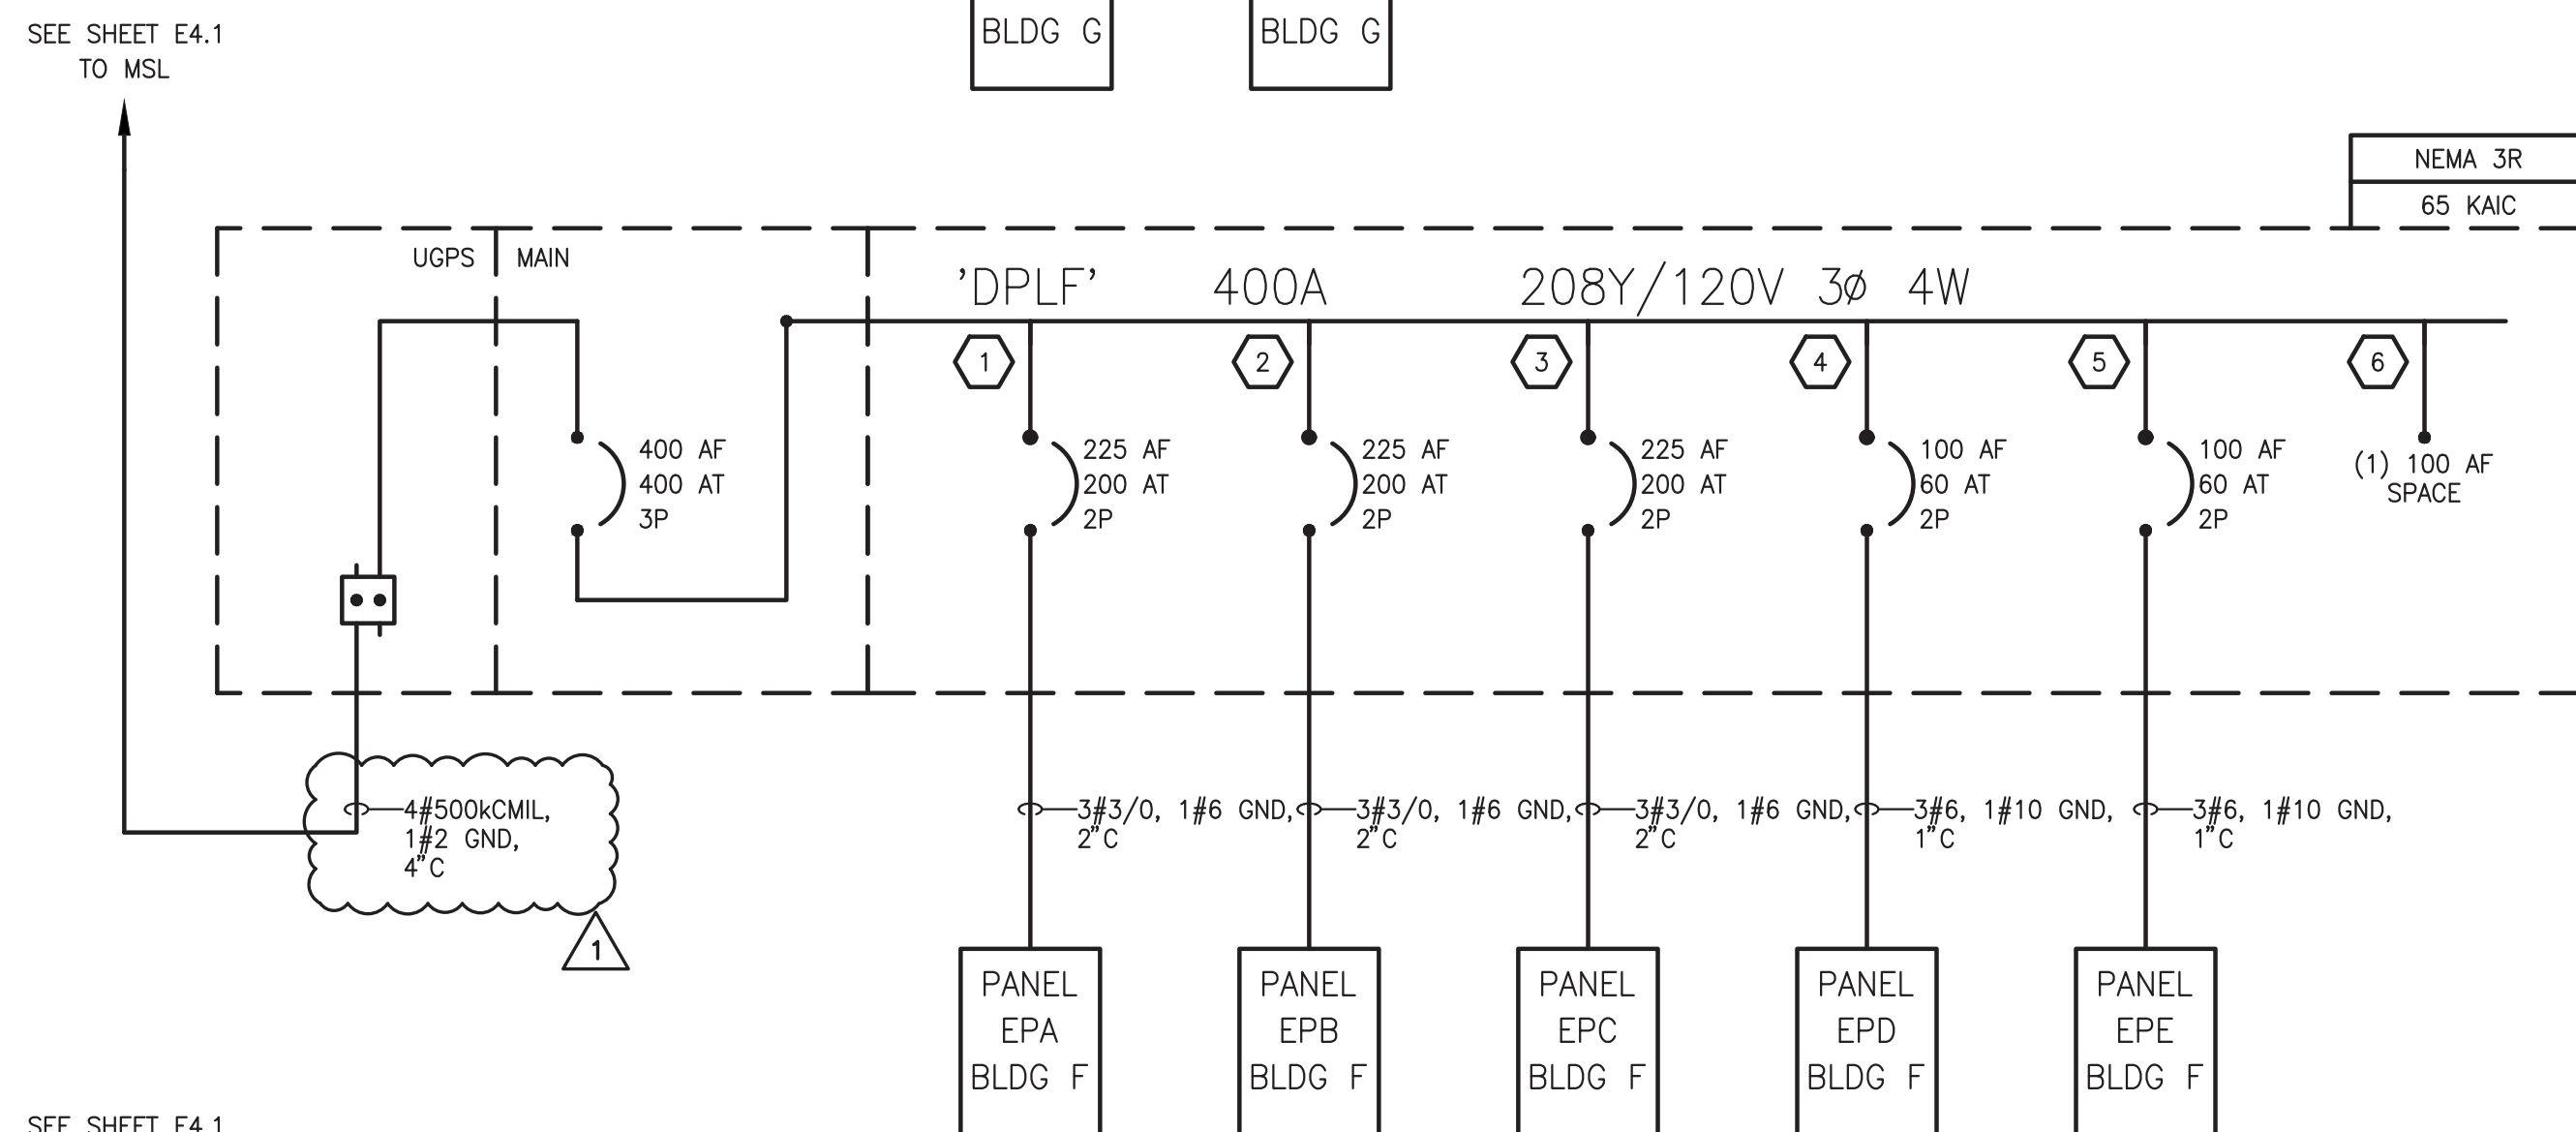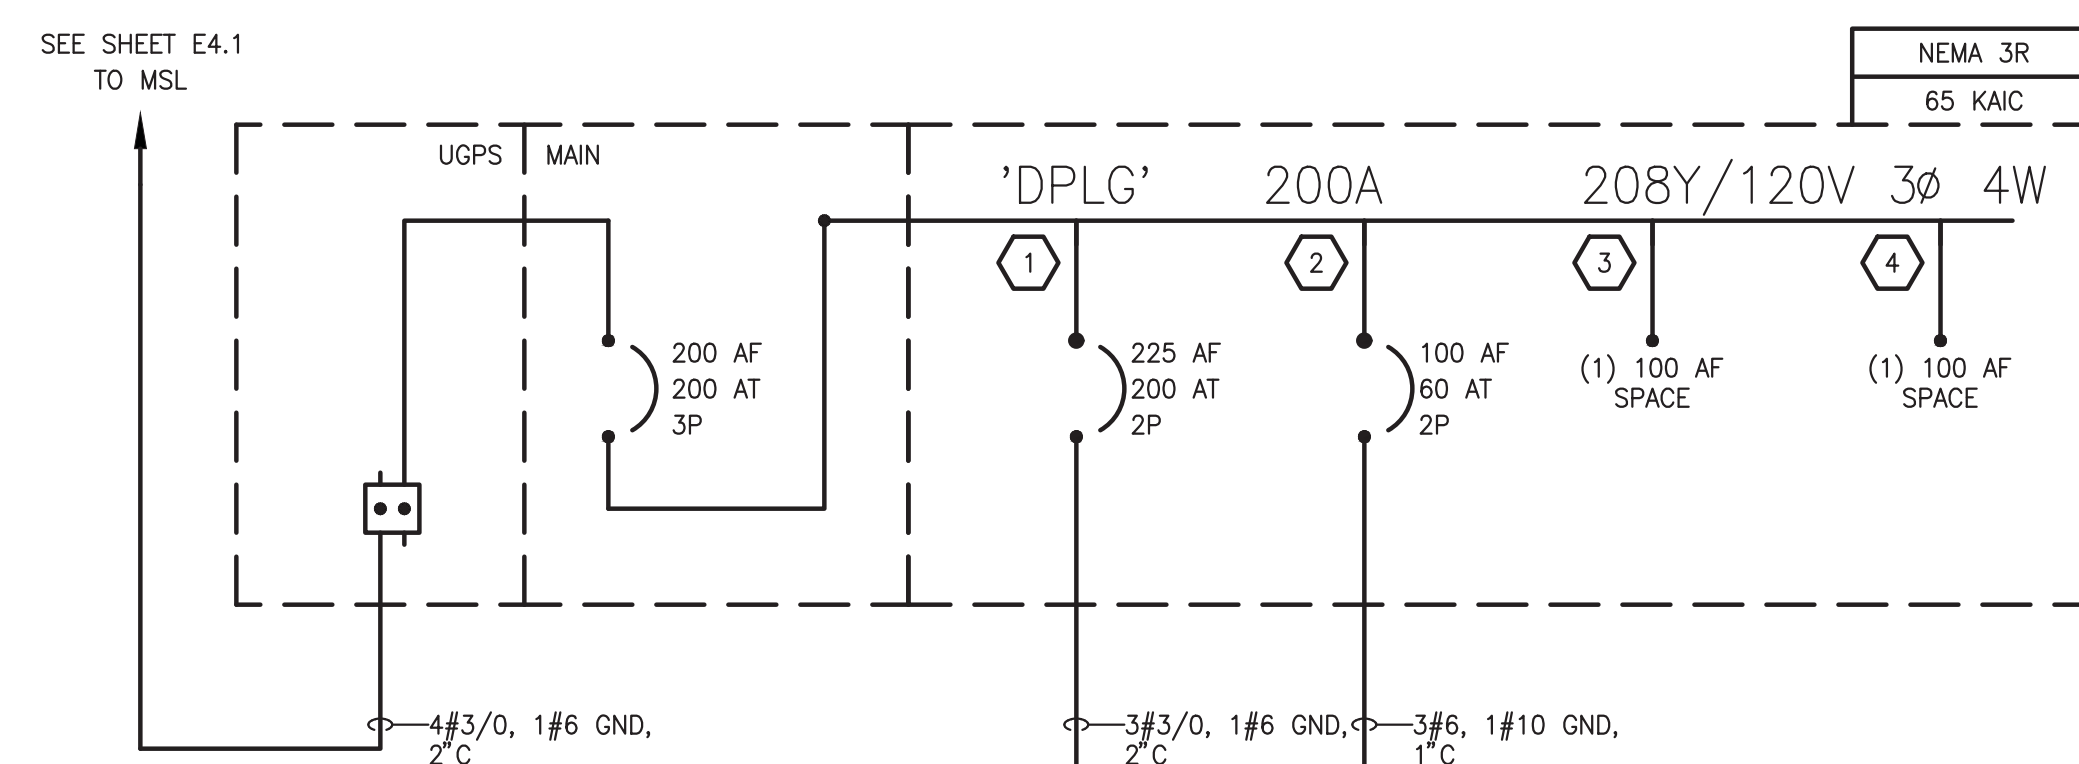

GENERAL NOTES

- A. CONTRACTOR MUST FIELD VERIFY EXISTING CONDITIONS AND COORDINATE WITH ALL OTHER TRADES. IN CASE OF DISCREPANCIES OR ANY POTENTIAL CONFLICTS, INFORM THE ARCHITECT AND ENGINEER IN WRITING PRIOR TO START OF WORK.
- B. ALL WORK SHOWN IS NEW UNLESS NOTED OTHERWISE.

LIONÄKIS

2050 Main Street, Suite 400
Irvine, CA 92614
P 949.955.1919 F 949.955.9175
www.lionakis.com

CONSULTANT



3220 Executive Ridge, Suite 210
Vista, CA 92081
760.560.0100 02-23-26 #2590-00313
 www.salasobrien.com
 E-Mail

SEAL



PROJECT
PALMDALE ELOP CENTER

NE CORNER OF 40th AND Q
PALMDALE, CA

CLIENT PALMDALE SCHOOL DISTRICT

39139 10TH ST E, PALMDALE, CA 93550

ISSUED		
MARK	DATE	DESCRIPTION

MANAGEMENT	
LIONAKIS PROJECT NO:	025112.0
CLIENT PROJECT NO:	
COPYRIGHT:	LIONAKIS 2017

TITLE

SINGLE LINE DIAGRAM
AND LOAD SUMMARY
PHASE 1

SHEET

E4.2

40th Street East

LEGEND:

- EXISTING CENTERLINE
EXISTING RIGHT OF WAY
PROPOSED RIGHT OF WAY
EXISTING PROPERTY LINE
EXISTING CURB AND GUTTER
EXISTING EDGE OF PAVEMENT
EXISTING WATER DISTRIBUTION MAIN
PROPOSED DOMESTIC WATER LINE
EXISTING DOMESTIC WATER LINE
PROPOSED FIRE WATER LINE
EXISTING FIRE WATER LINE
SS PROPOSED SEWER LINE
EXISTING SEWER LINE
SD PROPOSED STORM DRAIN LINE
EXISTING STORM DRAIN LINE
OVH EXISTING OVERHEAD ELECTRIC LINE
PROPOSED REDUCED PRESSURE DETECTOR ASSEMBLY, UTILITY PER PLAN
EXISTING LARGE WATER METER PROVIDED BY PALMDALE WATER DISTRICT PER SIP #XX
PROPOSED FIRE HYDRANT
EXISTING FIRE HYDRANT
PROPOSED WATER VALVE
EXISTING WATER VALVE
PROPOSED POST INDICATOR VALVE
PROPOSED FIRE DEPARTMENT CONNECTION
PROPOSED SEWER MANHOLE
EXISTING SEWER MANHOLE
PROPOSED STORM DRAIN MANHOLE
PROPOSED CLEANOUT

- PROPOSED CURB OPENING CATCH BASIN
PROPOSED DROP INLET
PROPOSED AREA DRAIN
EXISTING LARGE STORM DRAIN
EXISTING STREET LIGHT POLE
EXISTING POWER POLE
EXISTING GUY WIRE ANCHOR
PROPOSED RIP RAP
UTILITY CROSSING SEE TABLE XX, SHEET XX

CONSTRUCTION NOTES

- 1 6" DIP-DCML CLASS 350 WITH PE WRAP
2 8" DIP-DCML CLASS 350 WITH PE WRAP
3 2" HDPE PIPE AND FITTINGS
4 4" HDPE PIPE AND FITTINGS
5 6" HDPE PIPE AND FITTINGS
6 8" HDPE PIPE AND FITTINGS
7 6" DR18 C900 PVC PIPE WITH CL350 DI FITTINGS
8 8" DR18 C900 PVC PIPE WITH CL350 DI FITTINGS
9 PROPOSED 6" GATE VALVE SEE DETAIL 13, SHEET C301
10 PROPOSED 8" GATE VALVE SEE DETAIL 13, SHEET C301
11 PROPOSED 6" USC-APPROVED REDUCED PRESSURE DETECTOR ASSEMBLY
12 PROPOSED 8" USC-APPROVED REDUCED PRESSURE DETECTOR ASSEMBLY
13 PROPOSED THRUST BLOCK SEE DETAIL 11, SHEET C300
14 PROPOSED FIRE DEPARTMENT CONNECTION, SEE DETAIL 1, SHEET C300
15 PROPOSED POST INDICATOR VALVE, SEE DETAIL 2, SHEET C300
16 6" CLOW MODEL 850 FIRE HYDRANT SEE DETAIL 12 & 14, SHEET C301
17 PROPOSED STORM DRAIN MANHOLE SEE DETAIL 10, SHEET C300
18 PROPOSED CURB OPENING CATCH BASIN WITH CONNECTOR PIPE SCREENS SEE DETAIL 16 & 17

MATCHLINE SEE SHEET C202

- 19 PROPOSED 24"x24" DROP INLET SEE DETAIL 8, SHEET C300
20 PROPOSED ROUND AREA DRAIN SEE DETAIL 5, SHEET C300
21 PROPOSED 12" SQUARE AREA DRAIN, SEE DETAIL 4, SHEET C300
22 PROPOSED RIP RAP, SEE DETAIL 6, SHEET C300
23 PROPOSED MITERED DRAIN, SEE DETAIL 9, SHEET C300
24 PROPOSED INFILTRATION BASIN, SEE DETAIL 7, SHEET C300
25 PROPOSED SEWER MANHOLE SEE DETAIL 15, SHEET C301
26 PROPOSED CLEANOUT SEE DETAIL 3, SHEET C300
27 CONNECTION TO BUILDING SPRINKLER SYSTEM, SEE MODULAR PLANS
28 PROPOSED CONNECTION TO EXISTING UTILITY STUB PER WSP####
29 PROPOSED CONNECTION TO SEWER MANHOLE PER SSIP####
30 PROPOSED 4"x2" REDUCER
31 CONNECTION TO FUTURE BUILDING DOWNSPOUT
32 PROPOSED POINT OF CONNECTION FOR FUTURE PHASE

 
GENERAL NOTES:

1. PROPOSED UTILITIES DEPICTED WITHIN PUBLIC RIGHTS OF WAY ARE SHOWN FOR REFERENCE ONLY AND REQUIRE SEPARATE PERMITS. THE CONTRACTOR IS REQUIRED TO OBTAIN THE APPLICABLE CITY, COUNTY, OR CALTRANS ENCROACHMENT PERMIT FOR WATER SYSTEM FACILITIES.
2. THE CONTRACTOR SHALL CONTACT ALL OTHER UTILITIES INCLUDING SBC (661-266-9209), UTI (805-658-7801) FOR SOUTHERN CALIFORNIA EDISON AND ADELPHIA, AND SOUTHERN CALIFORNIA GAS (661-945-7388) FOR LOCATIONS OF THEIR EXISTING AND PROPOSED FACILITIES PRIOR TO EXCAVATIONS IN THIS AREA.
3. WATER METERS ARE TO BE PURCHASED THROUGH PALMDALE WATER DISTRICT.
4. ALL MECHANICAL JOINT FITTINGS FOR DOMESTIC WATER REQUIRE THE USE OF RETAINING GLANDS.
5. CONTRACTOR TO POTHOLE ALL UTILITY CROSSINGS AND TIE-IN POINTS PRIOR TO CONSTRUCTION TO VERIFY LOCATION, DEPTH, AND CONFIGURATION OF EXISTING FACILITIES.
6. PRESSURE REGULATORS ARE REQUIRED FOR ALL SERVICES WHERE SYSTEM PRESSURE MEETS OR EXCEEDS 80 PSI. REGULATORS TO BE MAINTAINED BY PROPERTY OWNER.
7. THE MINIMUM VERTICAL SEPARATION BETWEEN WATER MAIN AND CROSSING UTILITIES OR IMPROVEMENTS IS ONE FOOT. SANITARY SEWER AND STORM DRAIN MUST CROSS BELOW WATER MAIN.
8. APPROVAL OF THIS PLAN BY PALMDALE WATER DISTRICT DOES NOT CONSTITUTE A REPRESENTATION TO THE ACCURACY OF THE LOCATION OR THE EXISTENCE OF ANY UNDERGROUND UTILITY PIPE OR STRUCTURE WITHIN THE LIMITS OF THIS PROJECT.
9. ALL SANITARY SEWERS SHALL REQUIRE VIDEOTAPING PRIOR TO FINAL ACCEPTANCE FOR MAINTENANCE, UNLESS OTHERWISE DETERMINED BY THE PUBLIC WORKS INSPECTOR.

PRIVATE ENGINEER'S NOTICE TO CONTRACTORS:

THE EXISTENCE AND LOCATION OF ANY UNDERGROUND UTILITY PIPES OR STRUCTURES SHOWN ON THESE PLAN ARE OBTAINED BY A SEARCH OF AVAILABLE RECORDS. TO THE BEST OF OUR KNOWLEDGE THERE ARE NO EXISTING UTILITIES EXCEPT AS SHOWN ON THIS PLAN. THE CONTRACTOR IS REQUIRED TO TAKE DUE PRECAUTIONARY MEASURES TO PROTECT THE UTILITY LINES AND ANY OTHER LINES NOT SHOWN ON THIS PLAN. PRIOR TO EXCAVATION, THE CONTRACTOR SHALL CALL 1-800-422-4144 FOR THE UNDERGROUND LOCATION OF UTILITY LINES. THE CONTRACTOR SHALL ALSO CALL THE APPLICABLE UTILITY COMPANIES TO VERIFY THE LOCATIONS.

SCALE: 1" = 20'-0"



MATCHLINE SEE SHEET C201


PALMDALE SCHOOL DISTRICT ELOP CENTER PROJECT
APN 3025-026-001
PALMDALE, CA

UTILITY PLAN

BKF ENGINEERS
30750 S. GARDEN CT.
SUITE 100
NEWPORT BEACH, CA 92660
(949) 526-8460
www.bkf.com

RODRIGO F. ELEJALDE

C 89458

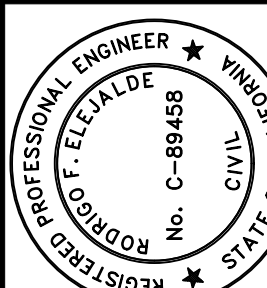

Revisions		No.	Date
			02/04/26
Scale: AS SHOWN		Design: ML/GB	Drawn: ML/GB
Approved: PEE		Job No: 20260779	
Drawing Number:		C200	
5		OF 12	

MATCHLINE SEE SHEET C200

LEGEND:

- EXISTING CENTERLINE
EXISTING RIGHT OF WAY
PROPOSED RIGHT OF WAY
EXISTING PROPERTY LINE
EXISTING CURB AND GUTTER
EXISTING EDGE OF PAVEMENT
EXISTING WATER DISTRIBUTION MAIN
PROPOSED DOMESTIC WATER LINE
EXISTING DOMESTIC WATER LINE
PROPOSED FIRE WATER LINE
EXISTING FIRE WATER LINE
SS PROPOSED SEWER LINE
EXISTING SEWER LINE
SD PROPOSED STORM DRAIN LINE
EXISTING STORM DRAIN LINE
OVH EXISTING OVERHEAD ELECTRIC LINE
PROPOSED REDUCED PRESSURE DETECTOR ASSEMBLY, UTILITY PER PLAN
EXISTING LARGE WATER METER PROVIDED BY PALMDALE WATER DISTRICT PER SIP #XX
PROPOSED FIRE HYDRANT
EXISTING FIRE HYDRANT
PROPOSED WATER VALVE
EXISTING WATER VALVE
PROPOSED POST INDICATOR VALVE
PROPOSED FIRE DEPARTMENT CONNECTION
PROPOSED SEWER MANHOLE
EXISTING SEWER MANHOLE
PROPOSED STORM DRAIN MANHOLE
PROPOSED CLEANOUT

- PROPOSED CURB OPENING CATCH BASIN
PROPOSED DROP INLET
PROPOSED AREA DRAIN
EXISTING LARGE STORM DRAIN
EXISTING STREET LIGHT POLE
EXISTING POWER POLE
EXISTING GUY WIRE ANCHOR
PROPOSED RIP RAP
UTILITY CROSSING SEE TABLE XX, SHEET XX

CONSTRUCTION NOTES

- 1 6" DIP-DCML CLASS 350 WITH PE WRAP
2 8" DIP-DCML CLASS 350 WITH PE WRAP
3 2" HDPE PIPE AND FITTINGS
4 4" HDPE PIPE AND FITTINGS
5 6" HDPE PIPE AND FITTINGS
6 8" HDPE PIPE AND FITTINGS
7 6" DR18 C900 PVC PIPE WITH CL350 DI FITTINGS
8 8" DR18 C900 PVC PIPE WITH CL350 DI FITTINGS
9 PROPOSED 6" GATE VALVE SEE DETAIL 13, SHEET C301
10 PROPOSED 8" GATE VALVE SEE DETAIL 13, SHEET C301
11 PROPOSED 6" USC-APPROVED REDUCED PRESSURE DETECTOR ASSEMBLY
12 PROPOSED 8" USC-APPROVED REDUCED PRESSURE DETECTOR ASSEMBLY
13 PROPOSED THRUST BLOCK SEE DETAIL 11, SHEET C300
14 PROPOSED FIRE DEPARTMENT CONNECTION, SEE DETAIL 1, SHEET C300
15 PROPOSED POST INDICATOR VALVE, SEE DETAIL 2, SHEET C300
16 6" CLOW MODEL 850 FIRE HYDRANT SEE DETAIL 12 & 14, SHEET C301
17 PROPOSED STORM DRAIN MANHOLE SEE DETAIL 10, SHEET C300
18 PROPOSED CURB OPENING CATCH BASIN WITH CONNECTOR PIPE SCREENS SEE DETAIL 16 & 17


- 19 PROPOSED 24"x24" DROP INLET SEE DETAIL 8, SHEET C300
20 PROPOSED ROUND AREA DRAIN SEE DETAIL 5, SHEET C300
21 PROPOSED 12" SQUARE AREA DRAIN, SEE DETAIL 4, SHEET C300
22 PROPOSED RIP RAP, SEE DETAIL 6, SHEET C300
23 PROPOSED MITERED DRAIN, SEE DETAIL 9, SHEET C300
24 PROPOSED INFILTRATION BASIN, SEE DETAIL 7, SHEET C300
25 PROPOSED SEWER MANHOLE SEE DETAIL 15, SHEET C301
26 PROPOSED CLEANOUT SEE DETAIL 3, SHEET C300
27 CONNECTION TO BUILDING SPRINKLER SYSTEM, SEE MODULAR PLANS
28 PROPOSED CONNECTION TO EXISTING UTILITY STUB PER WSP####
29 PROPOSED CONNECTION TO SEWER MANHOLE PER SSP####
30 PROPOSED 4"x2" REDUCER
31 CONNECTION TO FUTURE BUILDING DOWNSPOUT
32 PROPOSED POINT OF CONNECTION FOR FUTURE PHASE

GENERAL NOTES:


1. PROPOSED UTILITIES DEPICTED WITHIN PUBLIC RIGHTS OF WAY ARE SHOWN FOR REFERENCE ONLY AND REQUIRE SEPARATE PERMITS. THE CONTRACTOR IS REQUIRED TO OBTAIN THE APPLICABLE CITY, COUNTY, OR CALTRANS ENCROACHMENT PERMIT FOR WATER SYSTEM FACILITIES.
2. THE CONTRACTOR SHALL CONTACT ALL OTHER UTILITIES INCLUDING SBC (661-266-9209), UTL (805-658-7801) FOR SOUTHERN CALIFORNIA EDISON AND ADELPHIA, AND SOUTHERN CALIFORNIA GAS (661-945-7388) FOR LOCATIONS OF THEIR EXISTING AND PROPOSED FACILITIES PRIOR TO EXCAVATIONS IN THIS AREA.
3. WATER METERS ARE TO BE PURCHASED THROUGH PALMDALE WATER DISTRICT.
4. ALL MECHANICAL JOINT FITTINGS FOR DOMESTIC WATER REQUIRE THE USE OF RETAINING GLANDS.
5. CONTRACTOR TO POTHOLE ALL UTILITY CROSSINGS AND TIE-IN POINTS PRIOR TO CONSTRUCTION TO VERIFY LOCATION, DEPTH, AND CONFIGURATION OF EXISTING FACILITIES.
6. PRESSURE REGULATORS ARE REQUIRED FOR ALL SERVICES WHERE SYSTEM PRESSURE MEETS OR EXCEEDS 80 PSI. REGULATORS TO BE MAINTAINED BY PROPERTY OWNER.
7. THE MINIMUM VERTICAL SEPARATION BETWEEN WATER MAIN AND CROSSING UTILITIES OR IMPROVEMENTS IS ONE FOOT. SANITARY SEWER AND STORM DRAIN MUST CROSS BELOW WATER MAIN.
8. APPROVAL OF THIS PLAN BY PALMDALE WATER DISTRICT DOES NOT CONSTITUTE A REPRESENTATION TO THE ACCURACY OF THE LOCATION OR THE EXISTENCE OF ANY UNDERGROUND UTILITY PIPE OR STRUCTURE WITHIN THE LIMITS OF THIS PROJECT.
9. ALL SANITARY SEWERS SHALL REQUIRE VIDEOTAPING PRIOR TO FINAL ACCEPTANCE FOR MAINTENANCE, UNLESS OTHERWISE DETERMINED BY THE PUBLIC WORKS INSPECTOR.

PRIVATE ENGINEER'S NOTICE TO CONTRACTORS:

THE EXISTENCE AND LOCATION OF ANY UNDERGROUND UTILITY PIPES OR STRUCTURES SHOWN ON THESE PLANS ARE OBTAINED BY A SEARCH OF AVAILABLE RECORDS. TO THE BEST OF OUR KNOWLEDGE THERE ARE NO EXISTING UTILITIES EXCEPT AS SHOWN ON THIS PLAN. THE CONTRACTOR IS REQUIRED TO TAKE DUE PRECAUTIONARY MEASURES TO PROTECT THE UTILITY LINES AND ANY OTHER LINES NOT SHOWN ON THIS PLAN. PRIOR TO EXCAVATION, THE CONTRACTOR SHALL CALL 1-800-422-4144 FOR THE UNDERGROUND LOCATION OF UTILITY LINES. THE CONTRACTOR SHALL ALSO CALL THE APPLICABLE UTILITY COMPANIES TO VERIFY THE LOCATIONS.

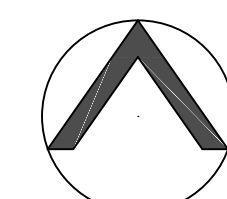

SCALE: 1" = 20'-0"

 

MATCHLINE SEE SHEET C203

Coordinate FW Add Alt#1 POC
cost to interconnect with PRIMARY
PLAN SET - C-700 Future POC

This Infrastructure
is NIC.

Realign Domestic Water for
Primary Plan set as shown

Cap SD here. Do
not extend further.

MATCHLINE SEE SHEET C200

MATCHLINE SEE SHEET C203

LEGEND:

- EXISTING CENTERLINE
EXISTING RIGHT OF WAY
PROPOSED RIGHT OF WAY
EXISTING PROPERTY LINE
EXISTING CURB AND GUTTER
EXISTING EDGE OF PAVEMENT
EXISTING WATER DISTRIBUTION MAIN
PROPOSED DOMESTIC WATER LINE
EXISTING DOMESTIC WATER LINE
PROPOSED FIRE WATER LINE
EXISTING FIRE WATER LINE
PROPOSED SEWER LINE
EXISTING SEWER LINE
PROPOSED STORM DRAIN LINE
EXISTING STORM DRAIN LINE
EXISTING OVERHEAD ELECTRIC LINE
PROPOSED REDUCED PRESSURE DETECTOR ASSEMBLY, UTILITY PER PLAN
EXISTING LARGE WATER METER PROVIDED BY PALMDALE WATER DISTRICT PER SIP #XX
PROPOSED FIRE HYDRANT
EXISTING FIRE HYDRANT
PROPOSED WATER VALVE
EXISTING WATER VALVE
PROPOSED POST INDICATOR VALVE
PROPOSED FIRE DEPARTMENT CONNECTION
PROPOSED SEWER MANHOLE
EXISTING SEWER MANHOLE
PROPOSED STORM DRAIN MANHOLE
PROPOSED CLEANOUT

- PROPOSED CURB OPENING CATCH BASIN
PROPOSED DROP INLET
PROPOSED AREA DRAIN
EXISTING LARGE STORM DRAIN
EXISTING STREET LIGHT POLE
EXISTING POWER POLE
EXISTING GUY WIRE ANCHOR
PROPOSED RIP RAP
UTILITY CROSSING SEE TABLE XX, SHEET XX

CONSTRUCTION NOTES

- 1 6" DIP-DCML CLASS 350 WITH PE WRAP
2 8" DIP-DCML CLASS 350 WITH PE WRAP
3 2" HDPE PIPE AND FITTINGS
4 4" HDPE PIPE AND FITTINGS
5 6" HDPE PIPE AND FITTINGS
6 8" HDPE PIPE AND FITTINGS
7 6" DR18 C900 PVC PIPE WITH CL350 DI FITTINGS
8 8" DR18 C900 PVC PIPE WITH CL350 DI FITTINGS
9 PROPOSED 6" GATE VALVE SEE DETAIL 13, SHEET C301
10 PROPOSED 8" GATE VALVE SEE DETAIL 13, SHEET C301
11 PROPOSED 6" USC-APPROVED REDUCED PRESSURE DETECTOR ASSEMBLY
12 PROPOSED 8" USC-APPROVED REDUCED PRESSURE DETECTOR ASSEMBLY
13 PROPOSED THRUST BLOCK SEE DETAIL 11, SHEET C300
14 PROPOSED FIRE DEPARTMENT CONNECTION, SEE DETAIL 1, SHEET C300
15 PROPOSED POST INDICATOR VALVE, SEE DETAIL 2, SHEET C300
16 6" CLOW MODEL 850 FIRE HYDRANT SEE DETAIL 12 & 14, SHEET C301
17 PROPOSED STORM DRAIN MANHOLE SEE DETAIL 10, SHEET C300
18 PROPOSED CURB OPENING CATCH BASIN WITH CONNECTOR PIPE SCREENS SEE DETAIL 16 & 17

- 19 PROPOSED 24"x24" DROP INLET SEE DETAIL 8, SHEET C300
20 PROPOSED ROUND AREA DRAIN SEE DETAIL 5, SHEET C300
21 PROPOSED 12" SQUARE AREA DRAIN, SEE DETAIL 4, SHEET C300
22 PROPOSED RIP RAP, SEE DETAIL 6, SHEET C300
23 PROPOSED MITERED DRAIN, SEE DETAIL 3, SHEET C300
24 PROPOSED INFILTRATION BASIN, SEE DETAIL 7, SHEET C300
25 PROPOSED SEWER MANHOLE SEE DETAIL 15, SHEET C301
26 PROPOSED CLEANOUT SEE DETAIL 3, SHEET C300
27 CONNECTION TO BUILDING SPRINKLER SYSTEM, SEE MODULAR PLANS
28 PROPOSED CONNECTION TO EXISTING UTILITY STUB PER WSP####
29 PROPOSED CONNECTION TO SEWER MANHOLE PER SSIP####
30 PROPOSED 4"x2" REDUCER
31 CONNECTION TO FUTURE BUILDING DOWNSPOUT
32 PROPOSED POINT OF CONNECTION FOR FUTURE PHASE


 
GENERAL NOTES:

1. PROPOSED UTILITIES DEPICTED WITHIN PUBLIC RIGHTS OF WAY ARE SHOWN FOR REFERENCE ONLY AND REQUIRE SEPARATE PERMITS. THE CONTRACTOR IS REQUIRED TO OBTAIN THE APPLICABLE CITY, COUNTY, OR CALTRANS ENCROACHMENT PERMIT FOR WATER SYSTEM FACILITIES.
2. THE CONTRACTOR SHALL CONTACT ALL OTHER UTILITIES INCLUDING SBC (661-266-9209), UTLI (805-658-7801) FOR SOUTHERN CALIFORNIA EDISON AND ADELPHIA, AND SOUTHERN CALIFORNIA GAS (661-945-7388) FOR LOCATIONS OF THEIR EXISTING AND PROPOSED FACILITIES PRIOR TO EXCAVATIONS IN THIS AREA.
3. WATER METERS ARE TO BE PURCHASED THROUGH PALMDALE WATER DISTRICT.
4. ALL MECHANICAL JOINT FITTINGS FOR DOMESTIC WATER REQUIRE THE USE OF RETAINING GLANDS.
5. CONTRACTOR TO POTHOLE ALL UTILITY CROSSINGS AND TIE-IN POINTS PRIOR TO CONSTRUCTION TO VERIFY LOCATION, DEPTH, AND CONFIGURATION OF EXISTING FACILITIES.
6. PRESSURE REGULATORS ARE REQUIRED FOR ALL SERVICES WHERE SYSTEM PRESSURE MEETS OR EXCEEDS 80 PSI. REGULATORS TO BE MAINTAINED BY PROPERTY OWNER.
7. THE MINIMUM VERTICAL SEPARATION BETWEEN WATER MAIN AND CROSSING UTILITIES OR IMPROVEMENTS IS ONE FOOT. SANITARY SEWER AND STORM DRAIN MUST CROSS BELOW WATER MAIN.
8. APPROVAL OF THIS PLAN BY PALMDALE WATER DISTRICT DOES NOT CONSTITUTE A REPRESENTATION TO THE ACCURACY OF THE LOCATION OR THE EXISTENCE OF ANY UNDERGROUND UTILITY PIPE OR STRUCTURE WITHIN THE LIMITS OF THIS PROJECT.
9. ALL SANITARY SEWERS SHALL REQUIRE VIDEOTAPING PRIOR TO FINAL ACCEPTANCE FOR MAINTENANCE, UNLESS OTHERWISE DETERMINED BY THE PUBLIC WORKS INSPECTOR.

PRIVATE ENGINEER'S NOTICE TO CONTRACTORS:

THE EXISTENCE AND LOCATION OF ANY UNDERGROUND UTILITY PIPES OR STRUCTURES SHOWN ON THESE PLANS ARE OBTAINED BY A SEARCH OF AVAILABLE RECORDS. TO THE BEST OF OUR KNOWLEDGE THERE ARE NO EXISTING UTILITIES EXCEPT AS SHOWN ON THIS PLAN. THE CONTRACTOR IS REQUIRED TO TAKE DUE PRECAUTIONARY MEASURES TO PROTECT THE UTILITY LINES AND ANY OTHER LINES NOT SHOWN ON THIS PLAN. PRIOR TO EXCAVATION, THE CONTRACTOR SHALL CALL 1-800-422-4144 FOR THE UNDERGROUND LOCATION OF UTILITY LINES. THE CONTRACTOR SHALL ALSO CALL THE APPLICABLE UTILITY COMPANIES TO VERIFY THE LOCATIONS.

SCALE: 1" = 20'-0"

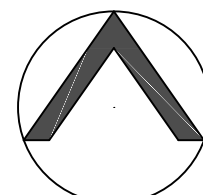

PALMDALE SCHOOL DISTRICT ELOP CENTER PROJECT

APN 3025-026-001
PALMDALE, CA

UTILITY PLAN

BKF ENGINEERS
30750 S. CARLISLE CT.
SUITE 100
NEWPORT BEACH, CA 92660
(949) 526-8460
www.bkf.com

PROFESSIONAL ENGINEER
REGISTERED
No. C-89458
CUL
STATE OF CALIF.


Rodrigo F. Elejalde
RODRIGO F. ELEJALDE
C 89458

Revisions	No.	Date	By	Appr.
		02/04/26	AS SHOWN	
			Design: ML/B	
			Drawn: ML/B	
			Approved: PEE	
			Job No: 20262779	

C202

7 OF 12

MATCHLINE SEE SHEET C201

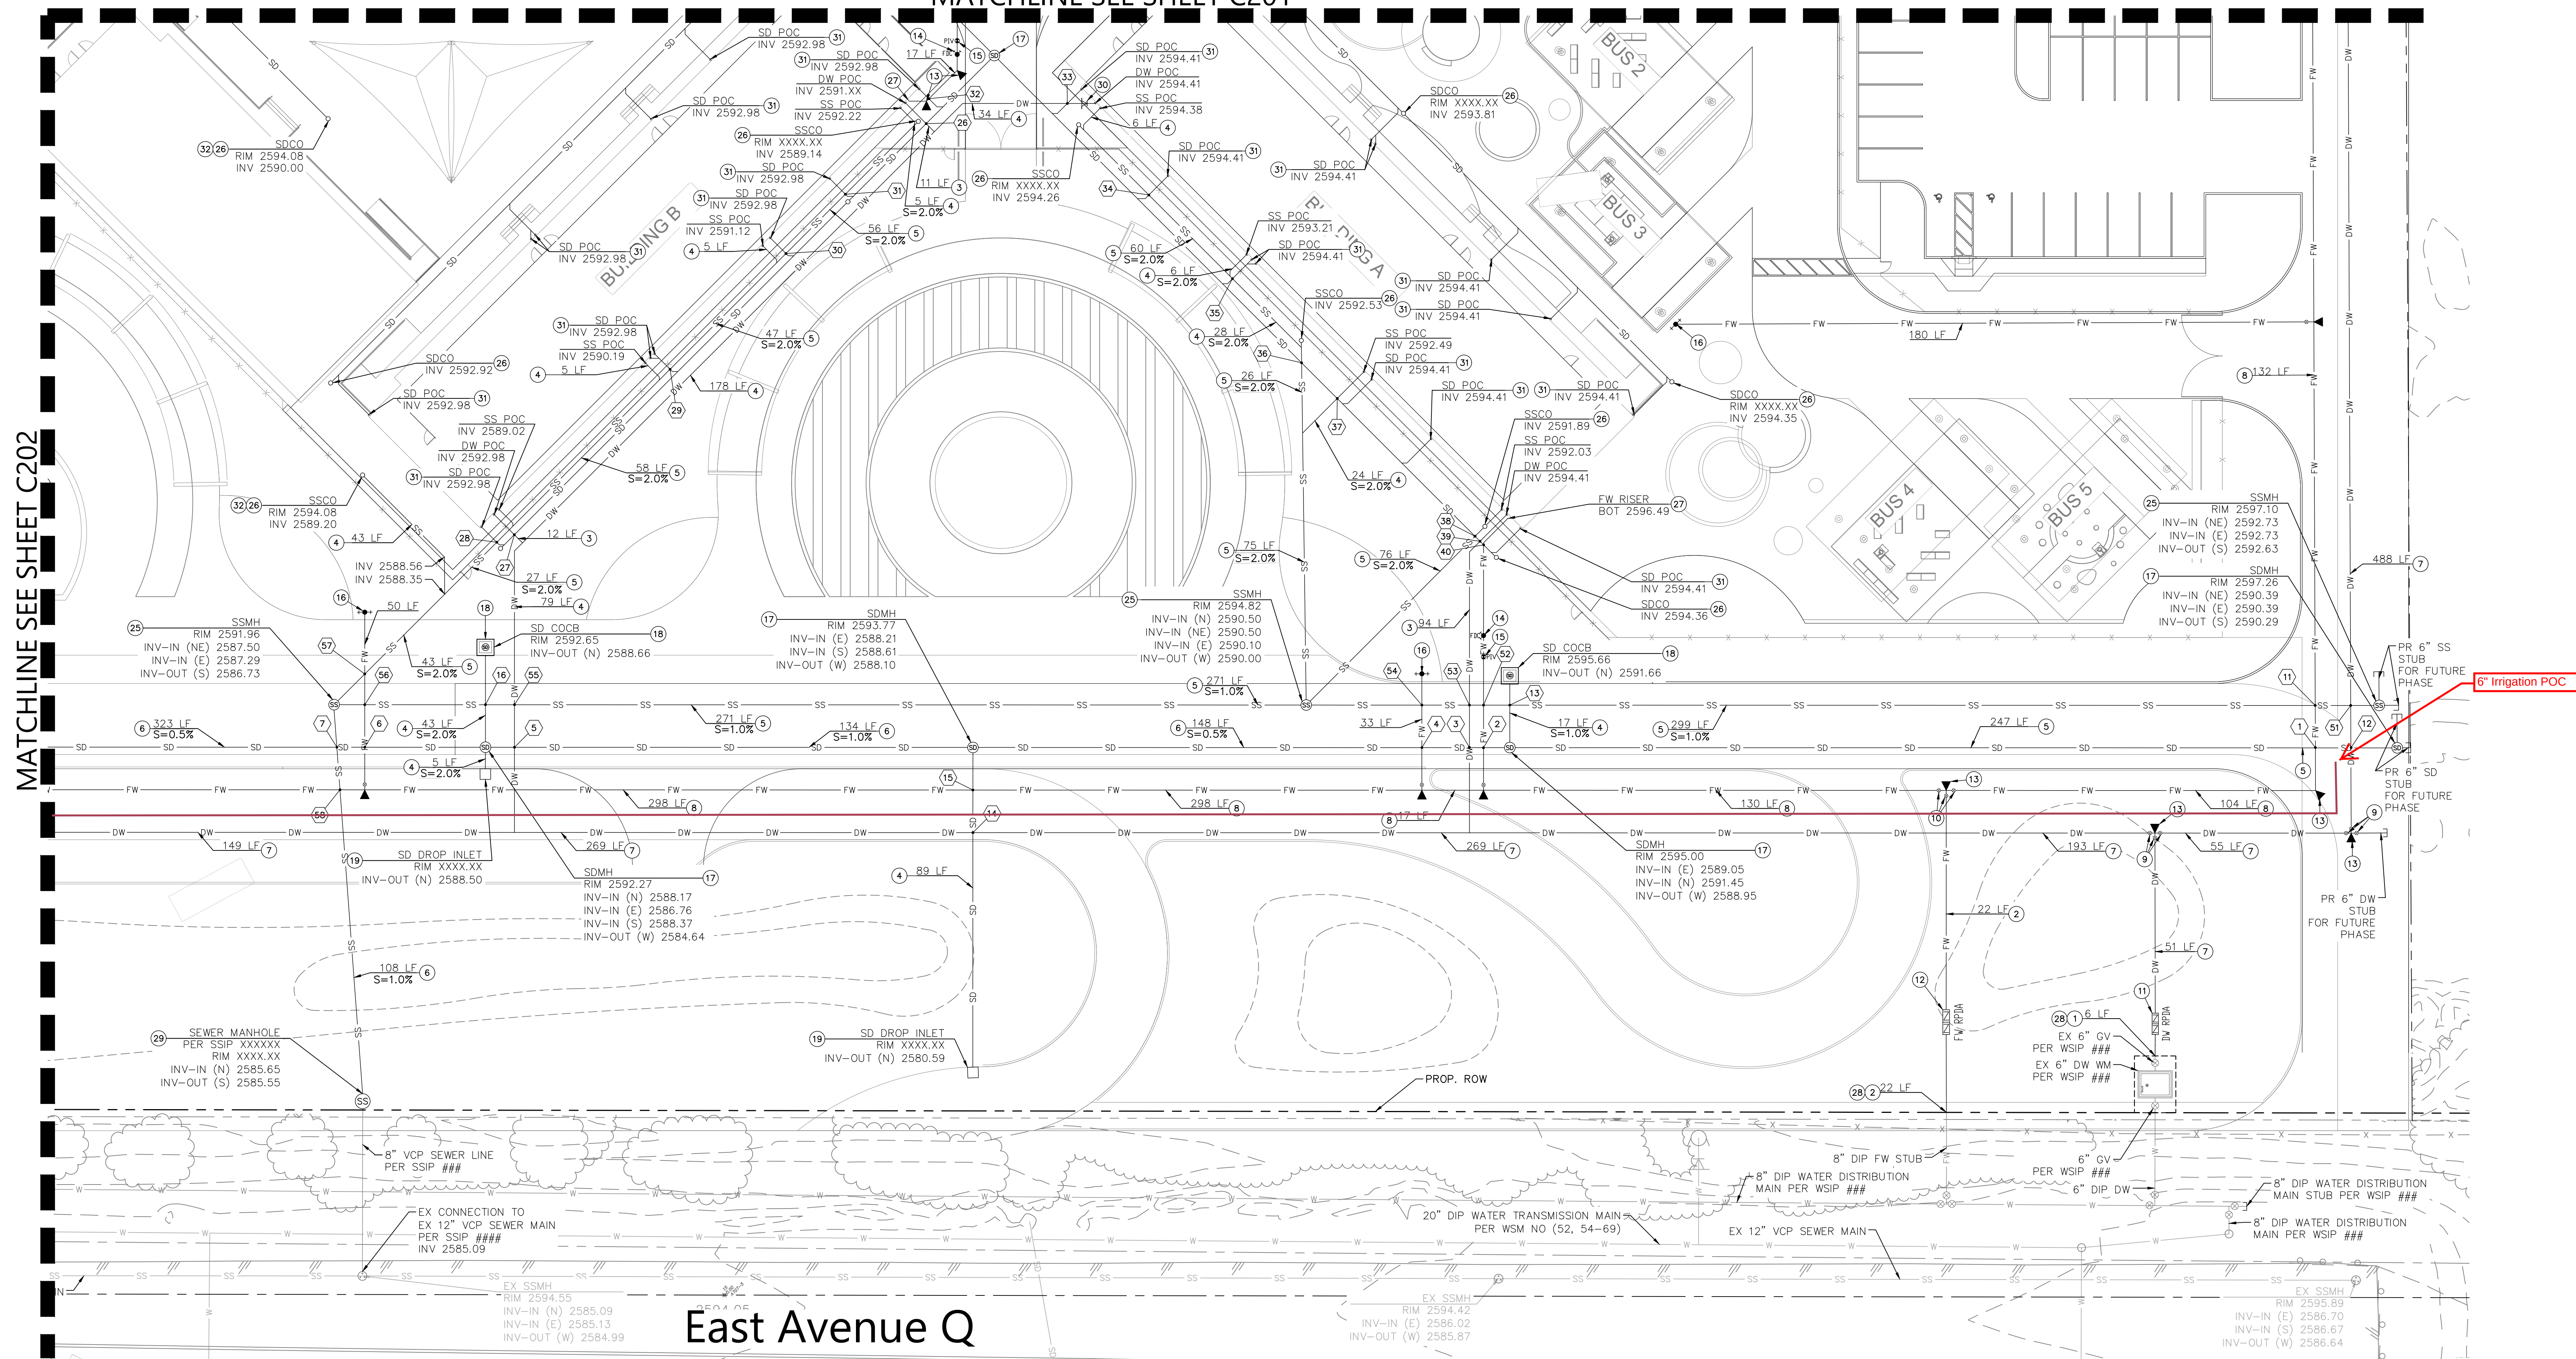

LEGEND:

- | | | | |
|--|--|--|---|
| | EXISTING CENTERLINE | | PROPOSED CURB OPENING CATCH BASIN |
| | EXISTING RIGHT OF WAY | | PROPOSED DROP INLET |
| | PROPOSED RIGHT OF WAY | | PROPOSED AREA DRAIN |
| | EXISTING PROPERTY LINE | | EXISTING LARGE STORM DRAIN |
| | EXISTING CURB AND GUTTER | | EXISTING STREET LIGHT POLE |
| | EXISTING FCB OF PAVEMENT | | EXISTING POWER POLE |
| | EXISTING WATER DISTRIBUTION MAIN | | EXISTING GUY WIRE ANCHOR |
| | PROPOSED DOMESTIC WATER LINE | | PROPOSED RIP RAP |
| | EXISTING DOMESTIC WATER LINE | | UTILITY CROSSING SEE TABLE XX, SHEET XX |
| | PROPOSED FIRE WATER LINE | | |
| | EXISTING FIRE WATER LINE | | |
| | PROPOSED SEWER LINE | | |
| | EXISTING SEWER LINE | | |
| | PROPOSED STORM DRAIN LINE | | |
| | EXISTING STORM DRAIN LINE | | |
| | EXISTING OVERHEAD ELECTRIC LINE | | |
| | PROPOSED REDUCED PRESSURE DETECTOR ASSEMBLY, UTILITY PER PLAN | | |
| | EXISTING LARGE WATER METER PROVIDED BY PALMDALE WATER DISTRICT PER SIP #XX | | |
| | PROPOSED FIRE HYDRANT | | |
| | EXISTING FIRE HYDRANT | | |
| | PROPOSED WATER VALVE | | |
| | EXISTING WATER VALVE | | |
| | PROPOSED POST INDICATOR VALVE | | |
| | PROPOSED FIRE DEPARTMENT CONNECTION | | |
| | PROPOSED SEWER MANHOLE | | |
| | EXISTING SEWER MANHOLE | | |
| | PROPOSED STORM DRAIN MANHOLE | | |
| | PROPOSED CLEANOUT | | |

CONSTRUCTION NOTES


- | | | | |
|---|--|---|--|
| ① | 6" DIP-DCML CLASS 350 WITH PE WRAP | ⑩ | PROPOSED 24"x24" DROP INLET SEE DETAIL 8, SHEET C300 |
| ② | 8" DIP-DCML CLASS 350 WITH PE WRAP | ⑪ | PROPOSED ROUND AREA DRAIN SEE DETAIL 5, SHEET C300 |
| ③ | 2" HDPE PIPE AND FITTINGS | ⑫ | PROPOSED 12" SQUARE AREA DRAIN, SEE DETAIL 4, SHEET C300 |
| ④ | 4" HDPE PIPE AND FITTINGS | ⑬ | PROPOSED RIP RAP, SEE DETAIL 6, SHEET C300 |
| ⑤ | 6" HDPE PIPE AND FITTINGS | ⑭ | PROPOSED MITERED DRAIN, SEE DETAIL 9, SHEET C300 |
| ⑥ | 8" HDPE PIPE AND FITTINGS | ⑮ | PROPOSED INFILTRATION BASIN, SEE DETAIL 7, SHEET C300 |
| ⑦ | 6" DR18 C900 PVC PIPE WITH CL350 DI FITTINGS | ⑯ | PROPOSED SEWER MANHOLE SEE DETAIL 15, SHEET C301 |
| ⑧ | 8" DR18 C900 PVC PIPE WITH CL350 DI FITTINGS | ⑰ | PROPOSED CLEANOUT SEE DETAIL 3, SHEET C300 |
| ⑨ | PROPOSED 6" GATE VALVE SEE DETAIL 13, SHEET C301 | ⑱ | CONNECTION TO BUILDING SPRINKLER SYSTEM, SEE MODULAR PLANS |
| ⑪ | PROPOSED 8" GATE VALVE SEE DETAIL 13, SHEET C301 | ⑳ | PROPOSED CONNECTION TO EXISTING UTILITY STUB PER WSIP#### |
| ⑫ | PROPOSED 6" USC-APPROVED REDUCED PRESSURE DETECTOR ASSEMBLY | ㉑ | PROPOSED CONNECTION TO SEWER MANHOLE PER SSIIP#### |
| ⑬ | PROPOSED 8" USC-APPROVED REDUCED PRESSURE DETECTOR ASSEMBLY | ㉒ | PROPOSED 4"x2" REDUCER |
| ⑭ | PROPOSED THRUST BLOCK SEE DETAIL 11, SHEET C300 | ㉓ | CONNECTION TO FUTURE BUILDING DOWNSPOUT |
| ⑮ | PROPOSED FIRE DEPARTMENT CONNECTION, SEE DETAIL 1, SHEET C300 | ㉔ | PROPOSED POINT OF CONNECTION FOR FUTURE PHASE |
| ⑯ | PROPOSED POST INDICATOR VALVE, SEE DETAIL 2, SHEET C300 | | |
| ⑰ | 6" CLOW MODEL 850 FIRE HYDRANT SEE DETAIL 12 & 14, SHEET C301 | | |
| ⑱ | PROPOSED STORM DRAIN MANHOLE SEE DETAIL 10, SHEET C300 | | |
| ㉑ | PROPOSED CURB OPENING CATCH BASIN WITH CONNECTOR PIPE SCREENS SEE DETAIL 16 & 17 | | |

GENERAL NOTES:

1. PROPOSED UTILITIES DEPICTED WITHIN PUBLIC RIGHTS OF WAY ARE SHOWN FOR REFERENCE ONLY AND REQUIRE SEPARATE PERMITS. THE CONTRACTOR IS REQUIRED TO OBTAIN THE APPLICABLE CITY, COUNTY, OR CALTRANS ENCROACHMENT PERMIT FOR WATER SYSTEM FACILITIES.
2. THE CONTRACTOR SHALL CONTACT ALL OTHER UTILITIES INCLUDING SBC (661-266-9209), UTL (805-658-7801) FOR SOUTHERN CALIFORNIA EDISON AND ADELPHI, AND SOUTHERN CALIFORNIA GAS (661-945-7388) FOR LOCATIONS OF THEIR EXISTING AND PROPOSED FACILITIES PRIOR TO EXCAVATIONS IN THIS AREA.
3. WATER METERS ARE TO BE PURCHASED THROUGH PALMDALE WATER DISTRICT.
4. ALL MECHANICAL JOINT FITTINGS FOR DOMESTIC WATER REQUIRE THE USE OF RETAINING GLANDS.
5. CONTRACTOR TO POTHOLE ALL UTILITY CROSSINGS AND RE-IN POINTS PRIOR TO CONSTRUCTION TO VERIFY LOCATION, DEPTH, AND CONFIGURATION OF EXISTING FACILITIES.
6. PRESSURE REGULATORS ARE REQUIRED FOR ALL SERVICES WHERE SYSTEM PRESSURE MEETS OR EXCEEDS 80 PSI. REGULATORS TO BE MAINTAINED BY PROPERTY OWNER.
7. THE MINIMUM VERTICAL SEPARATION BETWEEN WATER MAIN AND CROSSING UTILITIES OR IMPROVEMENTS IS ONE FOOT. SANITARY SEWER AND STORM DRAIN MUST CROSS BELOW WATER MAIN.
8. APPROVAL OF THIS PLAN BY PALMDALE WATER DISTRICT DOES NOT CONSTITUTE A REPRESENTATION TO THE ACCURACY OF THE LOCATION OR THE EXISTENCE OF ANY UNDERGROUND UTILITY PIPE OR STRUCTURE WITHIN THE LIMITS OF THIS PROJECT.
9. ALL SANITARY SEWERS SHALL REQUIRE VIDEO TAPING PRIOR TO FINAL ACCEPTANCE FOR MAINTENANCE, UNLESS OTHERWISE DETERMINED BY THE PUBLIC WORKS INSPECTOR.

PRIVATE ENGINEER'S NOTICE TO CONTRACTORS:

THE EXISTENCE AND LOCATION OF ANY UNDERGROUND UTILITIES AND/OR STRUCTURES SHOWN ON THE PLANS ARE OBTAINED BY SEARCH OF AVAILABLE RECORDS. TO THE BEST OF OUR KNOWLEDGE THERE ARE NO EXISTING UTILITIES EXCEPT AS SHOWN ON THIS PLAN. THE CONTRACTOR IS REQUIRED TO TAKE DUE PRECAUTIONARY MEASURES TO PROTECT THE UTILITY LINES AND ANY OTHER LINES NOT SHOWN ON THIS PLAN. PRIOR TO EXCAVATION, THE CONTRACTOR SHALL CALL 800-4-A-HEAD FOR THE UNDERGROUND UTILITY LOCATION UTILITY LINES. THE CONTRACTOR SHALL ALSO CALL THE APPLICABLE UTILITY COMPANIES TO VERIFY THE LOCATIONS.

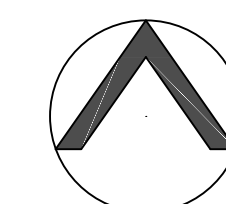

SCALE: 1" = 20'-0"

C203

8 OF 12